

ALL INDIA INSTITUTE OF MEDICAL SCIENCES (AIIMS), ANSARI NAGAR, NEW DELHI

Tender

For

Renovation of CCU at CN Centre at AIIMS, Ansari Nagar, New Delhi

Volume-VI

TENDER DRAWINGS

December' 2012



HSCC (INDIA) LTD.
(CONSULTANTS & ENGINEERS FOR MEGA HOSPITALS & LABORATORIES)
E-6(A), sector-1, NOIDA(U.P) 201301 (India)






Phone : 0120-2542436-40

Fax : 0120-2542447

Tender No. HSCC/ AIIMS/ CCU/2012/03

TENDER DRAWING


ARCHITECTURAL

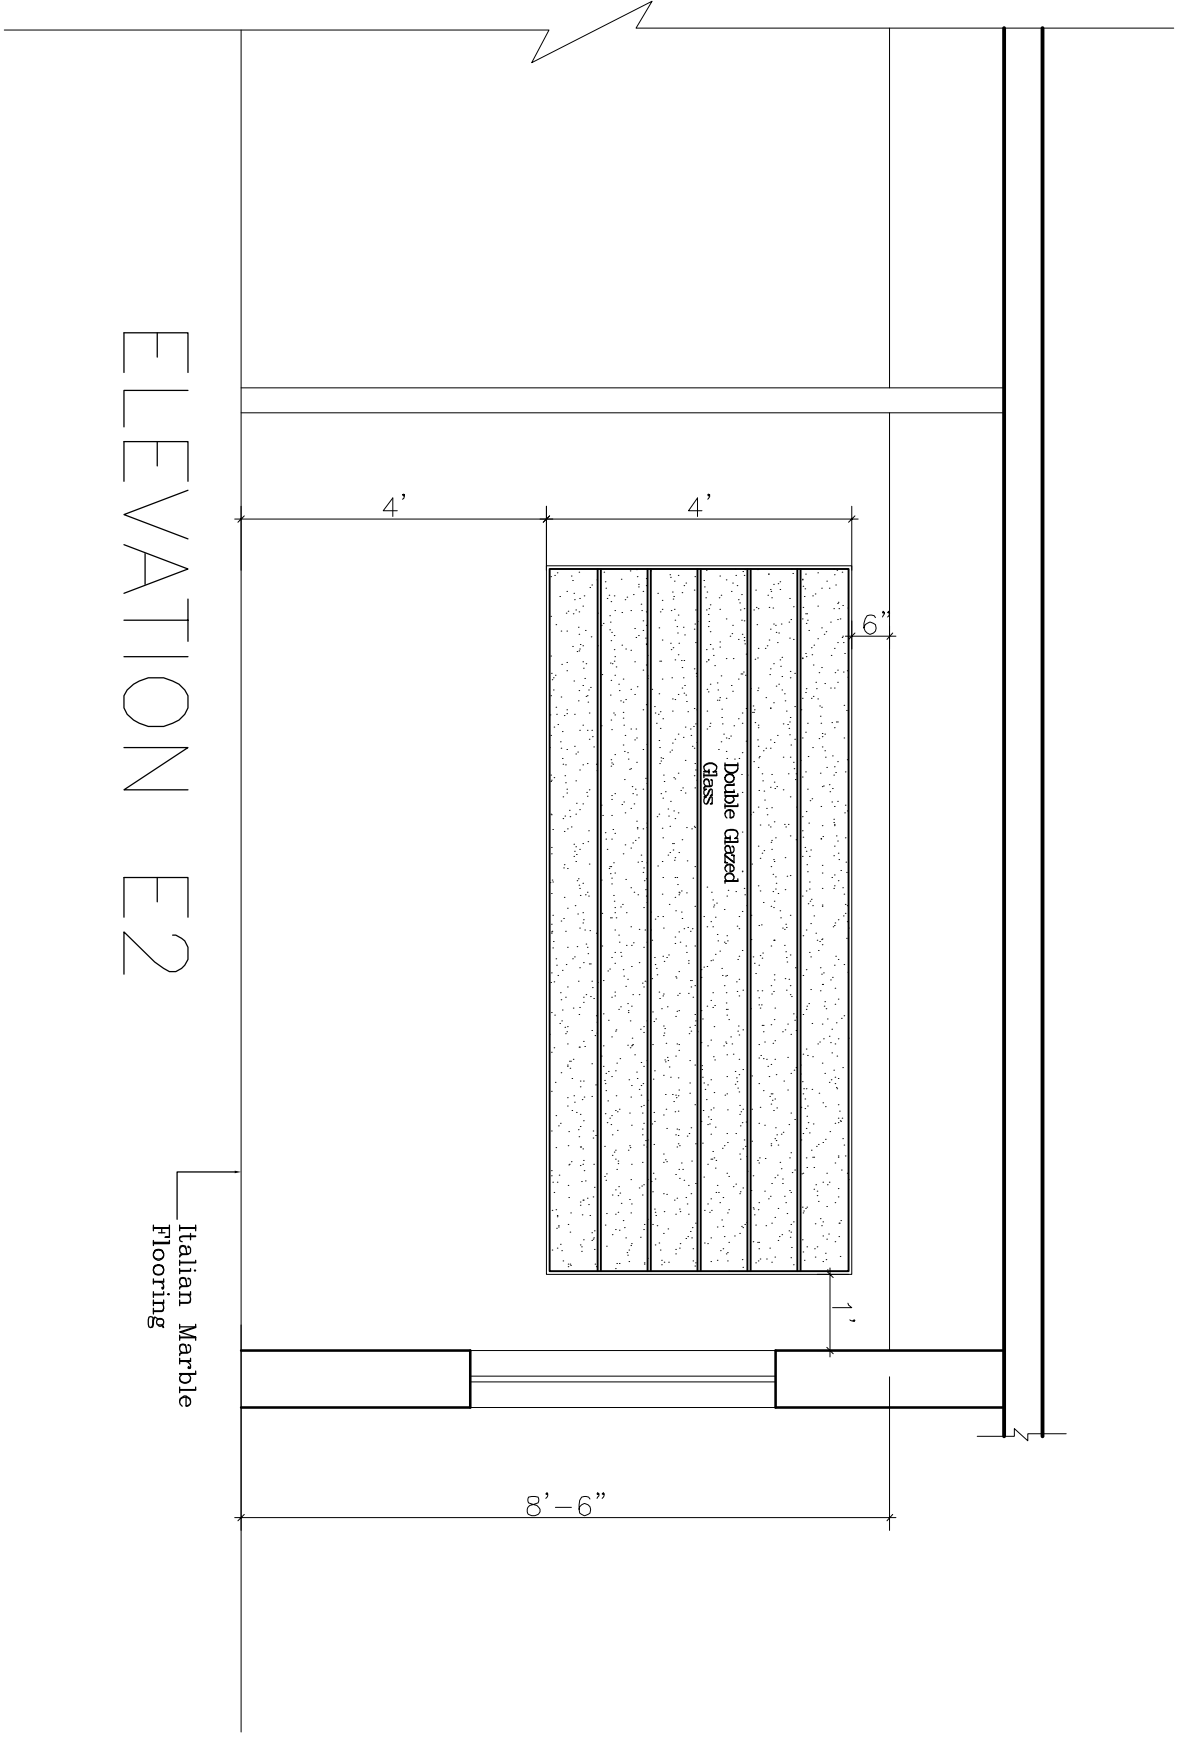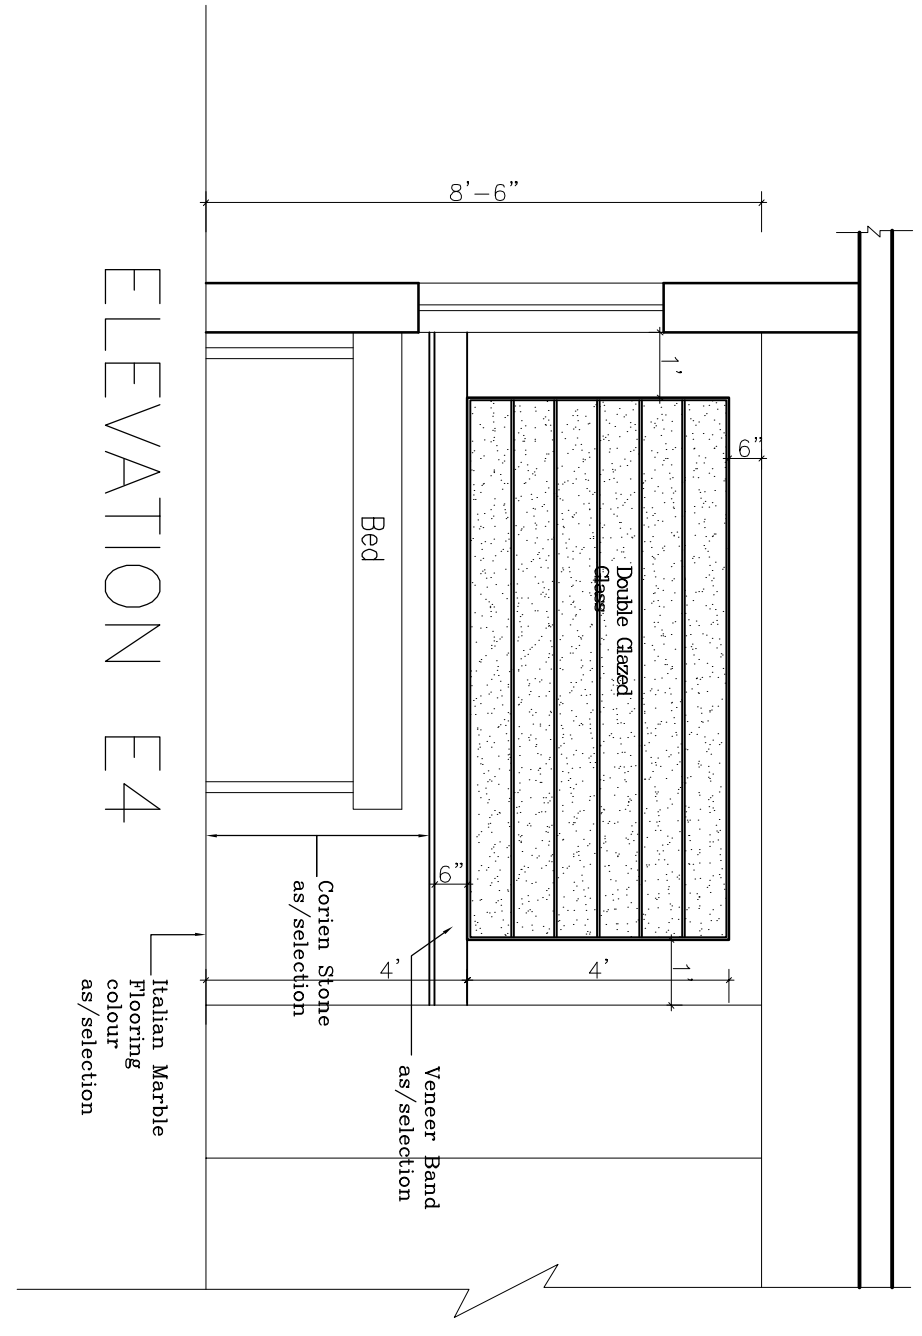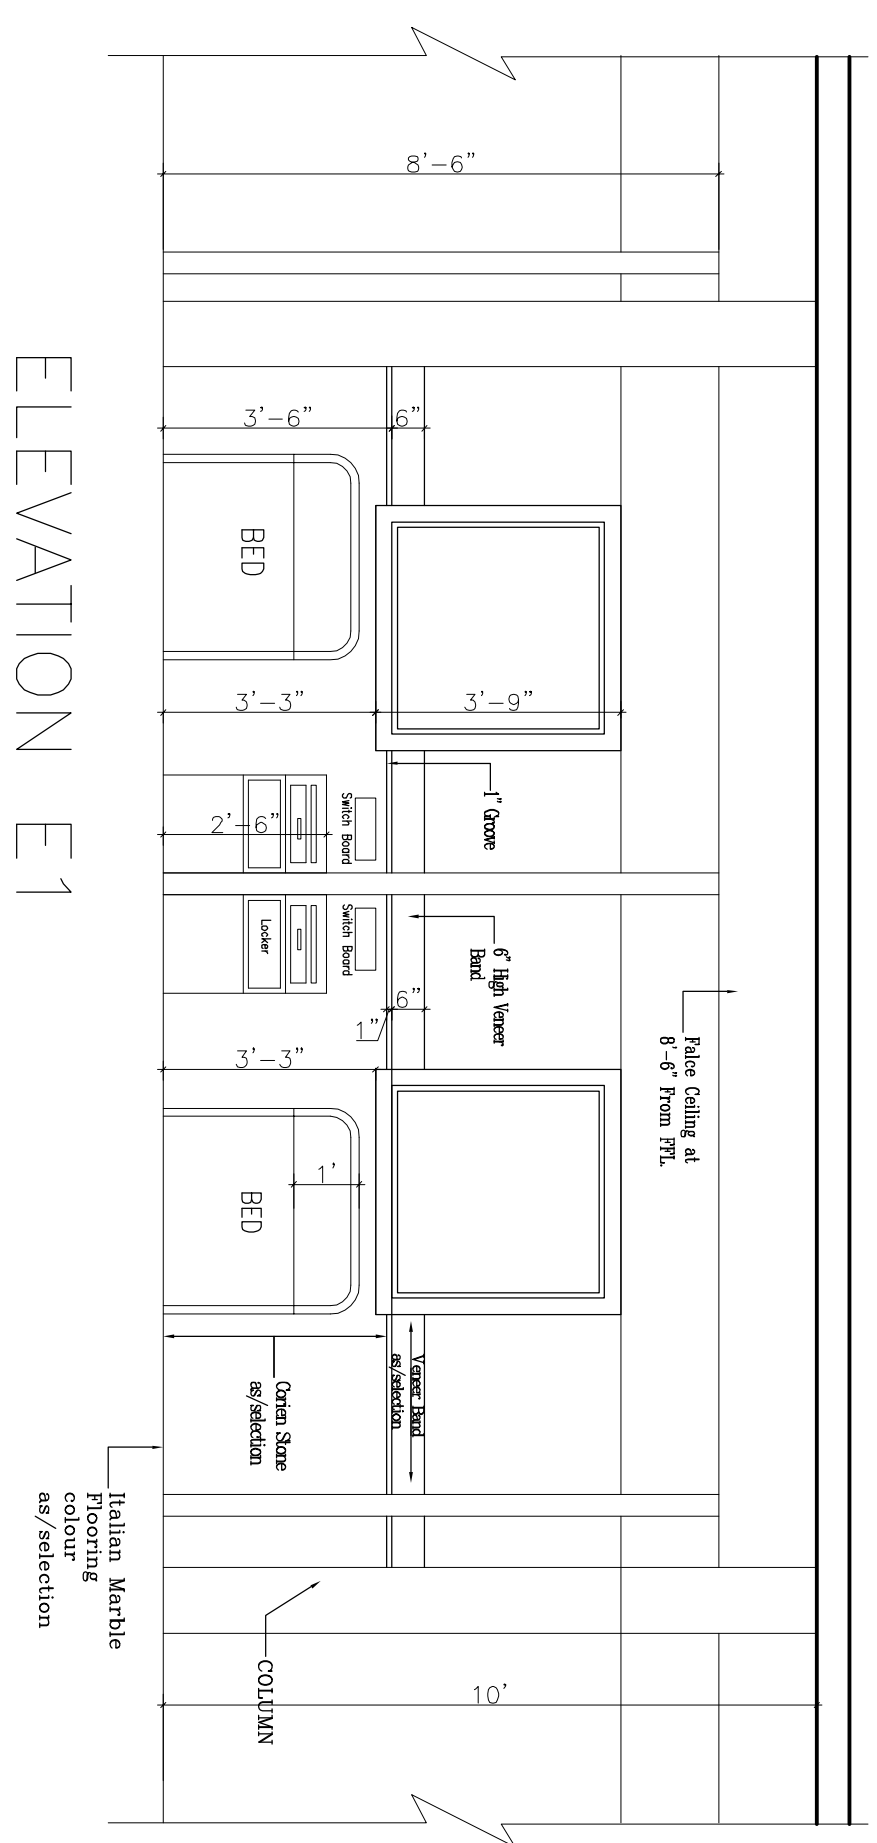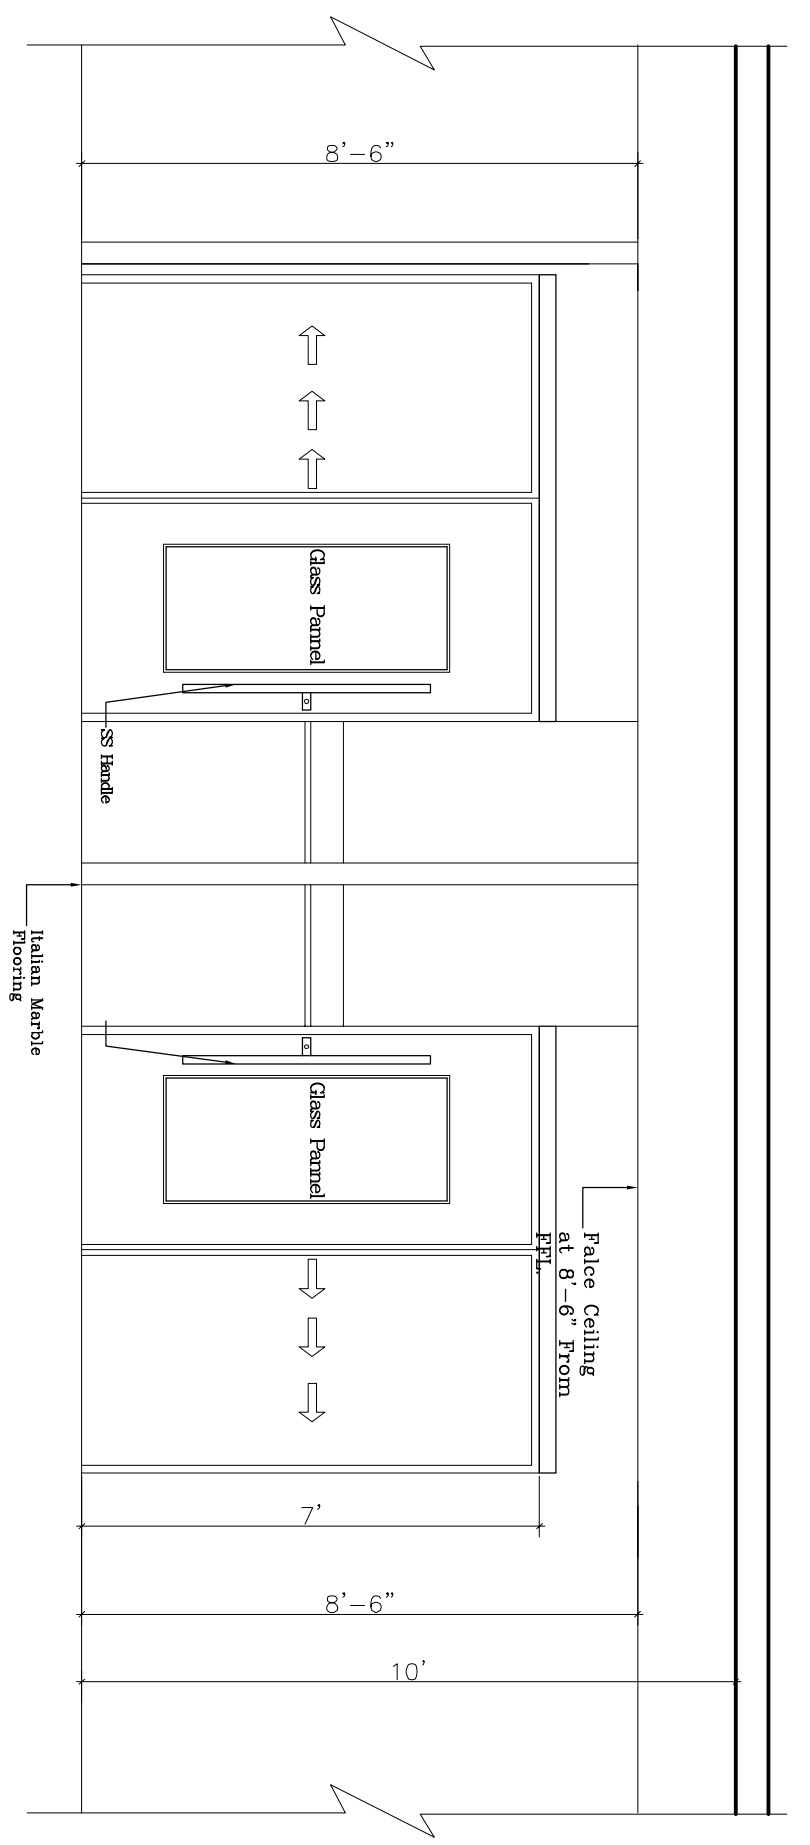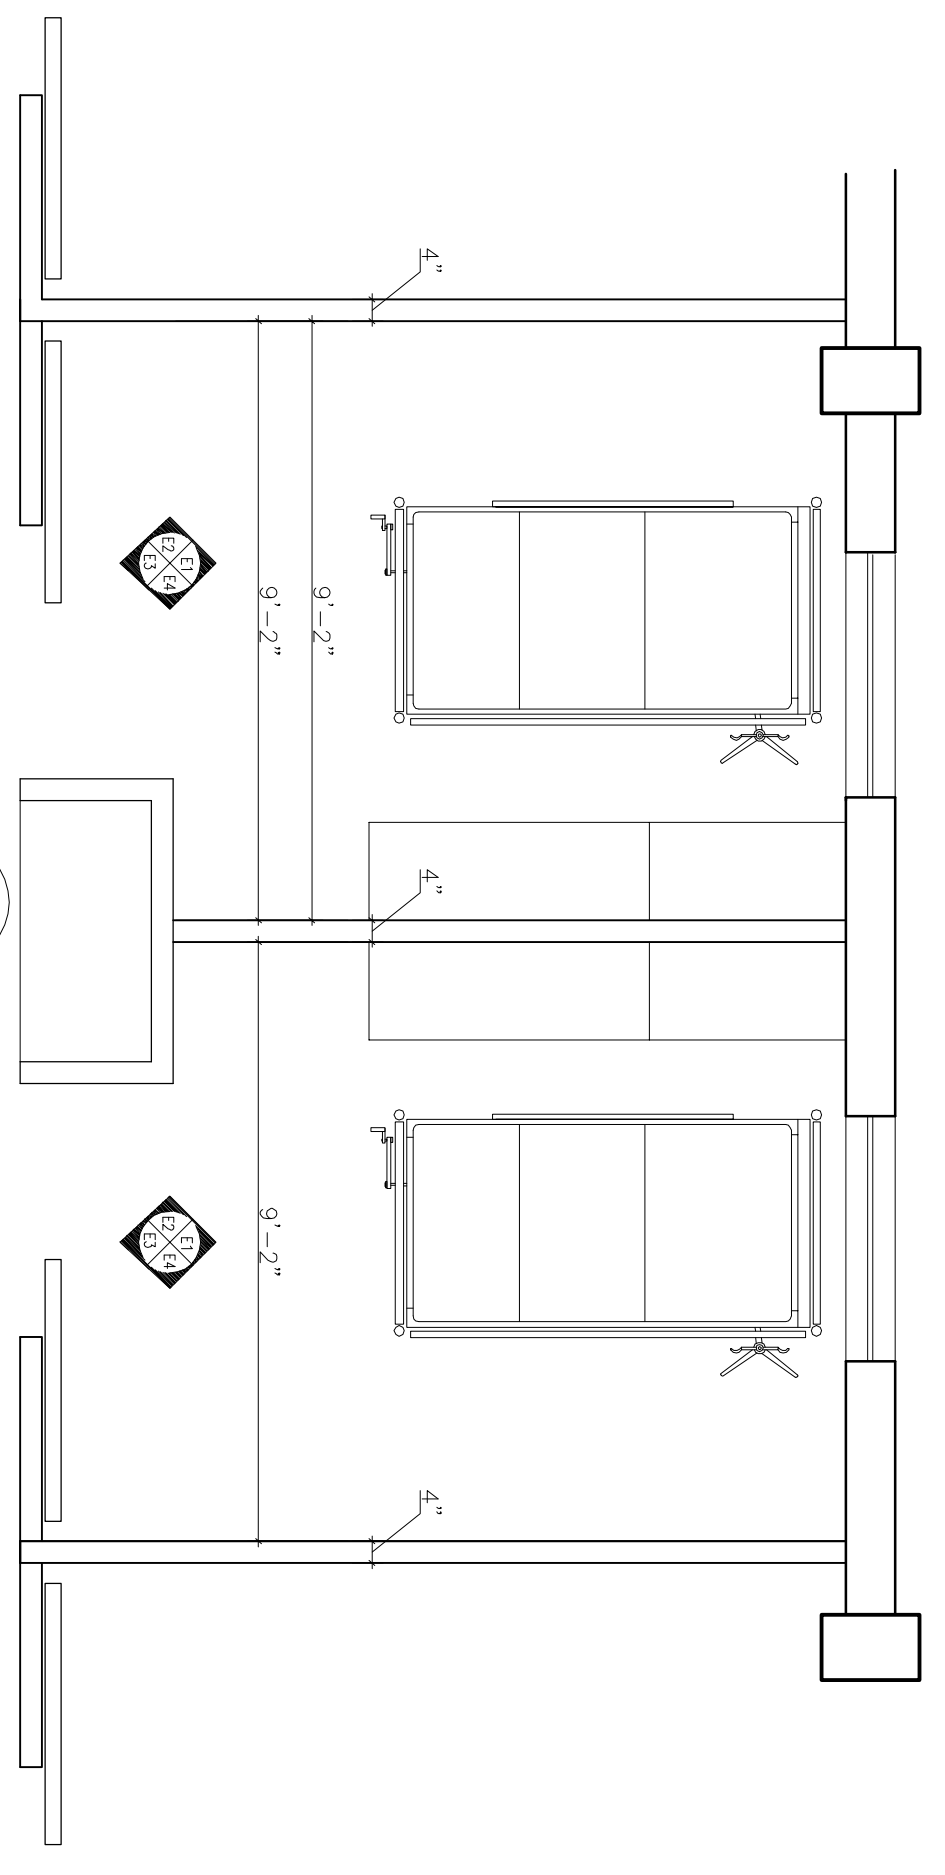

NOTES
 This drawing with all its intellectual property of the Hospital Services Consulting Corporation (HSCC) is the property of HSCC. No part of this drawing or part thereof or its use in any form without the prior written permission of HSCC is authorized.

PROJECT			
All India Institute of Medical Science New-Delhi			
TITLE			
CCU			
CCU Room Detail			
HSCC/AIIMS		DRAWING NO.	
JOB NO.	SCALE	DATE	10-03-2011
Job. No.	Scale	Date:	
App by	Rev. by	Prep. by	

PLAN

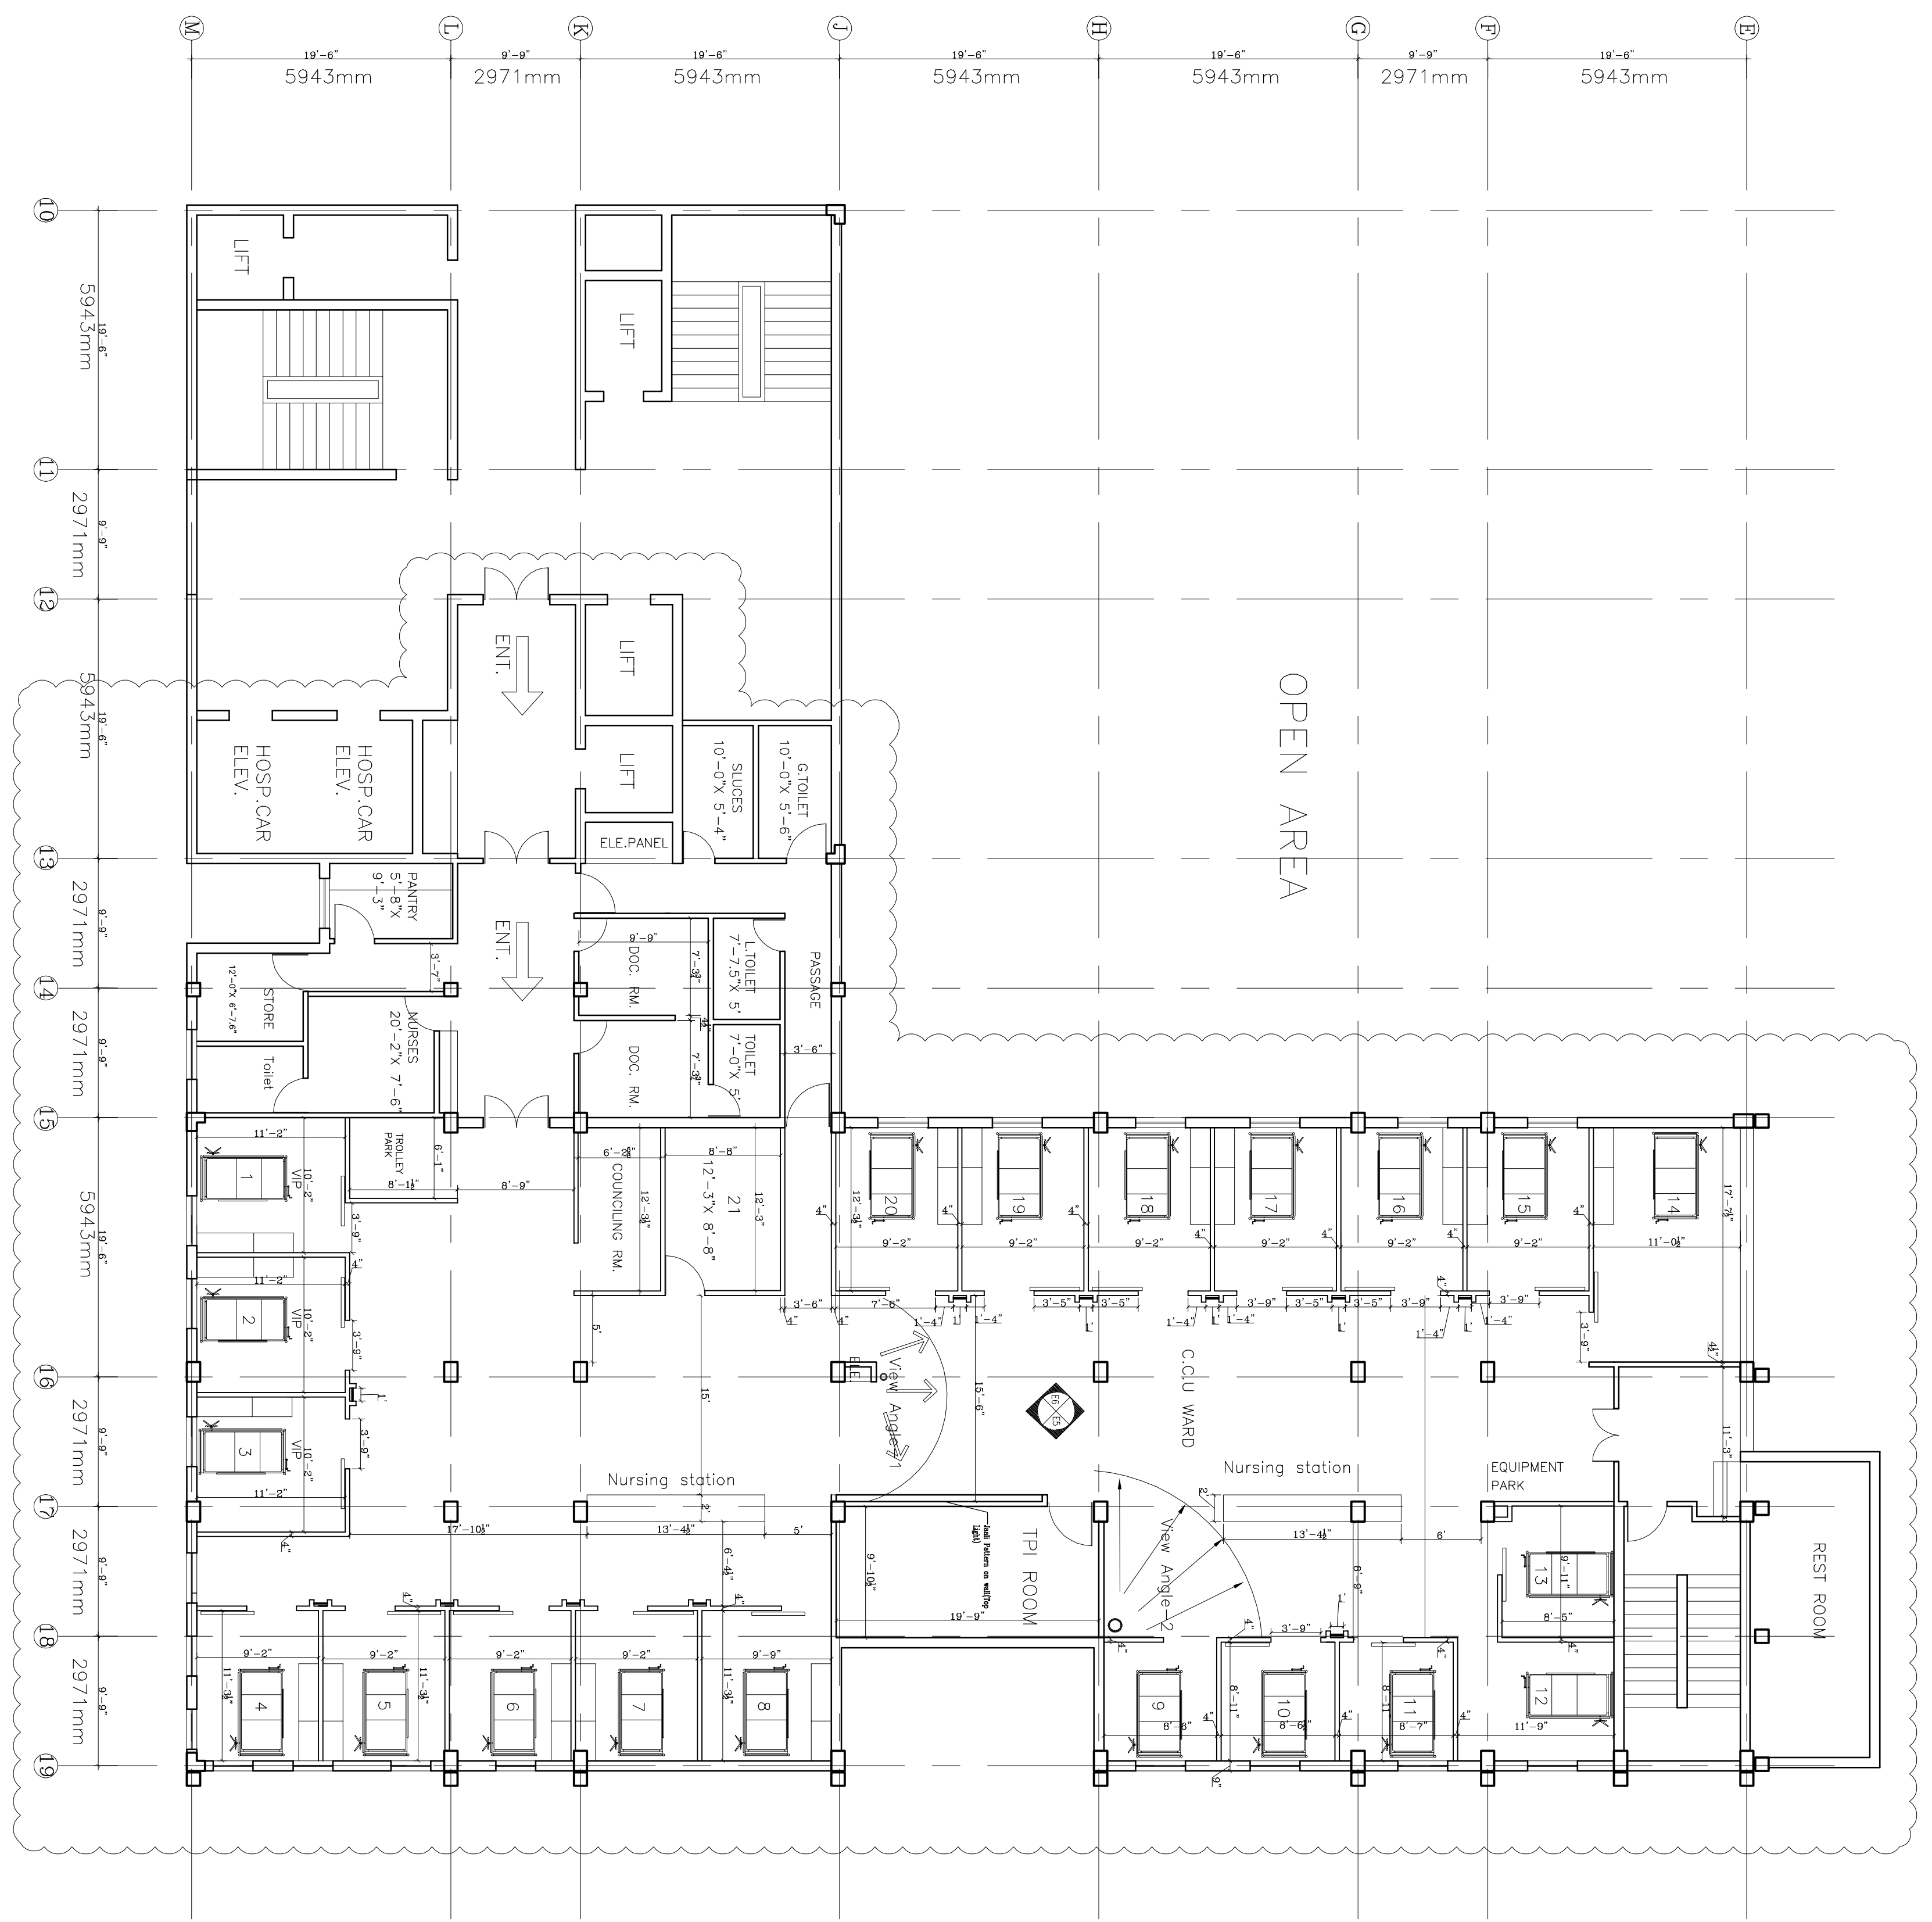


NOTES

All India Institute of
 Medical Science
 New-Delhi

CCU	
CCU Room Detail	
HSCC/AIIMS	
Drawing No.	
Job No.	Scale
Date:	
App. By:	Rev. By
	Prep. By

TENDER DRAWING

ELECTRICAL

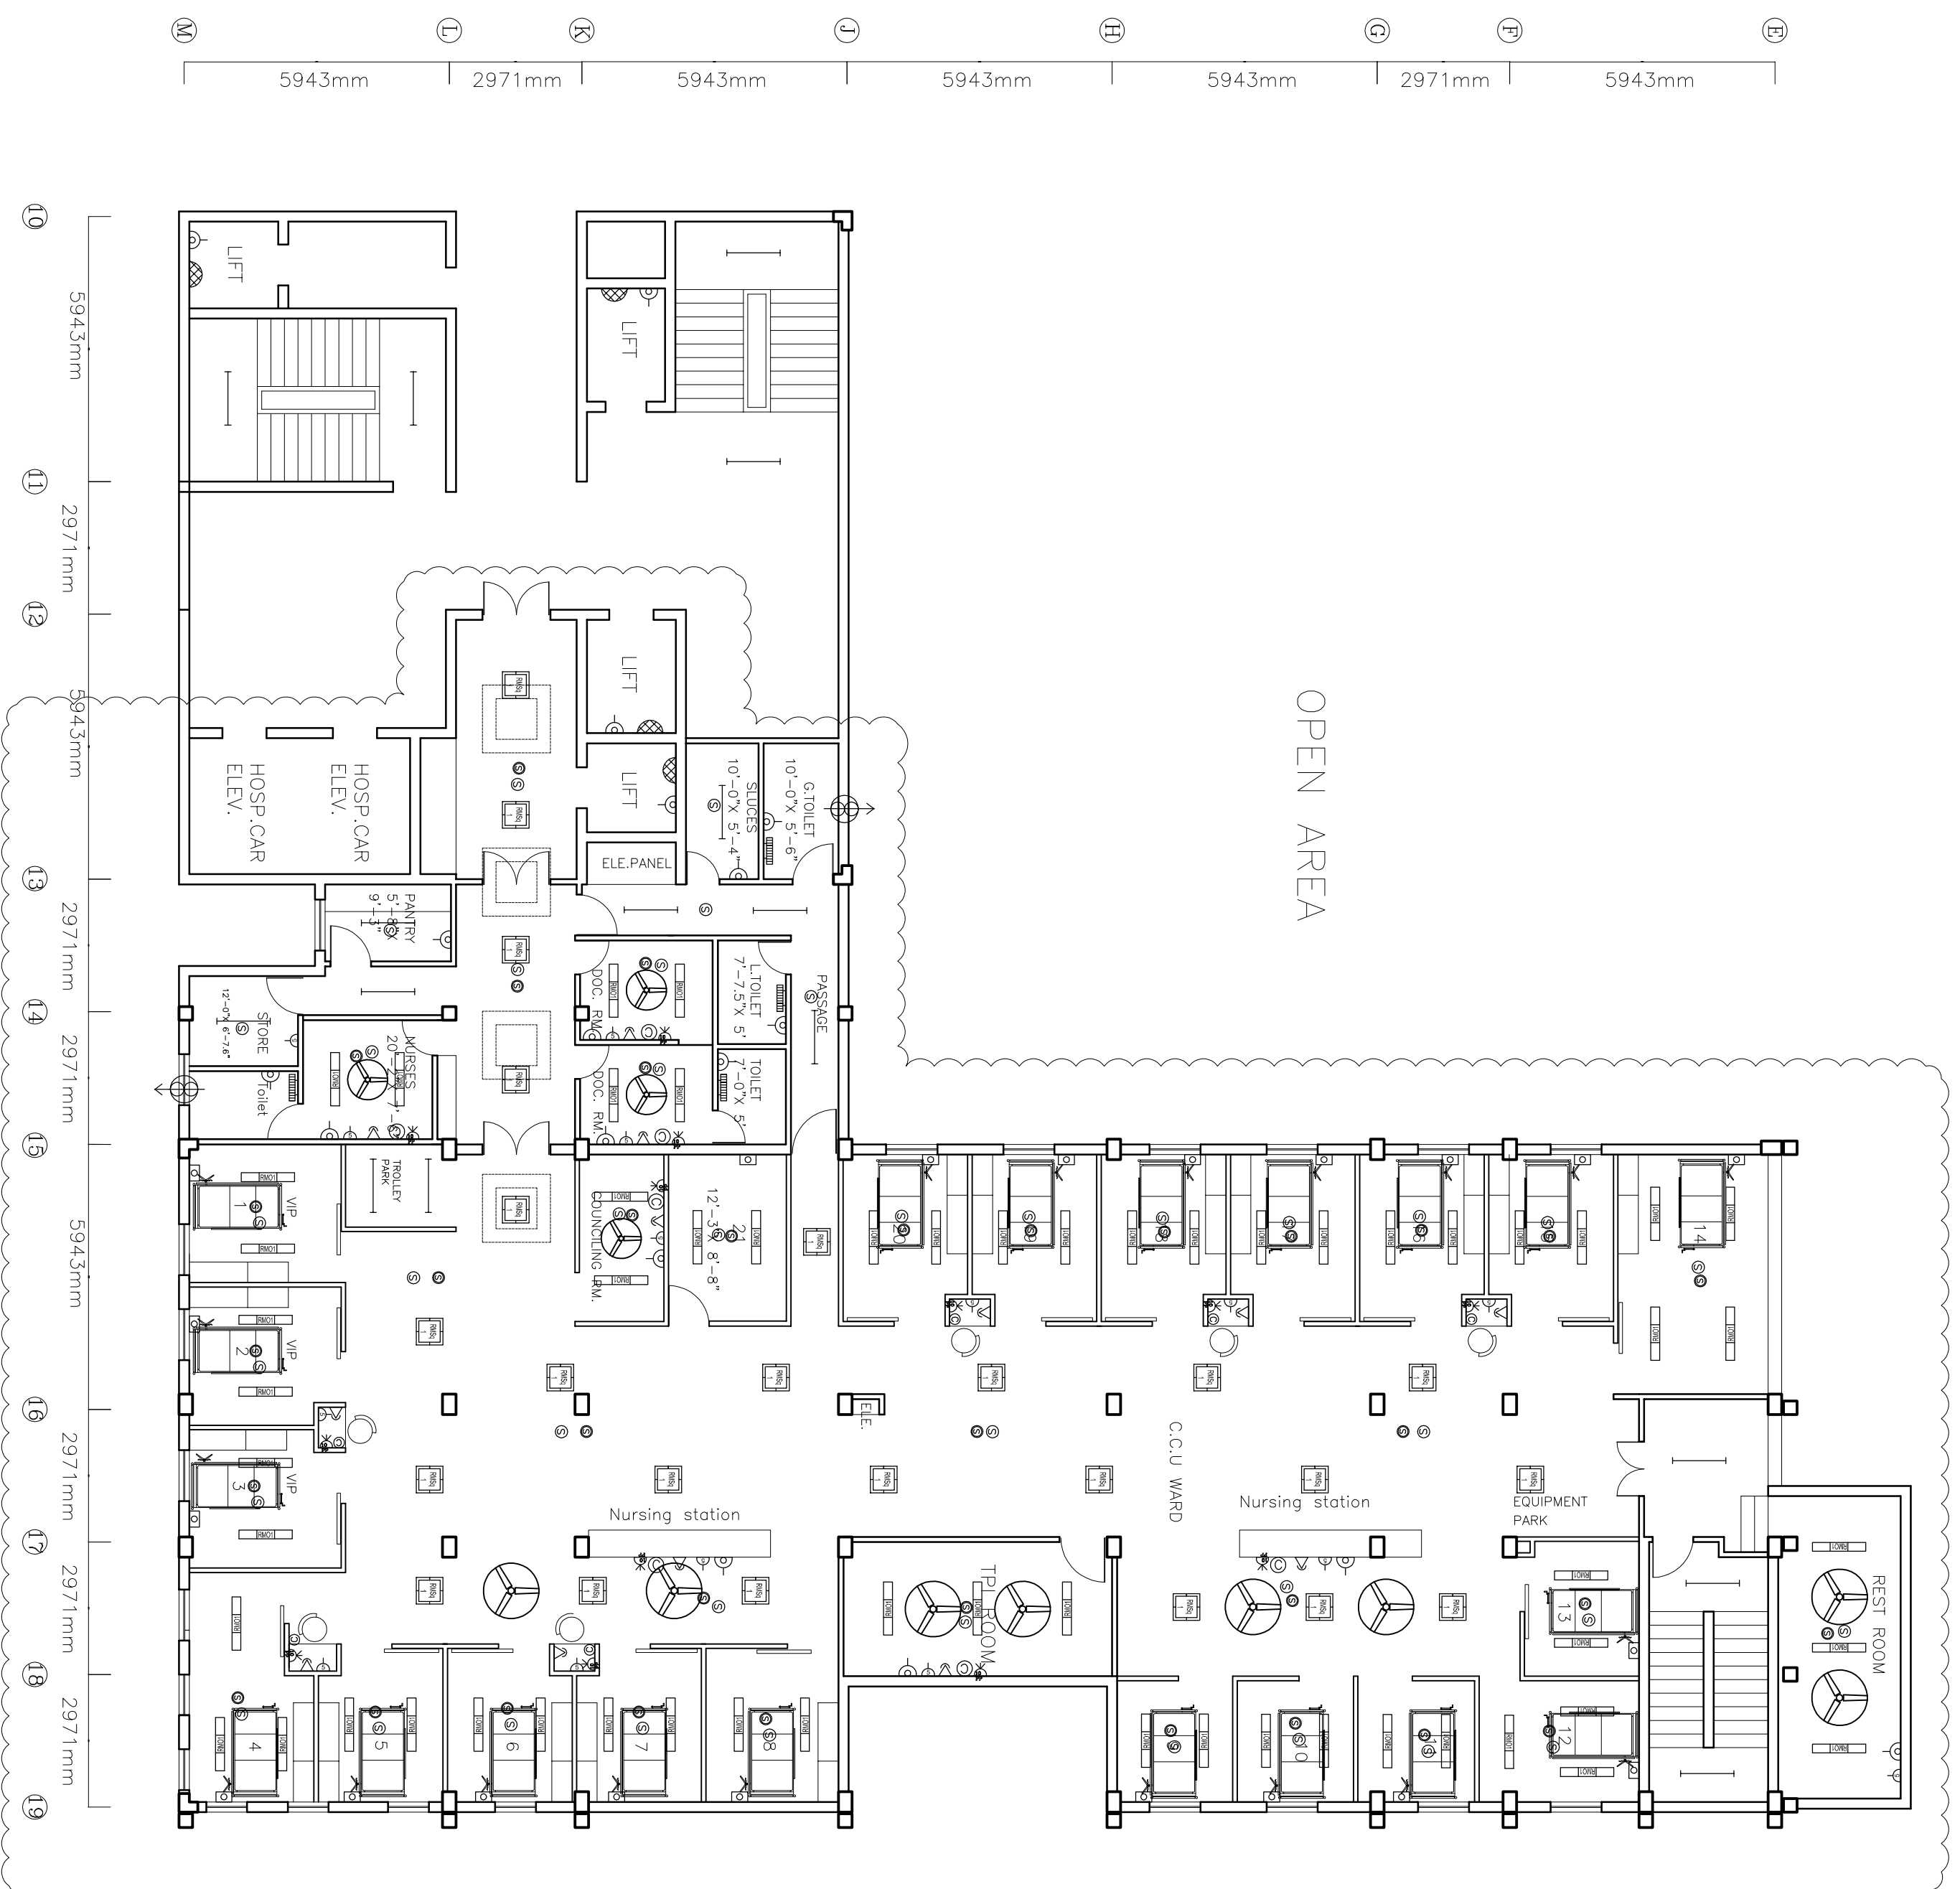

NOTES

PROJECT

**All India Institute of
Medical Science
New - Delhi**

TITLE

CCU


Electrical Layout

HSCC/D&E /AIMS/CCU/EL-01
Drawing No.

Job No.	NTS	Scale	Date:
Appr. By:	Rev. By:	Prep. By:	

TENDER DRAWING

HVAC

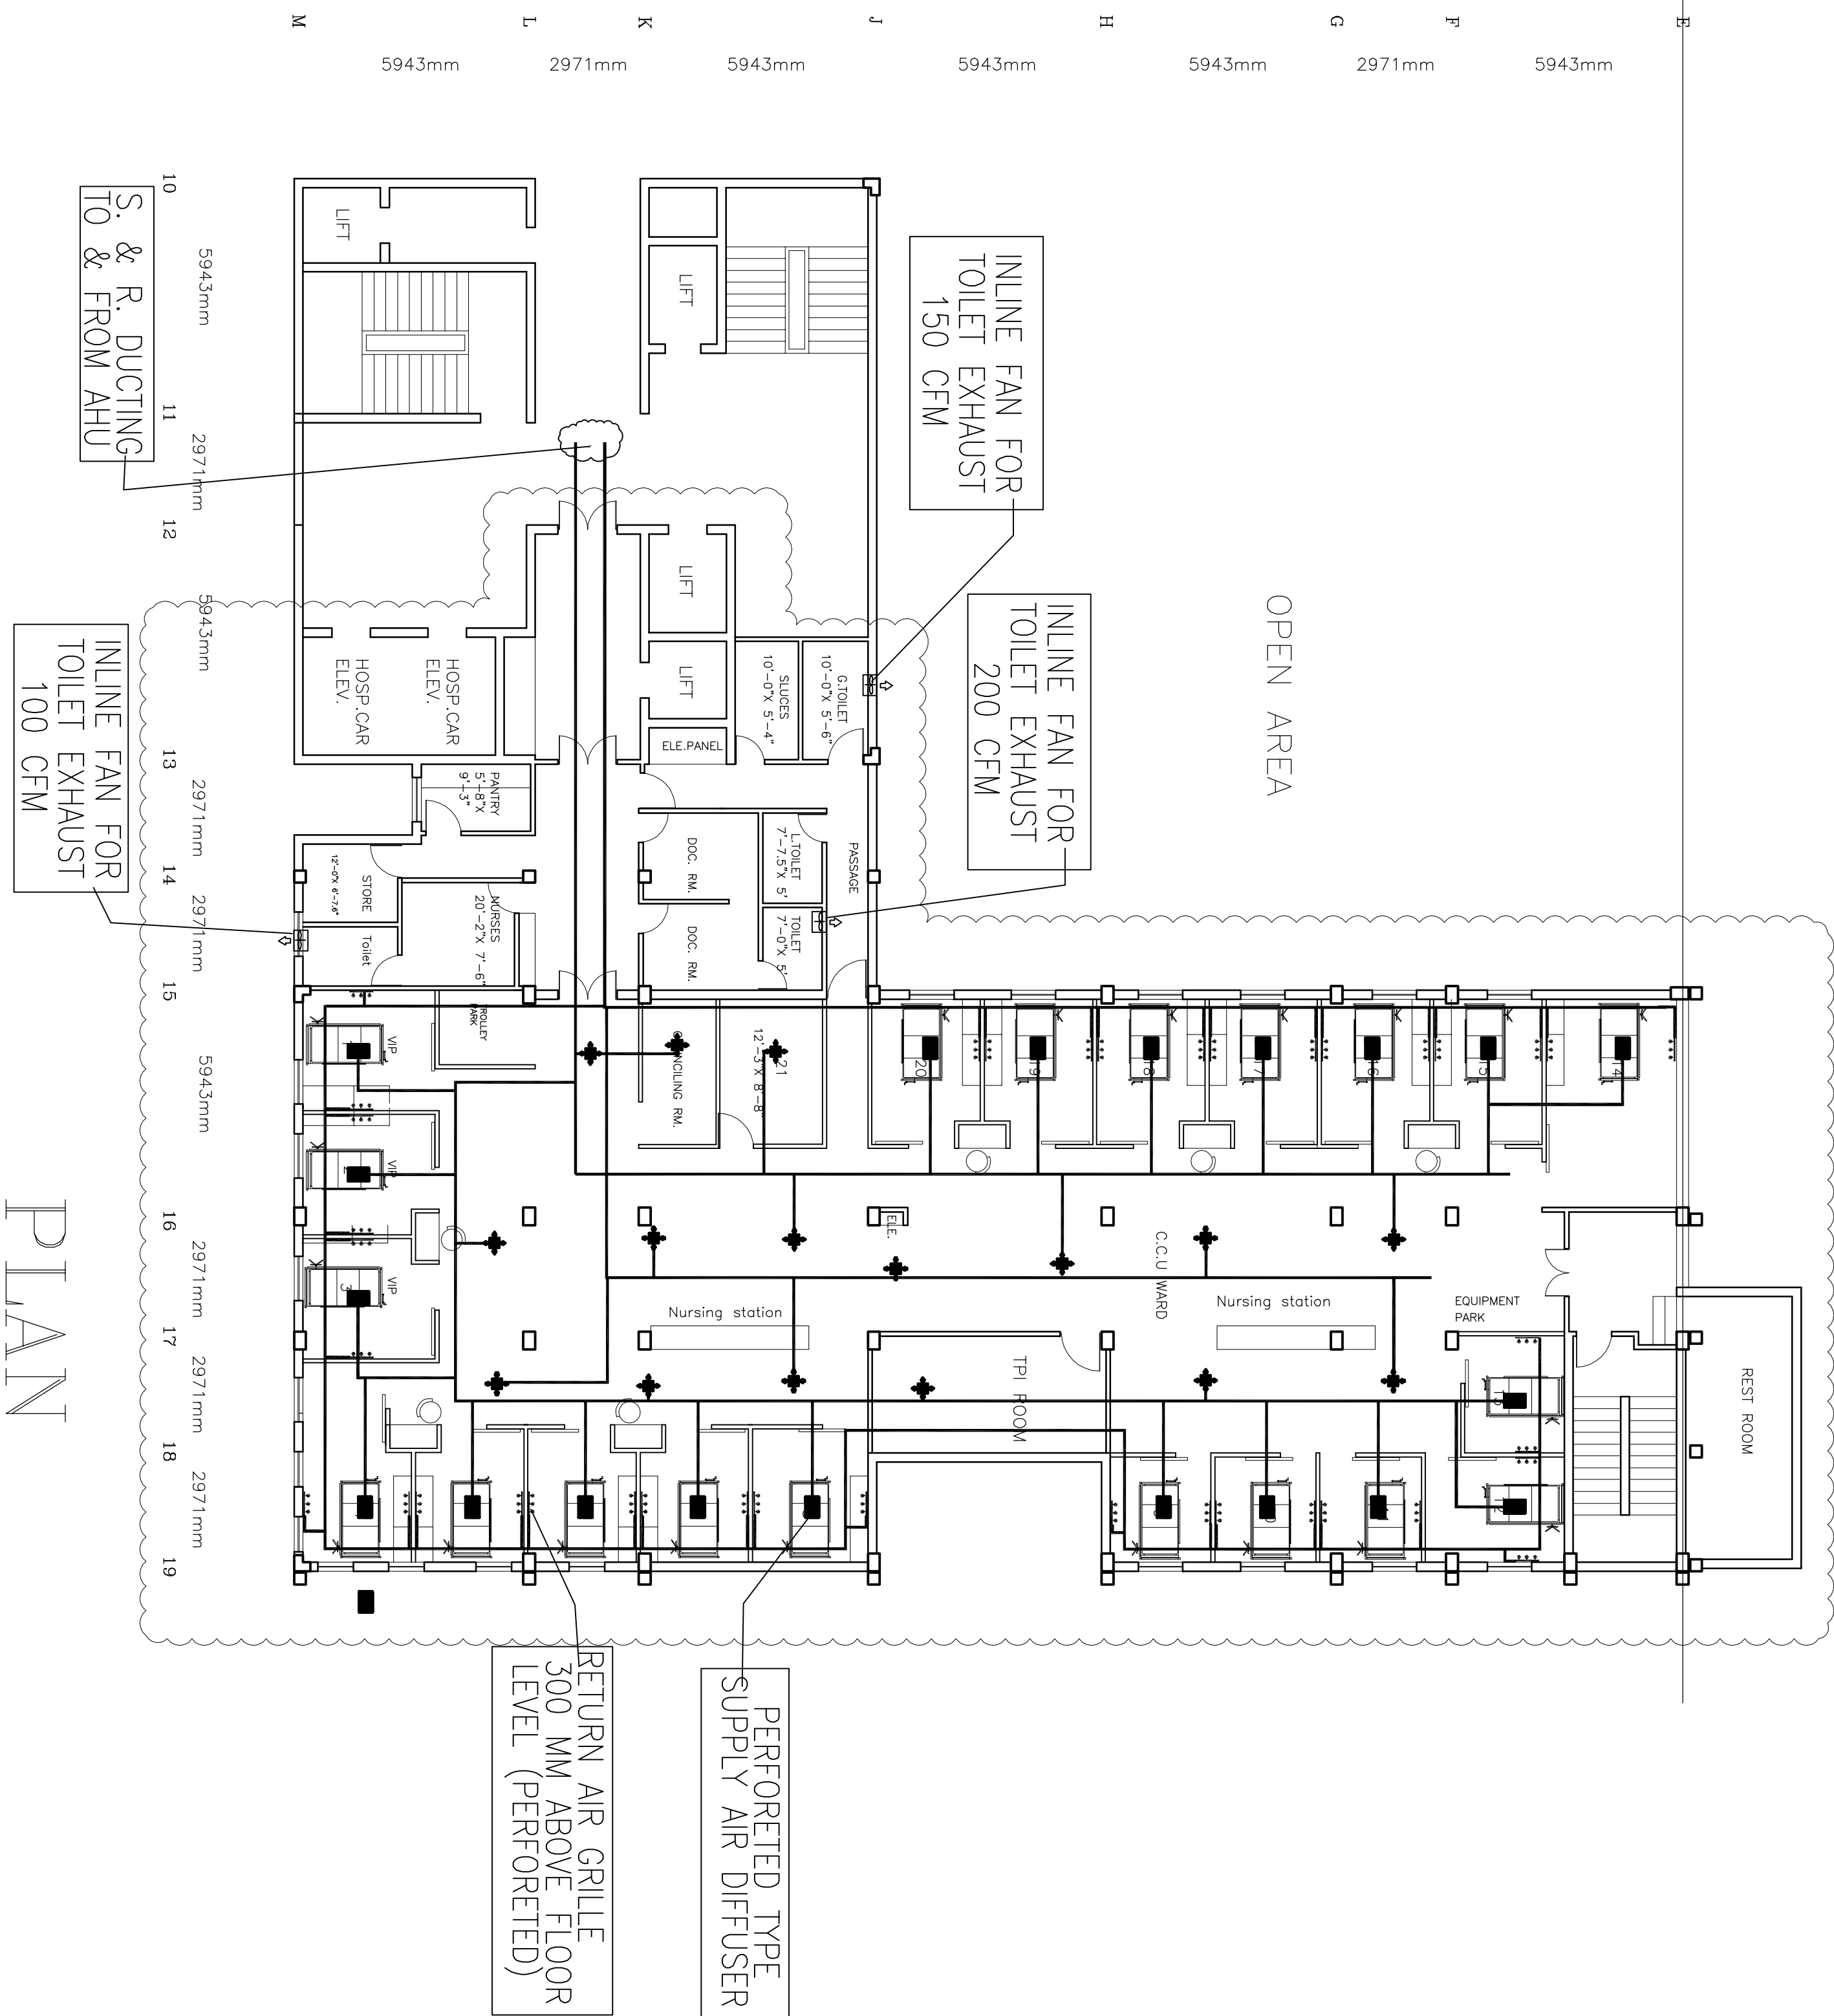

NOTES	
-------	--

All India Institute of Medical Science
 New-Delhi

TENDER DRAWING

CCU-RENOVATION
 HVAC LAYOUT
 Scheme purpose only

HSCC/D&E/CCU-AIIMS/HVAC	
Drawing No.	
Job No.	Scale
App. By.	Rev. By
	Prep. By



**END OF
VOLUME - VI**