

PIPE SCHEDULE:		
SNO.	DESCRIPTION	SYMBOL
1.	MANHOLE TO MANHOLE (R/C NP)	150P
2.	GULLY TRAP TO MANHOLE (S.W.)	150P
3.	W.C TO MANHOLE (C/L)	150P
4.	SOL AND VENT PIPE TO MANHOLE (C/L)	100P
5.	WASTE AND VENT PIPE TO GULLY TRAP (C/L)	100/75P
6.	FLOOR TRAP TO GULLY TRAP (C/L)	100/75P
7.	FLOOR TRAP TO WASTE AND VENT PIPE (C/L)	100/75P
8.	FLOOR DRAIN TO FLOOR TRAP (C/L)	50 P
9.	BOTTLE TRAP TO FLOOR TRAP (C/L)	32 P
10.	BOTTLE TRAP TO URINAL TRAP (C/L)	40 P

HEIGHT OF FIXTURES		
FIXTURES	LOCATION	HEIGHT IN FT. FROM F.F.L.
BB TAP	BATH ROOM	265
CONCEALED STOP COCKS	BATH ROOM	1220
SHOWER	BATH ROOM	2200
GEYSER POSITION	BATH ROOM	1525
ABLUTION TAP	TOILET	300
DISIENN FOR W.C.	TOILET	1000
WASH BASIN	BATH ROOM	850
SINK	KITCHEN	900

LEGEND		
NO.	DESCRIPTION	SYMBOL
1	100# CCI SOL PIPE	①
2	100# CCI WASTE PIPE	②
3	100# RAIN WATER PIPE	③
4	COLD WATER SUPPLY PIPE	④
5	FLUSHING WATER SUPPLY	⑤
6	HOT WATER SUPPLY	⑥

LEGEND:		
SYMBOL	DESCRIPTION	SYMBOL
FD	FLOOR DRAIN C/L	FD
FT	FLOOR TRAP	FT
BT	BOTTLE TRAP OF BRASS	BT
AT	ABLUTION TAP OF BRASS	AT
+	TW WATER SUPPLY	+
+	LW WATER SUPPLY	+
+	HOT WATER SUPPLY (C.P.V.C. CLASS B)	+
+	EUROPEAN W.C. WITH ISOLS LOW LEVEL CISTERN & OF FLOW	+
+	WASH BASIN	+
+	OVAL SHAPE WASH BASIN	+
+	GULLY TRAP 300X300 C/L COVER OF SIZE 300X300	+
+	MANHOLE 900X900 C/L COVER OF SIZE 500X450	+
+	SLICE VALVE	+
+	NON-RETURN VALVE	+
+	GEYSER	+
+	DIVERTOR MIXER	+
+	SHOWER (WITH SINGLE LEVER DIVERTOR)	+
+	ROAD GULLY CHAMBER	+

REV	DATE	DESCRIPTION
REVISION		

PROJECT
 NRHM PROJECT
 Proposed 50 Bedded Hospital at JASHPUR, CHATTISGARH

TITLE
 TENDER DRAWING
 TERRACE FLOOR PLAN

PL-04/WD/HOSP/PL-04 Drawing No.	Revision
BSSC/PL-04 Job No.	1:100 Scale
App by	Chkd. by
	Prep. by

HSCC (INDIA) LIMITED
 (A GOVERNMENT OF INDIA ENTERPRISE)
HSCC
 NEW DELHI INDIA

This drawing with all its contents is the sole intellectual property of the Hospital Services Consultancy Corporation (India) Ltd. Copying of this drawing or part thereof, its use in any form whatsoever without the written permission of HSCC is prohibited.

NOTES

S.No.	SYMBOL	DESCRIPTION
1	[Symbol]	100 MM CEILING FAN
2	[Symbol]	1000 MM CEILING FAN
3	[Symbol]	1000 MM WALL SWICH TYPE FLOORSWICH LIGHT FIXTURE
4	[Symbol]	1000 MM WALL SWICH TYPE FLOORSWICH LIGHT FIXTURE (PHASED NOT USED THIS SWICH SW)
5	[Symbol]	1000 MM WALL SWICH TYPE FLOORSWICH LIGHT FIXTURE (PHASED NOT USED THIS SWICH SW)
6	[Symbol]	1000 MM WALL SWICH TYPE FLOORSWICH LIGHT FIXTURE (PHASED NOT USED THIS SWICH SW)
7	[Symbol]	1000 MM WALL SWICH TYPE FLOORSWICH LIGHT FIXTURE (PHASED NOT USED THIS SWICH SW)
8	[Symbol]	1000 MM WALL SWICH TYPE FLOORSWICH LIGHT FIXTURE (PHASED NOT USED THIS SWICH SW)
9	[Symbol]	1000 MM WALL SWICH TYPE FLOORSWICH LIGHT FIXTURE (PHASED NOT USED THIS SWICH SW)
10	[Symbol]	1000 MM WALL SWICH TYPE FLOORSWICH LIGHT FIXTURE (PHASED NOT USED THIS SWICH SW)
11	[Symbol]	1000 MM WALL SWICH TYPE FLOORSWICH LIGHT FIXTURE (PHASED NOT USED THIS SWICH SW)
12	[Symbol]	1000 MM WALL SWICH TYPE FLOORSWICH LIGHT FIXTURE (PHASED NOT USED THIS SWICH SW)
13	[Symbol]	1000 MM WALL SWICH TYPE FLOORSWICH LIGHT FIXTURE (PHASED NOT USED THIS SWICH SW)
14	[Symbol]	1000 MM WALL SWICH TYPE FLOORSWICH LIGHT FIXTURE (PHASED NOT USED THIS SWICH SW)
15	[Symbol]	1000 MM WALL SWICH TYPE FLOORSWICH LIGHT FIXTURE (PHASED NOT USED THIS SWICH SW)
16	[Symbol]	1000 MM WALL SWICH TYPE FLOORSWICH LIGHT FIXTURE (PHASED NOT USED THIS SWICH SW)
17	[Symbol]	1000 MM WALL SWICH TYPE FLOORSWICH LIGHT FIXTURE (PHASED NOT USED THIS SWICH SW)
18	[Symbol]	1000 MM WALL SWICH TYPE FLOORSWICH LIGHT FIXTURE (PHASED NOT USED THIS SWICH SW)
19	[Symbol]	1000 MM WALL SWICH TYPE FLOORSWICH LIGHT FIXTURE (PHASED NOT USED THIS SWICH SW)
20	[Symbol]	1000 MM WALL SWICH TYPE FLOORSWICH LIGHT FIXTURE (PHASED NOT USED THIS SWICH SW)
21	[Symbol]	1000 MM WALL SWICH TYPE FLOORSWICH LIGHT FIXTURE (PHASED NOT USED THIS SWICH SW)
22	[Symbol]	1000 MM WALL SWICH TYPE FLOORSWICH LIGHT FIXTURE (PHASED NOT USED THIS SWICH SW)
23	[Symbol]	1000 MM WALL SWICH TYPE FLOORSWICH LIGHT FIXTURE (PHASED NOT USED THIS SWICH SW)
24	[Symbol]	1000 MM WALL SWICH TYPE FLOORSWICH LIGHT FIXTURE (PHASED NOT USED THIS SWICH SW)
25	[Symbol]	1000 MM WALL SWICH TYPE FLOORSWICH LIGHT FIXTURE (PHASED NOT USED THIS SWICH SW)
26	[Symbol]	1000 MM WALL SWICH TYPE FLOORSWICH LIGHT FIXTURE (PHASED NOT USED THIS SWICH SW)
27	[Symbol]	1000 MM WALL SWICH TYPE FLOORSWICH LIGHT FIXTURE (PHASED NOT USED THIS SWICH SW)
28	[Symbol]	1000 MM WALL SWICH TYPE FLOORSWICH LIGHT FIXTURE (PHASED NOT USED THIS SWICH SW)
29	[Symbol]	1000 MM WALL SWICH TYPE FLOORSWICH LIGHT FIXTURE (PHASED NOT USED THIS SWICH SW)
30	[Symbol]	1000 MM WALL SWICH TYPE FLOORSWICH LIGHT FIXTURE (PHASED NOT USED THIS SWICH SW)
31	[Symbol]	1000 MM WALL SWICH TYPE FLOORSWICH LIGHT FIXTURE (PHASED NOT USED THIS SWICH SW)
32	[Symbol]	1000 MM WALL SWICH TYPE FLOORSWICH LIGHT FIXTURE (PHASED NOT USED THIS SWICH SW)
33	[Symbol]	1000 MM WALL SWICH TYPE FLOORSWICH LIGHT FIXTURE (PHASED NOT USED THIS SWICH SW)
34	[Symbol]	1000 MM WALL SWICH TYPE FLOORSWICH LIGHT FIXTURE (PHASED NOT USED THIS SWICH SW)
35	[Symbol]	1000 MM WALL SWICH TYPE FLOORSWICH LIGHT FIXTURE (PHASED NOT USED THIS SWICH SW)
36	[Symbol]	1000 MM WALL SWICH TYPE FLOORSWICH LIGHT FIXTURE (PHASED NOT USED THIS SWICH SW)
37	[Symbol]	1000 MM WALL SWICH TYPE FLOORSWICH LIGHT FIXTURE (PHASED NOT USED THIS SWICH SW)
38	[Symbol]	1000 MM WALL SWICH TYPE FLOORSWICH LIGHT FIXTURE (PHASED NOT USED THIS SWICH SW)
39	[Symbol]	1000 MM WALL SWICH TYPE FLOORSWICH LIGHT FIXTURE (PHASED NOT USED THIS SWICH SW)
40	[Symbol]	1000 MM WALL SWICH TYPE FLOORSWICH LIGHT FIXTURE (PHASED NOT USED THIS SWICH SW)

REV	DATE	DESCRIPTION
REVISION		


PROJECT
 NRHM PROJECT
 Proposed 50 Bedded Hospital at JASHPUR, CHATTISGARH

TITLE
 TENDER DRAWING
 GROUND FLOOR PLAN ELECTRICAL LIGHTING & CONDUIT LAYOUT

HSCC/EV210/EL/HOSP/002A
 Drawing No. _____ Rev. _____

HSCC/- Job No.	1:125 Scale	Date
Drawn by :	Rev. by	Prep. by

HSCC (INDIA) LIMITED
 (A GOVERNMENT OF INDIA ENTERPRISES)
HSCC
 NEW DELHI INDIA

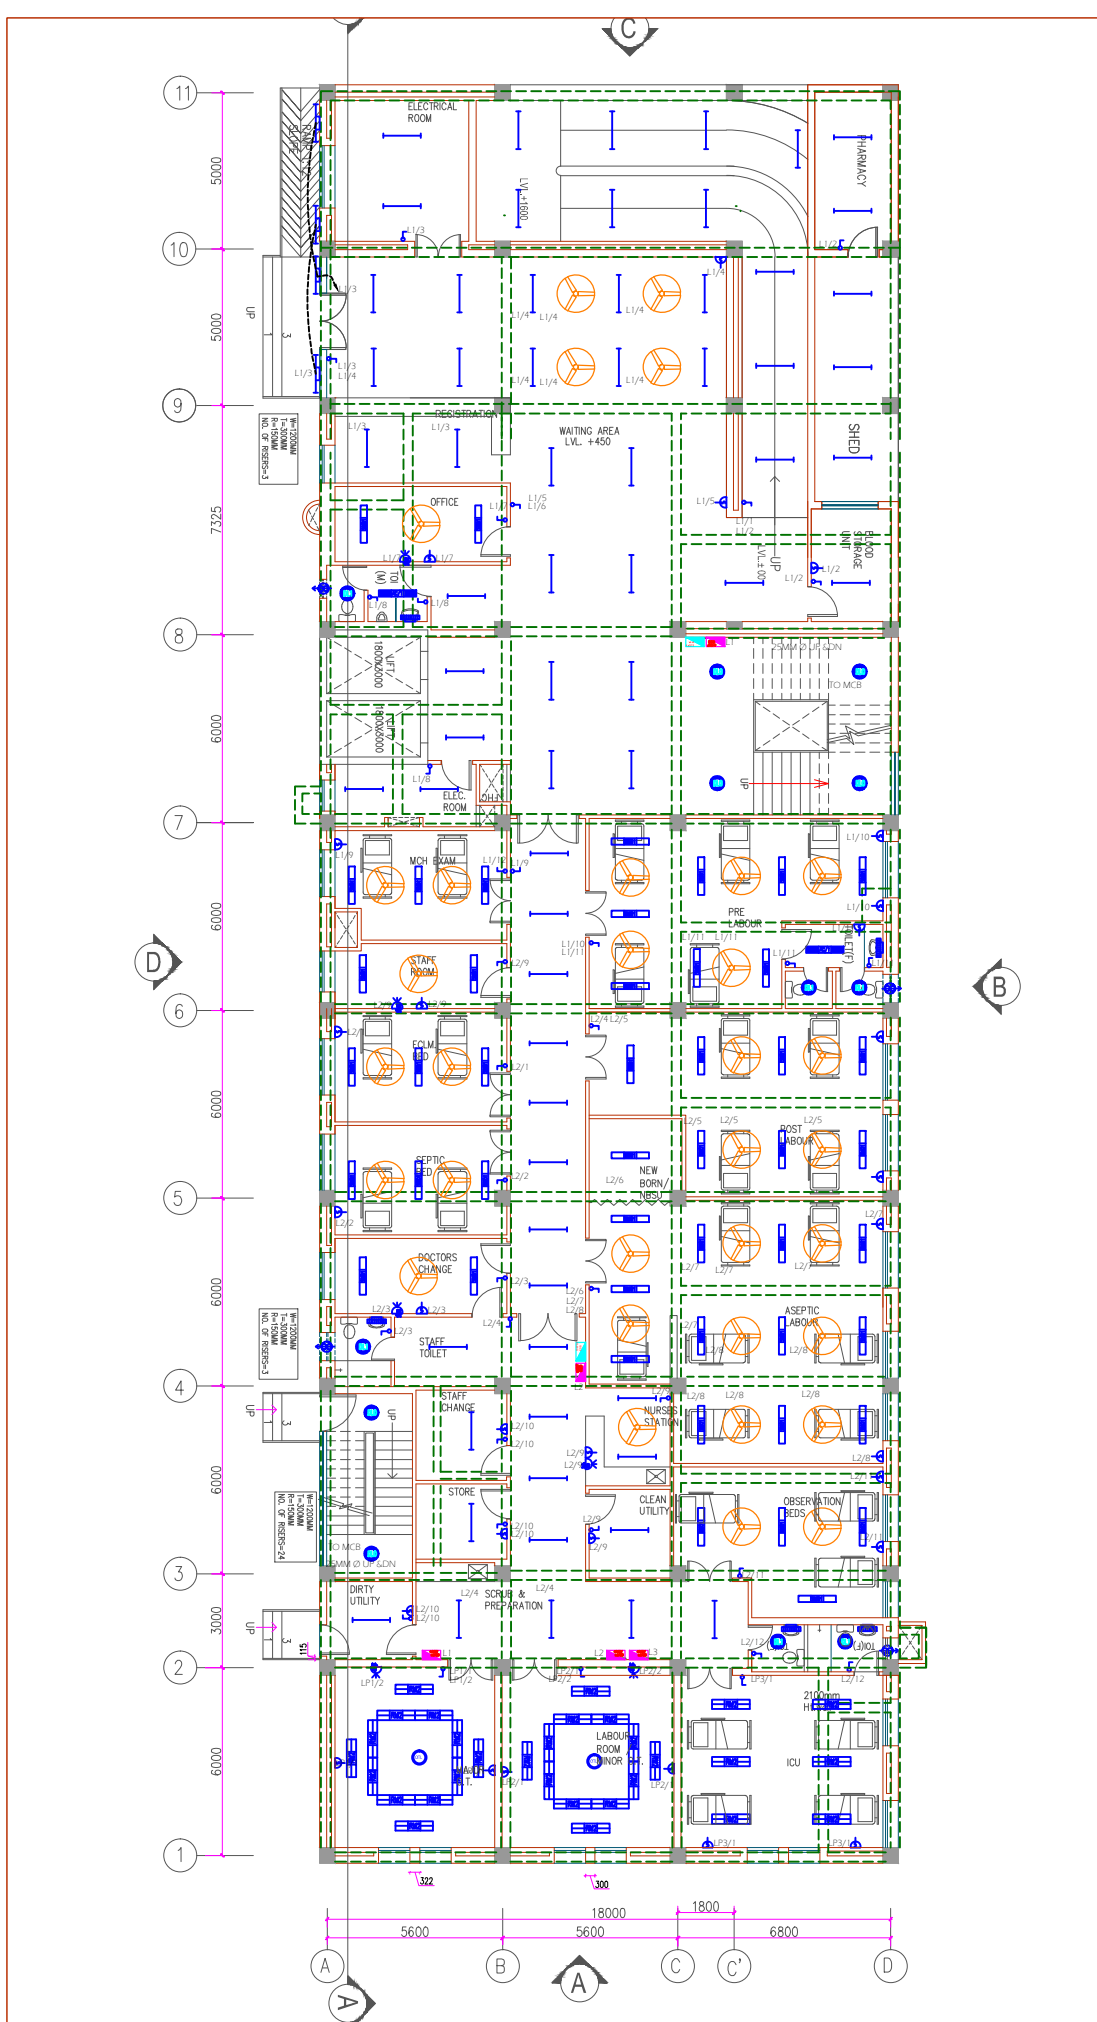

This drawing with all its contents is the sole intellectual property of the Hospital Services Consultancy Corporation (India) Ltd. Copying of this drawing or part thereof or its use in any form whatsoever without the written permission of HSCC is prohibited.

NOTES

S.No.	SYMBOL	DESCRIPTION
1	[Symbol]	100 MM CEILING FAN
2	[Symbol]	1000 MM CEILING FAN
3	[Symbol]	1000 MM DOWN LIGHT
4	[Symbol]	1000 MM DOWN LIGHT
5	[Symbol]	1000 MM DOWN LIGHT
6	[Symbol]	1000 MM DOWN LIGHT
7	[Symbol]	1000 MM DOWN LIGHT
8	[Symbol]	1000 MM DOWN LIGHT
9	[Symbol]	1000 MM DOWN LIGHT
10	[Symbol]	1000 MM DOWN LIGHT
11	[Symbol]	1000 MM DOWN LIGHT
12	[Symbol]	1000 MM DOWN LIGHT
13	[Symbol]	1000 MM DOWN LIGHT
14	[Symbol]	1000 MM DOWN LIGHT
15	[Symbol]	1000 MM DOWN LIGHT
16	[Symbol]	1000 MM DOWN LIGHT
17	[Symbol]	1000 MM DOWN LIGHT
18	[Symbol]	1000 MM DOWN LIGHT
19	[Symbol]	1000 MM DOWN LIGHT
20	[Symbol]	1000 MM DOWN LIGHT
21	[Symbol]	1000 MM DOWN LIGHT
22	[Symbol]	1000 MM DOWN LIGHT
23	[Symbol]	1000 MM DOWN LIGHT
24	[Symbol]	1000 MM DOWN LIGHT
25	[Symbol]	1000 MM DOWN LIGHT
26	[Symbol]	1000 MM DOWN LIGHT
27	[Symbol]	1000 MM DOWN LIGHT
28	[Symbol]	1000 MM DOWN LIGHT
29	[Symbol]	1000 MM DOWN LIGHT
30	[Symbol]	1000 MM DOWN LIGHT
31	[Symbol]	1000 MM DOWN LIGHT
32	[Symbol]	1000 MM DOWN LIGHT
33	[Symbol]	1000 MM DOWN LIGHT
34	[Symbol]	1000 MM DOWN LIGHT
35	[Symbol]	1000 MM DOWN LIGHT
36	[Symbol]	1000 MM DOWN LIGHT
37	[Symbol]	1000 MM DOWN LIGHT
38	[Symbol]	1000 MM DOWN LIGHT
39	[Symbol]	1000 MM DOWN LIGHT
40	[Symbol]	1000 MM DOWN LIGHT


REV	DATE	DESCRIPTION
REVISION		


PROJECT
 NRHM PROJECT
 Proposed 50 Bedded Hospital at **JASHPUR, CHATTISGARH**

TITLE
 TENDER DRAWING
 GROUND FLOOR PLAN ELECTRICAL POWER & SUBMAIN CONDUIT LAYOUT

HSCC/EV210/EL/HOSP/002B		Rev.
Drawing No.		
HSCC/-	1:125	Date
Job No.	Scale	
Drawn by :	Rev. by	Prep. by

HSCC (INDIA) LIMITED
 (A GOVERNMENT OF INDIA ENTERPRISES)
HSCC
 NEW DELHI INDIA

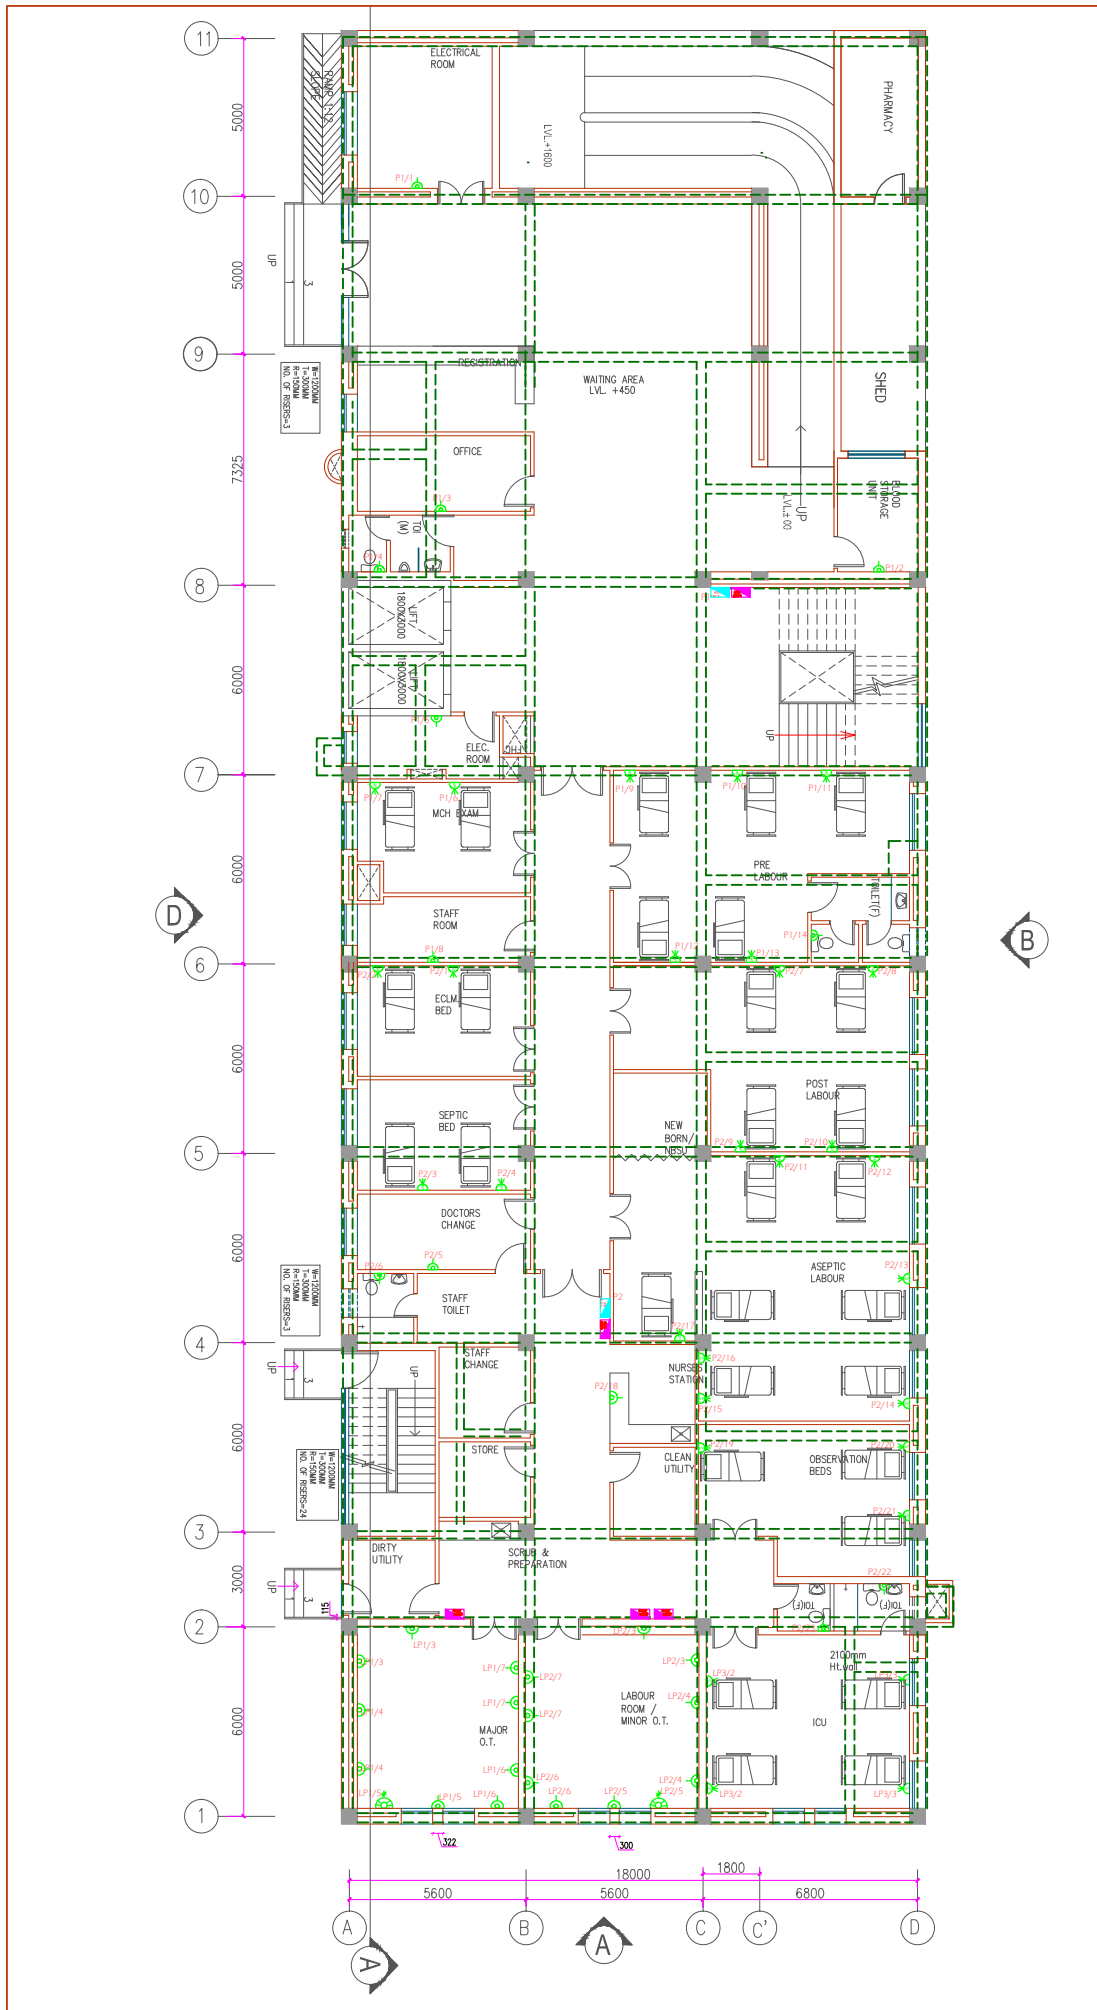

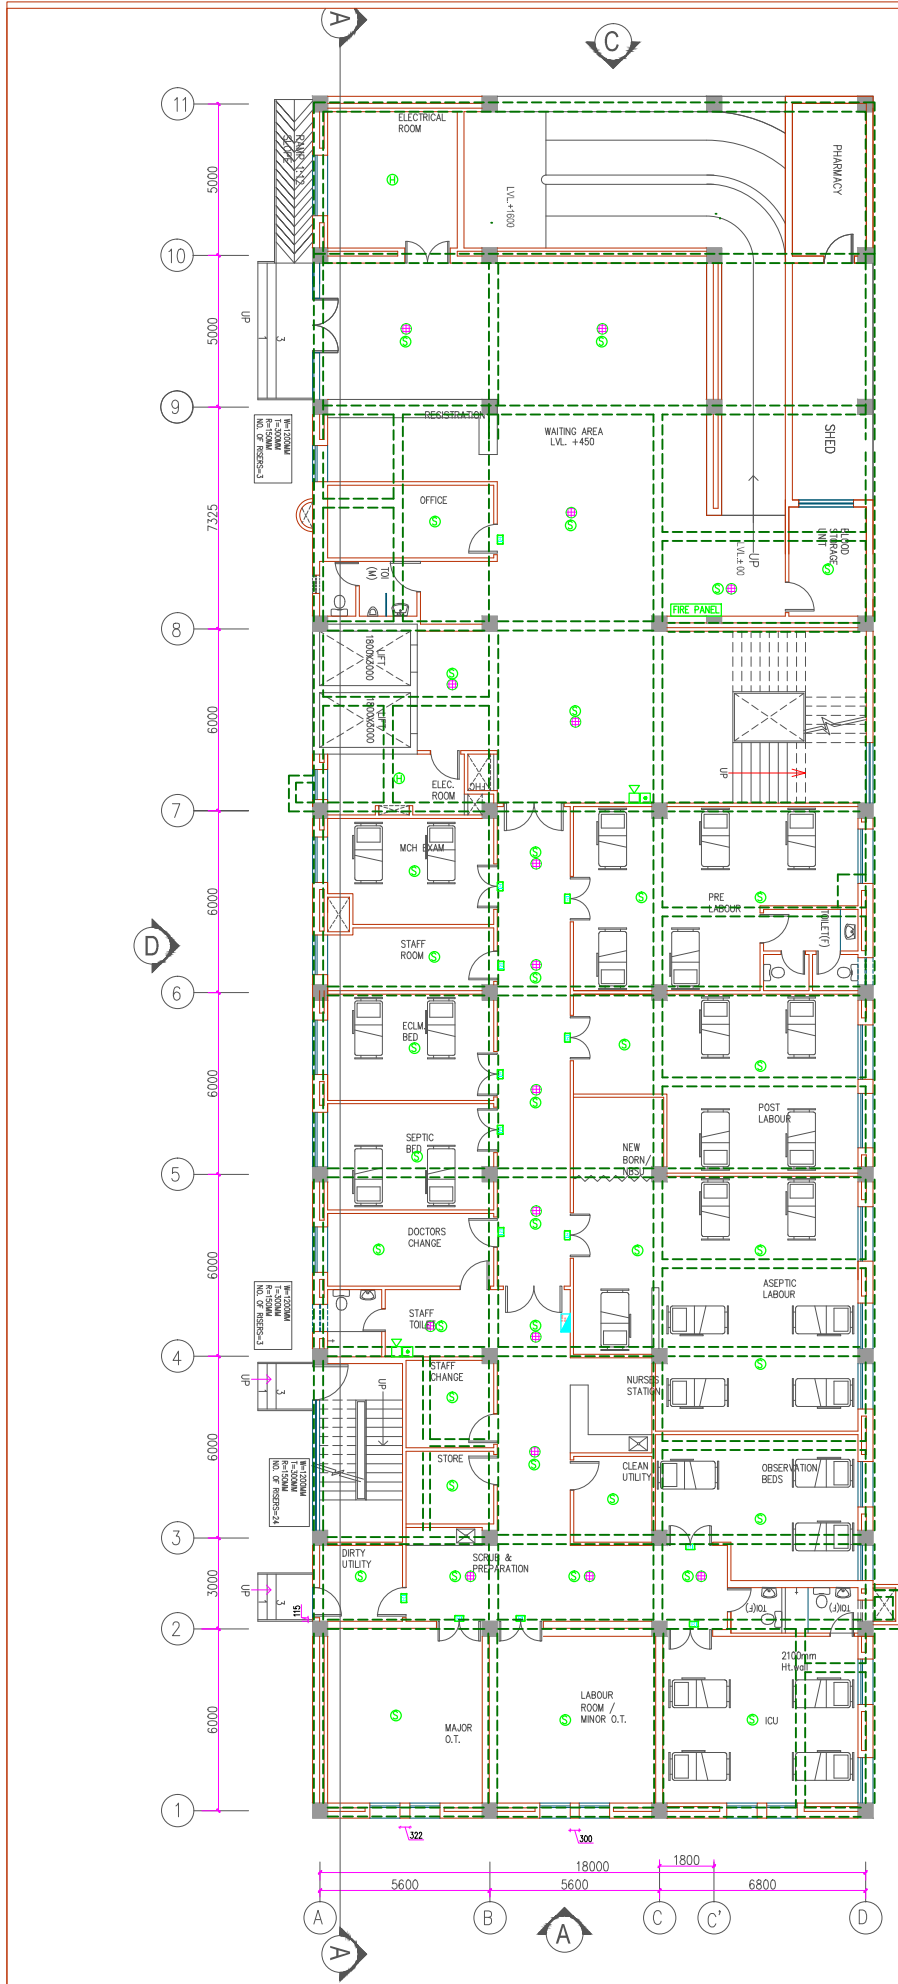

GROUND FLOOR

This drawing with all its contents is the sole intellectual property of the Hospital Services Consultancy Corporation (India) Ltd. Copying of this drawing or part thereof or its use in any form whatsoever without the written permission of HSCC is prohibited.

NOTES

S.No.	SYMBOL	DESCRIPTION
1	[Symbol]	100 MM CEILING FAN
2	[Symbol]	1000 MM CEILING FAN
3	[Symbol]	100W WATT 230V TYPE FLUORESCENT LIGHT FIXTURE (W/TYPE 100, 1000, 200 & 400)
4	[Symbol]	150W WATT 230V TYPE FLUORESCENT LIGHT FIXTURE (W/TYPE 150, 1500, 300 & 600)
5	[Symbol]	200W WATT 230V TYPE FLUORESCENT LIGHT FIXTURE (W/TYPE 200, 2000, 400 & 800)
6	[Symbol]	300W WATT 230V TYPE FLUORESCENT LIGHT FIXTURE (W/TYPE 300, 3000, 600 & 1200)
7	[Symbol]	400W WATT 230V TYPE FLUORESCENT LIGHT FIXTURE (W/TYPE 400, 4000, 800 & 1600)
8	[Symbol]	500W WATT 230V TYPE FLUORESCENT LIGHT FIXTURE (W/TYPE 500, 5000, 1000 & 2000)
9	[Symbol]	600W WATT 230V TYPE FLUORESCENT LIGHT FIXTURE (W/TYPE 600, 6000, 1200 & 2400)
10	[Symbol]	75W WATT 230V TYPE FLUORESCENT LIGHT FIXTURE (W/TYPE 75, 750, 150 & 300)
11	[Symbol]	150W WATT 230V TYPE FLUORESCENT LIGHT FIXTURE (W/TYPE 150, 1500, 300 & 600)
12	[Symbol]	300W WATT 230V TYPE FLUORESCENT LIGHT FIXTURE (W/TYPE 300, 3000, 600 & 1200)
13	[Symbol]	100 WATT 230V TYPE FLUORESCENT LIGHT FIXTURE (W/TYPE 100, 1000, 200 & 400)
14	[Symbol]	150 WATT 230V TYPE FLUORESCENT LIGHT FIXTURE (W/TYPE 150, 1500, 300 & 600)
15	[Symbol]	200 WATT 230V TYPE FLUORESCENT LIGHT FIXTURE (W/TYPE 200, 2000, 400 & 800)
16	[Symbol]	300 WATT 230V TYPE FLUORESCENT LIGHT FIXTURE (W/TYPE 300, 3000, 600 & 1200)
17	[Symbol]	100 POWER POINT
18	[Symbol]	20 POWER POINT
19	[Symbol]	100 POWER POINT
20	[Symbol]	WASH BELL BELL POWER SWITCH
21	[Symbol]	SWITCH BOARD
22	[Symbol]	SWITCH BOARD WITH (SWITCH-100V & 15 A)
23	[Symbol]	ST LIGHT
24	[Symbol]	CABLE TV OUTLET
25	[Symbol]	100 POWER POINT
26	[Symbol]	20 POWER POINT
27	[Symbol]	100 POWER POINT
28	[Symbol]	WASH BELL BELL POWER SWITCH
29	[Symbol]	SWITCH BOARD
30	[Symbol]	SWITCH BOARD WITH (SWITCH-100V & 15 A)
31	[Symbol]	ST LIGHT
32	[Symbol]	CABLE TV OUTLET
33	[Symbol]	100 POWER POINT
34	[Symbol]	20 POWER POINT
35	[Symbol]	100 POWER POINT
36	[Symbol]	WASH BELL BELL POWER SWITCH
37	[Symbol]	SWITCH BOARD
38	[Symbol]	SWITCH BOARD WITH (SWITCH-100V & 15 A)
39	[Symbol]	ST LIGHT
40	[Symbol]	CABLE TV OUTLET

REV	DATE	DESCRIPTION
REVISION		


PROJECT
 NRHM PROJECT
 Proposed 50 Bedded Hospital at **JASHPUR, CHATTISGARH**

TITLE
TENDER DRAWING
 GROUND FLOOR PLAN ELECTRICAL FIRE ALARM CONDUIT LAYOUT

HSCC/EV210/EL/HOSP/002C		Rev.
Drawing No.		
HSCC/- Job No.	1:125 Scale	Date
Drawn by :	Rev. by	Prep. by

HSCC (INDIA) LIMITED
 (A GOVERNMENT OF INDIA ENTERPRISES)
HSCC
 NEW DELHI INDIA

FIRST FLOOR

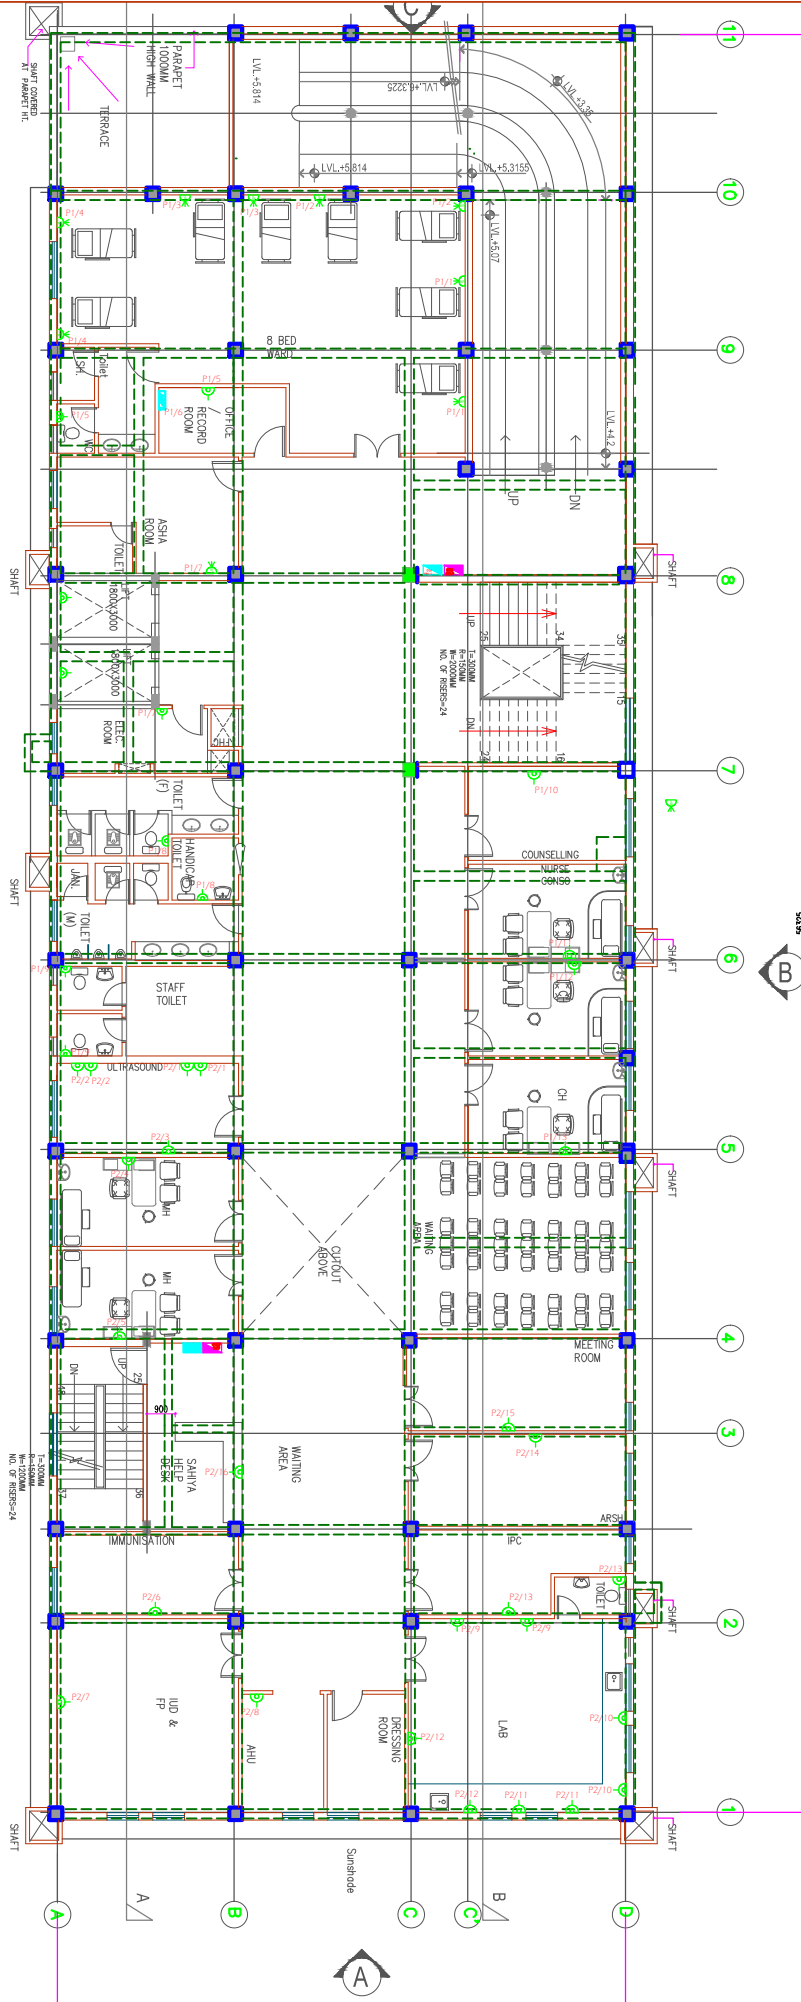

This drawing with all its contents is the sole intellectual property of the Hospital Services Consultancy Corporation (India) Ltd. Copying of this drawing or part thereof or its use in any form whatsoever without the written permission of HSCC is prohibited.

NOTES

S.No.	SYMBOL	DESCRIPTION
1	(Symbol)	100 MM CEILING PIPE
2	(Symbol)	100 MM CEILING PIPE
3	(Symbol)	100 MM WPT 80% FPOSSIBLE LIGHT FAN
4	(Symbol)	100 MM WPT 80% FPOSSIBLE LIGHT FAN
5	(Symbol)	100 MM WPT 80% FPOSSIBLE LIGHT FAN
6	(Symbol)	100 MM WPT 80% FPOSSIBLE LIGHT FAN
7	(Symbol)	100 MM WPT 80% FPOSSIBLE LIGHT FAN
8	(Symbol)	100 MM WPT 80% FPOSSIBLE LIGHT FAN
9	(Symbol)	100 MM WPT 80% FPOSSIBLE LIGHT FAN
10	(Symbol)	100 MM WPT 80% FPOSSIBLE LIGHT FAN
11	(Symbol)	100 MM WPT 80% FPOSSIBLE LIGHT FAN
12	(Symbol)	100 MM WPT 80% FPOSSIBLE LIGHT FAN
13	(Symbol)	100 MM WPT 80% FPOSSIBLE LIGHT FAN
14	(Symbol)	100 MM WPT 80% FPOSSIBLE LIGHT FAN
15	(Symbol)	100 MM WPT 80% FPOSSIBLE LIGHT FAN
16	(Symbol)	100 MM WPT 80% FPOSSIBLE LIGHT FAN
17	(Symbol)	100 MM WPT 80% FPOSSIBLE LIGHT FAN
18	(Symbol)	100 MM WPT 80% FPOSSIBLE LIGHT FAN
19	(Symbol)	100 MM WPT 80% FPOSSIBLE LIGHT FAN
20	(Symbol)	100 MM WPT 80% FPOSSIBLE LIGHT FAN
21	(Symbol)	100 MM WPT 80% FPOSSIBLE LIGHT FAN
22	(Symbol)	100 MM WPT 80% FPOSSIBLE LIGHT FAN
23	(Symbol)	100 MM WPT 80% FPOSSIBLE LIGHT FAN
24	(Symbol)	100 MM WPT 80% FPOSSIBLE LIGHT FAN
25	(Symbol)	100 MM WPT 80% FPOSSIBLE LIGHT FAN
26	(Symbol)	100 MM WPT 80% FPOSSIBLE LIGHT FAN
27	(Symbol)	100 MM WPT 80% FPOSSIBLE LIGHT FAN
28	(Symbol)	100 MM WPT 80% FPOSSIBLE LIGHT FAN
29	(Symbol)	100 MM WPT 80% FPOSSIBLE LIGHT FAN
30	(Symbol)	100 MM WPT 80% FPOSSIBLE LIGHT FAN
31	(Symbol)	100 MM WPT 80% FPOSSIBLE LIGHT FAN
32	(Symbol)	100 MM WPT 80% FPOSSIBLE LIGHT FAN
33	(Symbol)	100 MM WPT 80% FPOSSIBLE LIGHT FAN
34	(Symbol)	100 MM WPT 80% FPOSSIBLE LIGHT FAN
35	(Symbol)	100 MM WPT 80% FPOSSIBLE LIGHT FAN
36	(Symbol)	100 MM WPT 80% FPOSSIBLE LIGHT FAN
37	(Symbol)	100 MM WPT 80% FPOSSIBLE LIGHT FAN
38	(Symbol)	100 MM WPT 80% FPOSSIBLE LIGHT FAN
39	(Symbol)	100 MM WPT 80% FPOSSIBLE LIGHT FAN
40	(Symbol)	100 MM WPT 80% FPOSSIBLE LIGHT FAN
41	(Symbol)	100 MM WPT 80% FPOSSIBLE LIGHT FAN
42	(Symbol)	100 MM WPT 80% FPOSSIBLE LIGHT FAN
43	(Symbol)	100 MM WPT 80% FPOSSIBLE LIGHT FAN
44	(Symbol)	100 MM WPT 80% FPOSSIBLE LIGHT FAN
45	(Symbol)	100 MM WPT 80% FPOSSIBLE LIGHT FAN
46	(Symbol)	100 MM WPT 80% FPOSSIBLE LIGHT FAN
47	(Symbol)	100 MM WPT 80% FPOSSIBLE LIGHT FAN
48	(Symbol)	100 MM WPT 80% FPOSSIBLE LIGHT FAN
49	(Symbol)	100 MM WPT 80% FPOSSIBLE LIGHT FAN
50	(Symbol)	100 MM WPT 80% FPOSSIBLE LIGHT FAN

REV	DATE	DESCRIPTION
REVISION		

PROJECT
 NRHM PROJECT
 Proposed 50 Bedded Hospital at JASHPUR, CHATTISGARH

TITLE
 ELECTRICAL SHOP DRAWING
 FIRST FLOOR PLAN ELECTRICAL POWER & SUBMAIN CONDUIT LAYOUT

HSCC/EV210/EL/HOSP/002B Drawing No.		Rev.
HSCC/- Job No.	1:125 Scale	Date
Drawn by :	Rev. by	Prep. by

HSCC (INDIA) LIMITED
 (A GOVERNMENT OF INDIA ENTERPRISES)
HSCC
 NEW DELHI INDIA