

This drawing with all its contents is the sole intellectual property of the Hospital Services Consultancy Corporation (India) Ltd. Copying of this drawing or part thereof, its use in any form whatsoever without the written permission of HSCC is prohibited.

**NOTES**

**LEGEND:**

S.No.	SYMBOL	DESCRIPTION
1	(Symbol)	100 MM CEILING FAN
2	(Symbol)	1000 MM CEILING FAN
3	(Symbol)	1000 MM SPTC FLUORESCENT LIGHT FIXTURE (POWER FAN USE THIS SIZE OR 600)
4	(Symbol)	1000 MM SPTC FLUORESCENT LIGHT FIXTURE (PRINTING USE THIS SIZE OR 600)
5	(Symbol)	1000 MM SPTC FLUORESCENT LIGHT FIXTURE (PRINTING USE THIS SIZE OR 600)
6	(Symbol)	1000 MM SPTC FLUORESCENT LIGHT FIXTURE (PRINTING USE THIS SIZE OR 600)
7	(Symbol)	1000 MM SPTC FLUORESCENT LIGHT FIXTURE (PRINTING USE THIS SIZE OR 600)
8	(Symbol)	1000 MM SPTC FLUORESCENT LIGHT FIXTURE (PRINTING USE THIS SIZE OR 600)
9	(Symbol)	1000 MM SPTC FLUORESCENT LIGHT FIXTURE (PRINTING USE THIS SIZE OR 600)
10	(Symbol)	1000 MM SPTC FLUORESCENT LIGHT FIXTURE (PRINTING USE THIS SIZE OR 600)
11	(Symbol)	1000 MM SPTC FLUORESCENT LIGHT FIXTURE (PRINTING USE THIS SIZE OR 600)
12	(Symbol)	1000 MM SPTC FLUORESCENT LIGHT FIXTURE (PRINTING USE THIS SIZE OR 600)
13	(Symbol)	1000 MM SPTC FLUORESCENT LIGHT FIXTURE (PRINTING USE THIS SIZE OR 600)
14	(Symbol)	1000 MM SPTC FLUORESCENT LIGHT FIXTURE (PRINTING USE THIS SIZE OR 600)
15	(Symbol)	1000 MM SPTC FLUORESCENT LIGHT FIXTURE (PRINTING USE THIS SIZE OR 600)
16	(Symbol)	1000 MM SPTC FLUORESCENT LIGHT FIXTURE (PRINTING USE THIS SIZE OR 600)
17	(Symbol)	1000 MM SPTC FLUORESCENT LIGHT FIXTURE (PRINTING USE THIS SIZE OR 600)
18	(Symbol)	1000 MM SPTC FLUORESCENT LIGHT FIXTURE (PRINTING USE THIS SIZE OR 600)
19	(Symbol)	1000 MM SPTC FLUORESCENT LIGHT FIXTURE (PRINTING USE THIS SIZE OR 600)
20	(Symbol)	1000 MM SPTC FLUORESCENT LIGHT FIXTURE (PRINTING USE THIS SIZE OR 600)
21	(Symbol)	1000 MM SPTC FLUORESCENT LIGHT FIXTURE (PRINTING USE THIS SIZE OR 600)
22	(Symbol)	1000 MM SPTC FLUORESCENT LIGHT FIXTURE (PRINTING USE THIS SIZE OR 600)
23	(Symbol)	1000 MM SPTC FLUORESCENT LIGHT FIXTURE (PRINTING USE THIS SIZE OR 600)
24	(Symbol)	1000 MM SPTC FLUORESCENT LIGHT FIXTURE (PRINTING USE THIS SIZE OR 600)
25	(Symbol)	1000 MM SPTC FLUORESCENT LIGHT FIXTURE (PRINTING USE THIS SIZE OR 600)
26	(Symbol)	1000 MM SPTC FLUORESCENT LIGHT FIXTURE (PRINTING USE THIS SIZE OR 600)
27	(Symbol)	1000 MM SPTC FLUORESCENT LIGHT FIXTURE (PRINTING USE THIS SIZE OR 600)
28	(Symbol)	1000 MM SPTC FLUORESCENT LIGHT FIXTURE (PRINTING USE THIS SIZE OR 600)
29	(Symbol)	1000 MM SPTC FLUORESCENT LIGHT FIXTURE (PRINTING USE THIS SIZE OR 600)
30	(Symbol)	1000 MM SPTC FLUORESCENT LIGHT FIXTURE (PRINTING USE THIS SIZE OR 600)
31	(Symbol)	1000 MM SPTC FLUORESCENT LIGHT FIXTURE (PRINTING USE THIS SIZE OR 600)
32	(Symbol)	1000 MM SPTC FLUORESCENT LIGHT FIXTURE (PRINTING USE THIS SIZE OR 600)
33	(Symbol)	1000 MM SPTC FLUORESCENT LIGHT FIXTURE (PRINTING USE THIS SIZE OR 600)
34	(Symbol)	1000 MM SPTC FLUORESCENT LIGHT FIXTURE (PRINTING USE THIS SIZE OR 600)
35	(Symbol)	1000 MM SPTC FLUORESCENT LIGHT FIXTURE (PRINTING USE THIS SIZE OR 600)
36	(Symbol)	1000 MM SPTC FLUORESCENT LIGHT FIXTURE (PRINTING USE THIS SIZE OR 600)
37	(Symbol)	1000 MM SPTC FLUORESCENT LIGHT FIXTURE (PRINTING USE THIS SIZE OR 600)
38	(Symbol)	1000 MM SPTC FLUORESCENT LIGHT FIXTURE (PRINTING USE THIS SIZE OR 600)
39	(Symbol)	1000 MM SPTC FLUORESCENT LIGHT FIXTURE (PRINTING USE THIS SIZE OR 600)
40	(Symbol)	1000 MM SPTC FLUORESCENT LIGHT FIXTURE (PRINTING USE THIS SIZE OR 600)
41	(Symbol)	1000 MM SPTC FLUORESCENT LIGHT FIXTURE (PRINTING USE THIS SIZE OR 600)
42	(Symbol)	1000 MM SPTC FLUORESCENT LIGHT FIXTURE (PRINTING USE THIS SIZE OR 600)
43	(Symbol)	1000 MM SPTC FLUORESCENT LIGHT FIXTURE (PRINTING USE THIS SIZE OR 600)
44	(Symbol)	1000 MM SPTC FLUORESCENT LIGHT FIXTURE (PRINTING USE THIS SIZE OR 600)
45	(Symbol)	1000 MM SPTC FLUORESCENT LIGHT FIXTURE (PRINTING USE THIS SIZE OR 600)
46	(Symbol)	1000 MM SPTC FLUORESCENT LIGHT FIXTURE (PRINTING USE THIS SIZE OR 600)
47	(Symbol)	1000 MM SPTC FLUORESCENT LIGHT FIXTURE (PRINTING USE THIS SIZE OR 600)
48	(Symbol)	1000 MM SPTC FLUORESCENT LIGHT FIXTURE (PRINTING USE THIS SIZE OR 600)
49	(Symbol)	1000 MM SPTC FLUORESCENT LIGHT FIXTURE (PRINTING USE THIS SIZE OR 600)
50	(Symbol)	1000 MM SPTC FLUORESCENT LIGHT FIXTURE (PRINTING USE THIS SIZE OR 600)

REV	DATE	DESCRIPTION
REVISION		


**PROJECT**  
 NRHM PROJECT  
 Proposed 50 Bedded Hospital at JASHPUR, CHATTISGARH

**TITLE**  
 TENDER DRAWING  
 SECOND FLOOR PLAN ELECTRICAL LIGHTING & CONDUIT LAYOUT

HSCC/EV210/EL/HOSP/002A		Rev.
Drawing No.		
HSCC/-	1:125	Date
Job No.	Scale	
Drawn by :	Rev. by	Prep. by

HSCC (INDIA) LIMITED  
 (A GOVERNMENT OF INDIA ENTERPRISES)  
**HSCC**  
 NEW DELHI INDIA

P1/4

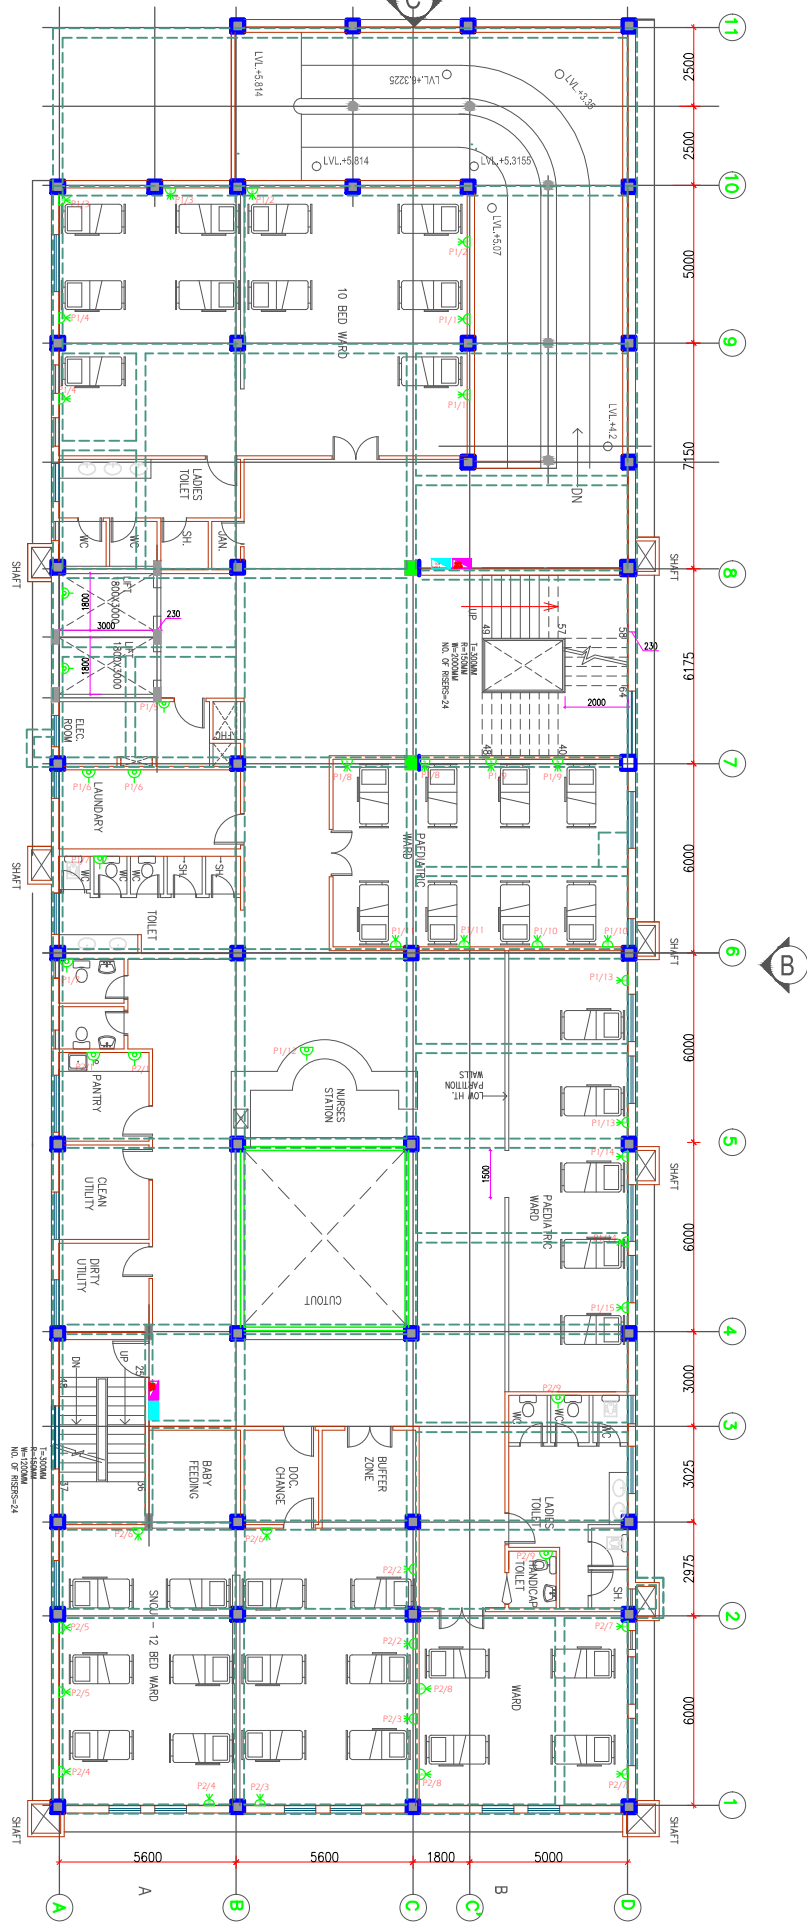

This drawing with all its contents is the sole intellectual property of the Hospital Services Consultancy Corporation (India) Ltd. Copying of this drawing or part thereof, or its use in any form whatsoever without the written permission of HSCC is prohibited.

NOTES		
LEGEND:	S.No.	DESCRIPTION
	1	400 MM CEILING FAN
	2	1000 MM CEILING FAN
	3	1000 MM TFC FLUORESCENT LIGHT FIXTURE (W/ 28W, 1800 MM X 600 MM)
	4	1500 MM TFC FLUORESCENT LIGHT FIXTURE (W/ 36W, 1800 MM X 900 MM)
	5	1500 MM TFC FLUORESCENT LIGHT FIXTURE (W/ 36W, 1800 MM X 900 MM)
	6	1500 MM TFC FLUORESCENT LIGHT FIXTURE (W/ 36W, 1800 MM X 900 MM)
	7	1500 MM TFC FLUORESCENT LIGHT FIXTURE (W/ 36W, 1800 MM X 900 MM)
	8	1500 MM TFC FLUORESCENT LIGHT FIXTURE (W/ 36W, 1800 MM X 900 MM)
	9	1500 MM TFC FLUORESCENT LIGHT FIXTURE (W/ 36W, 1800 MM X 900 MM)
	10	1500 MM TFC FLUORESCENT LIGHT FIXTURE (W/ 36W, 1800 MM X 900 MM)
	11	1500 MM TFC FLUORESCENT LIGHT FIXTURE (W/ 36W, 1800 MM X 900 MM)
	12	1500 MM TFC FLUORESCENT LIGHT FIXTURE (W/ 36W, 1800 MM X 900 MM)
	13	1500 MM TFC FLUORESCENT LIGHT FIXTURE (W/ 36W, 1800 MM X 900 MM)
	14	1500 MM TFC FLUORESCENT LIGHT FIXTURE (W/ 36W, 1800 MM X 900 MM)
	15	1500 MM TFC FLUORESCENT LIGHT FIXTURE (W/ 36W, 1800 MM X 900 MM)
	16	1500 MM TFC FLUORESCENT LIGHT FIXTURE (W/ 36W, 1800 MM X 900 MM)
	17	1500 MM TFC FLUORESCENT LIGHT FIXTURE (W/ 36W, 1800 MM X 900 MM)
	18	1500 MM TFC FLUORESCENT LIGHT FIXTURE (W/ 36W, 1800 MM X 900 MM)
	19	1500 MM TFC FLUORESCENT LIGHT FIXTURE (W/ 36W, 1800 MM X 900 MM)
	20	1500 MM TFC FLUORESCENT LIGHT FIXTURE (W/ 36W, 1800 MM X 900 MM)
	21	1500 MM TFC FLUORESCENT LIGHT FIXTURE (W/ 36W, 1800 MM X 900 MM)
	22	1500 MM TFC FLUORESCENT LIGHT FIXTURE (W/ 36W, 1800 MM X 900 MM)
	23	1500 MM TFC FLUORESCENT LIGHT FIXTURE (W/ 36W, 1800 MM X 900 MM)
	24	1500 MM TFC FLUORESCENT LIGHT FIXTURE (W/ 36W, 1800 MM X 900 MM)
	25	1500 MM TFC FLUORESCENT LIGHT FIXTURE (W/ 36W, 1800 MM X 900 MM)
	26	1500 MM TFC FLUORESCENT LIGHT FIXTURE (W/ 36W, 1800 MM X 900 MM)
	27	1500 MM TFC FLUORESCENT LIGHT FIXTURE (W/ 36W, 1800 MM X 900 MM)
	28	1500 MM TFC FLUORESCENT LIGHT FIXTURE (W/ 36W, 1800 MM X 900 MM)
	29	1500 MM TFC FLUORESCENT LIGHT FIXTURE (W/ 36W, 1800 MM X 900 MM)
	30	1500 MM TFC FLUORESCENT LIGHT FIXTURE (W/ 36W, 1800 MM X 900 MM)
	31	1500 MM TFC FLUORESCENT LIGHT FIXTURE (W/ 36W, 1800 MM X 900 MM)
	32	1500 MM TFC FLUORESCENT LIGHT FIXTURE (W/ 36W, 1800 MM X 900 MM)
	33	1500 MM TFC FLUORESCENT LIGHT FIXTURE (W/ 36W, 1800 MM X 900 MM)
	34	1500 MM TFC FLUORESCENT LIGHT FIXTURE (W/ 36W, 1800 MM X 900 MM)
	35	1500 MM TFC FLUORESCENT LIGHT FIXTURE (W/ 36W, 1800 MM X 900 MM)
	36	1500 MM TFC FLUORESCENT LIGHT FIXTURE (W/ 36W, 1800 MM X 900 MM)
	37	1500 MM TFC FLUORESCENT LIGHT FIXTURE (W/ 36W, 1800 MM X 900 MM)
	38	1500 MM TFC FLUORESCENT LIGHT FIXTURE (W/ 36W, 1800 MM X 900 MM)
	39	1500 MM TFC FLUORESCENT LIGHT FIXTURE (W/ 36W, 1800 MM X 900 MM)
	40	1500 MM TFC FLUORESCENT LIGHT FIXTURE (W/ 36W, 1800 MM X 900 MM)

REV	DATE	DESCRIPTION
REVISION		


**PROJECT**  
 NRHM PROJECT  
 Proposed 50 Bedded Hospital at **JASHPUR, CHATTISGARH**

**TITLE**  
 TENDER DRAWING  
 SECOND FLOOR PLAN ELECTRICAL POWER & SUBMAIN CONDUIT LAYOUT

HSCC/EV210/EL/HOSP/002B  
 Drawing No. \_\_\_\_\_ Rev. \_\_\_\_\_

HSCC/- Job No.	1:125 Scale	Date
Drawn by :	Rev. by	Prep. by

HSCC (INDIA) LIMITED  
 (A GOVERNMENT OF INDIA ENTERPRISES)  
**HSCC**  
 NEW DELHI INDIA

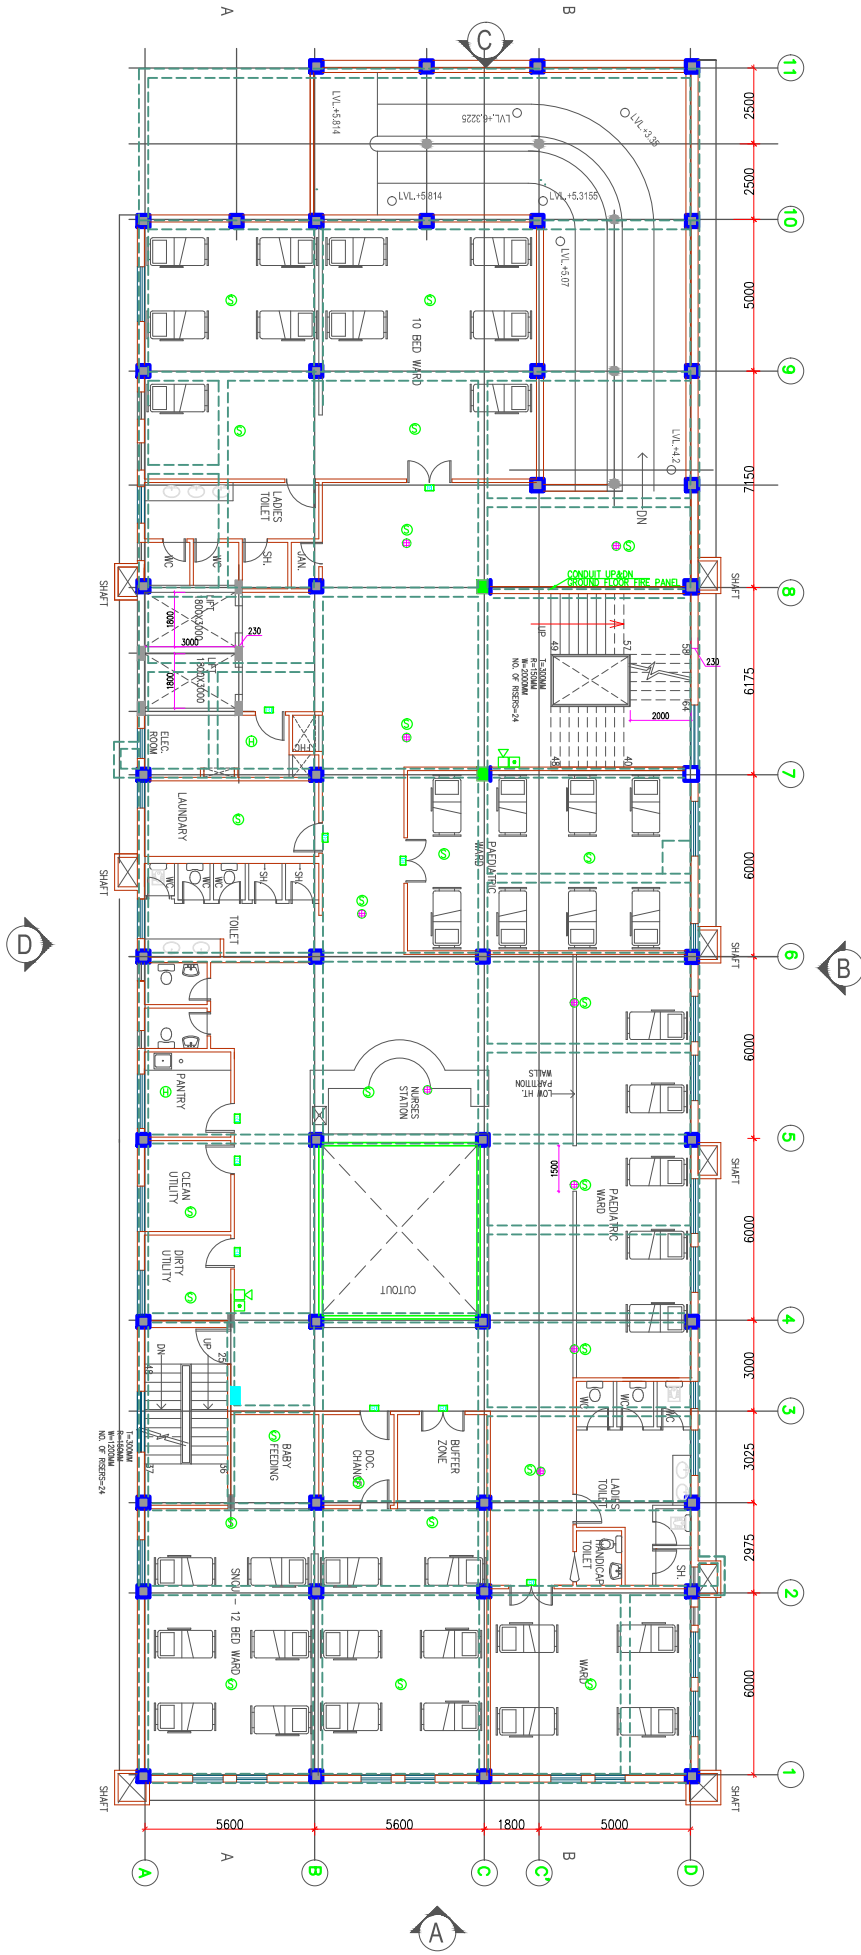

This drawing with all its contents is the sole intellectual property of the Hospital Services Consultancy Corporation (India) Ltd. Copying of this drawing or part thereof or its use in any form whatsoever without the written permission of HSCC is prohibited.

NOTES

LEGEND:

S.No.	SYMBOL	DESCRIPTION
1	[Symbol]	800 MM CEILING DUCT
2	[Symbol]	1000 MM CEILING DUCT
3	[Symbol]	1000 MM CEILING DUCT
4	[Symbol]	1000 MM CEILING DUCT
5	[Symbol]	1000 MM CEILING DUCT
6	[Symbol]	1000 MM CEILING DUCT
7	[Symbol]	1000 MM CEILING DUCT
8	[Symbol]	1000 MM CEILING DUCT
9	[Symbol]	1000 MM CEILING DUCT
10	[Symbol]	1000 MM CEILING DUCT
11	[Symbol]	1000 MM CEILING DUCT
12	[Symbol]	1000 MM CEILING DUCT
13	[Symbol]	1000 MM CEILING DUCT
14	[Symbol]	1000 MM CEILING DUCT
15	[Symbol]	1000 MM CEILING DUCT
16	[Symbol]	1000 MM CEILING DUCT
17	[Symbol]	1000 MM CEILING DUCT
18	[Symbol]	1000 MM CEILING DUCT
19	[Symbol]	1000 MM CEILING DUCT
20	[Symbol]	1000 MM CEILING DUCT
21	[Symbol]	1000 MM CEILING DUCT
22	[Symbol]	1000 MM CEILING DUCT
23	[Symbol]	1000 MM CEILING DUCT
24	[Symbol]	1000 MM CEILING DUCT
25	[Symbol]	1000 MM CEILING DUCT
26	[Symbol]	1000 MM CEILING DUCT
27	[Symbol]	1000 MM CEILING DUCT
28	[Symbol]	1000 MM CEILING DUCT
29	[Symbol]	1000 MM CEILING DUCT
30	[Symbol]	1000 MM CEILING DUCT
31	[Symbol]	1000 MM CEILING DUCT
32	[Symbol]	1000 MM CEILING DUCT
33	[Symbol]	1000 MM CEILING DUCT
34	[Symbol]	1000 MM CEILING DUCT
35	[Symbol]	1000 MM CEILING DUCT
36	[Symbol]	1000 MM CEILING DUCT
37	[Symbol]	1000 MM CEILING DUCT
38	[Symbol]	1000 MM CEILING DUCT
39	[Symbol]	1000 MM CEILING DUCT
40	[Symbol]	1000 MM CEILING DUCT
41	[Symbol]	1000 MM CEILING DUCT
42	[Symbol]	1000 MM CEILING DUCT
43	[Symbol]	1000 MM CEILING DUCT
44	[Symbol]	1000 MM CEILING DUCT
45	[Symbol]	1000 MM CEILING DUCT
46	[Symbol]	1000 MM CEILING DUCT
47	[Symbol]	1000 MM CEILING DUCT
48	[Symbol]	1000 MM CEILING DUCT
49	[Symbol]	1000 MM CEILING DUCT
50	[Symbol]	1000 MM CEILING DUCT

REV	DATE	DESCRIPTION
REVISION		

**PROJECT**  
 NRHM PROJECT  
 Proposed 50 Bedded Hospital at **JASHPUR, CHATTISGARH**

**TITLE**  
**TENDER DRAWING**  
 SECOND FLOOR PLAN ELECTRICAL FIRE ALARM CONDUIT LAYOUT

HSCC/ EV210/ EL/ HOSP/ 002C		
Drawing No.		Rev.
HSCC/-	1:125	Date
Job No.	Scale	Date
Drawn by :	Rev. by	Prep. by

HSCC (INDIA) LIMITED  
 (A GOVERNMENT OF INDIA ENTERPRISES)

**HSCC**  
 NEW DELHI INDIA