


PDF Complete
 Your complimentary use period has ended.
 Thank you for using PDF Complete.
[Click Here to upgrade to Unlimited Pages and Expanded Features](#)

This drawing with all its contents is the sole intellectual property of the Hospital Services Consultancy Corporation (India) Ltd. Copying of this drawing or part thereof or its use in any form whatsoever without the written permission of HSCC is prohibited.

- NOTES**
1. DRAWINGS TO BE READ NOT MEASURED
 2. PARTITION WALL IN TOILETS UP TO LINTEL HEIGHT

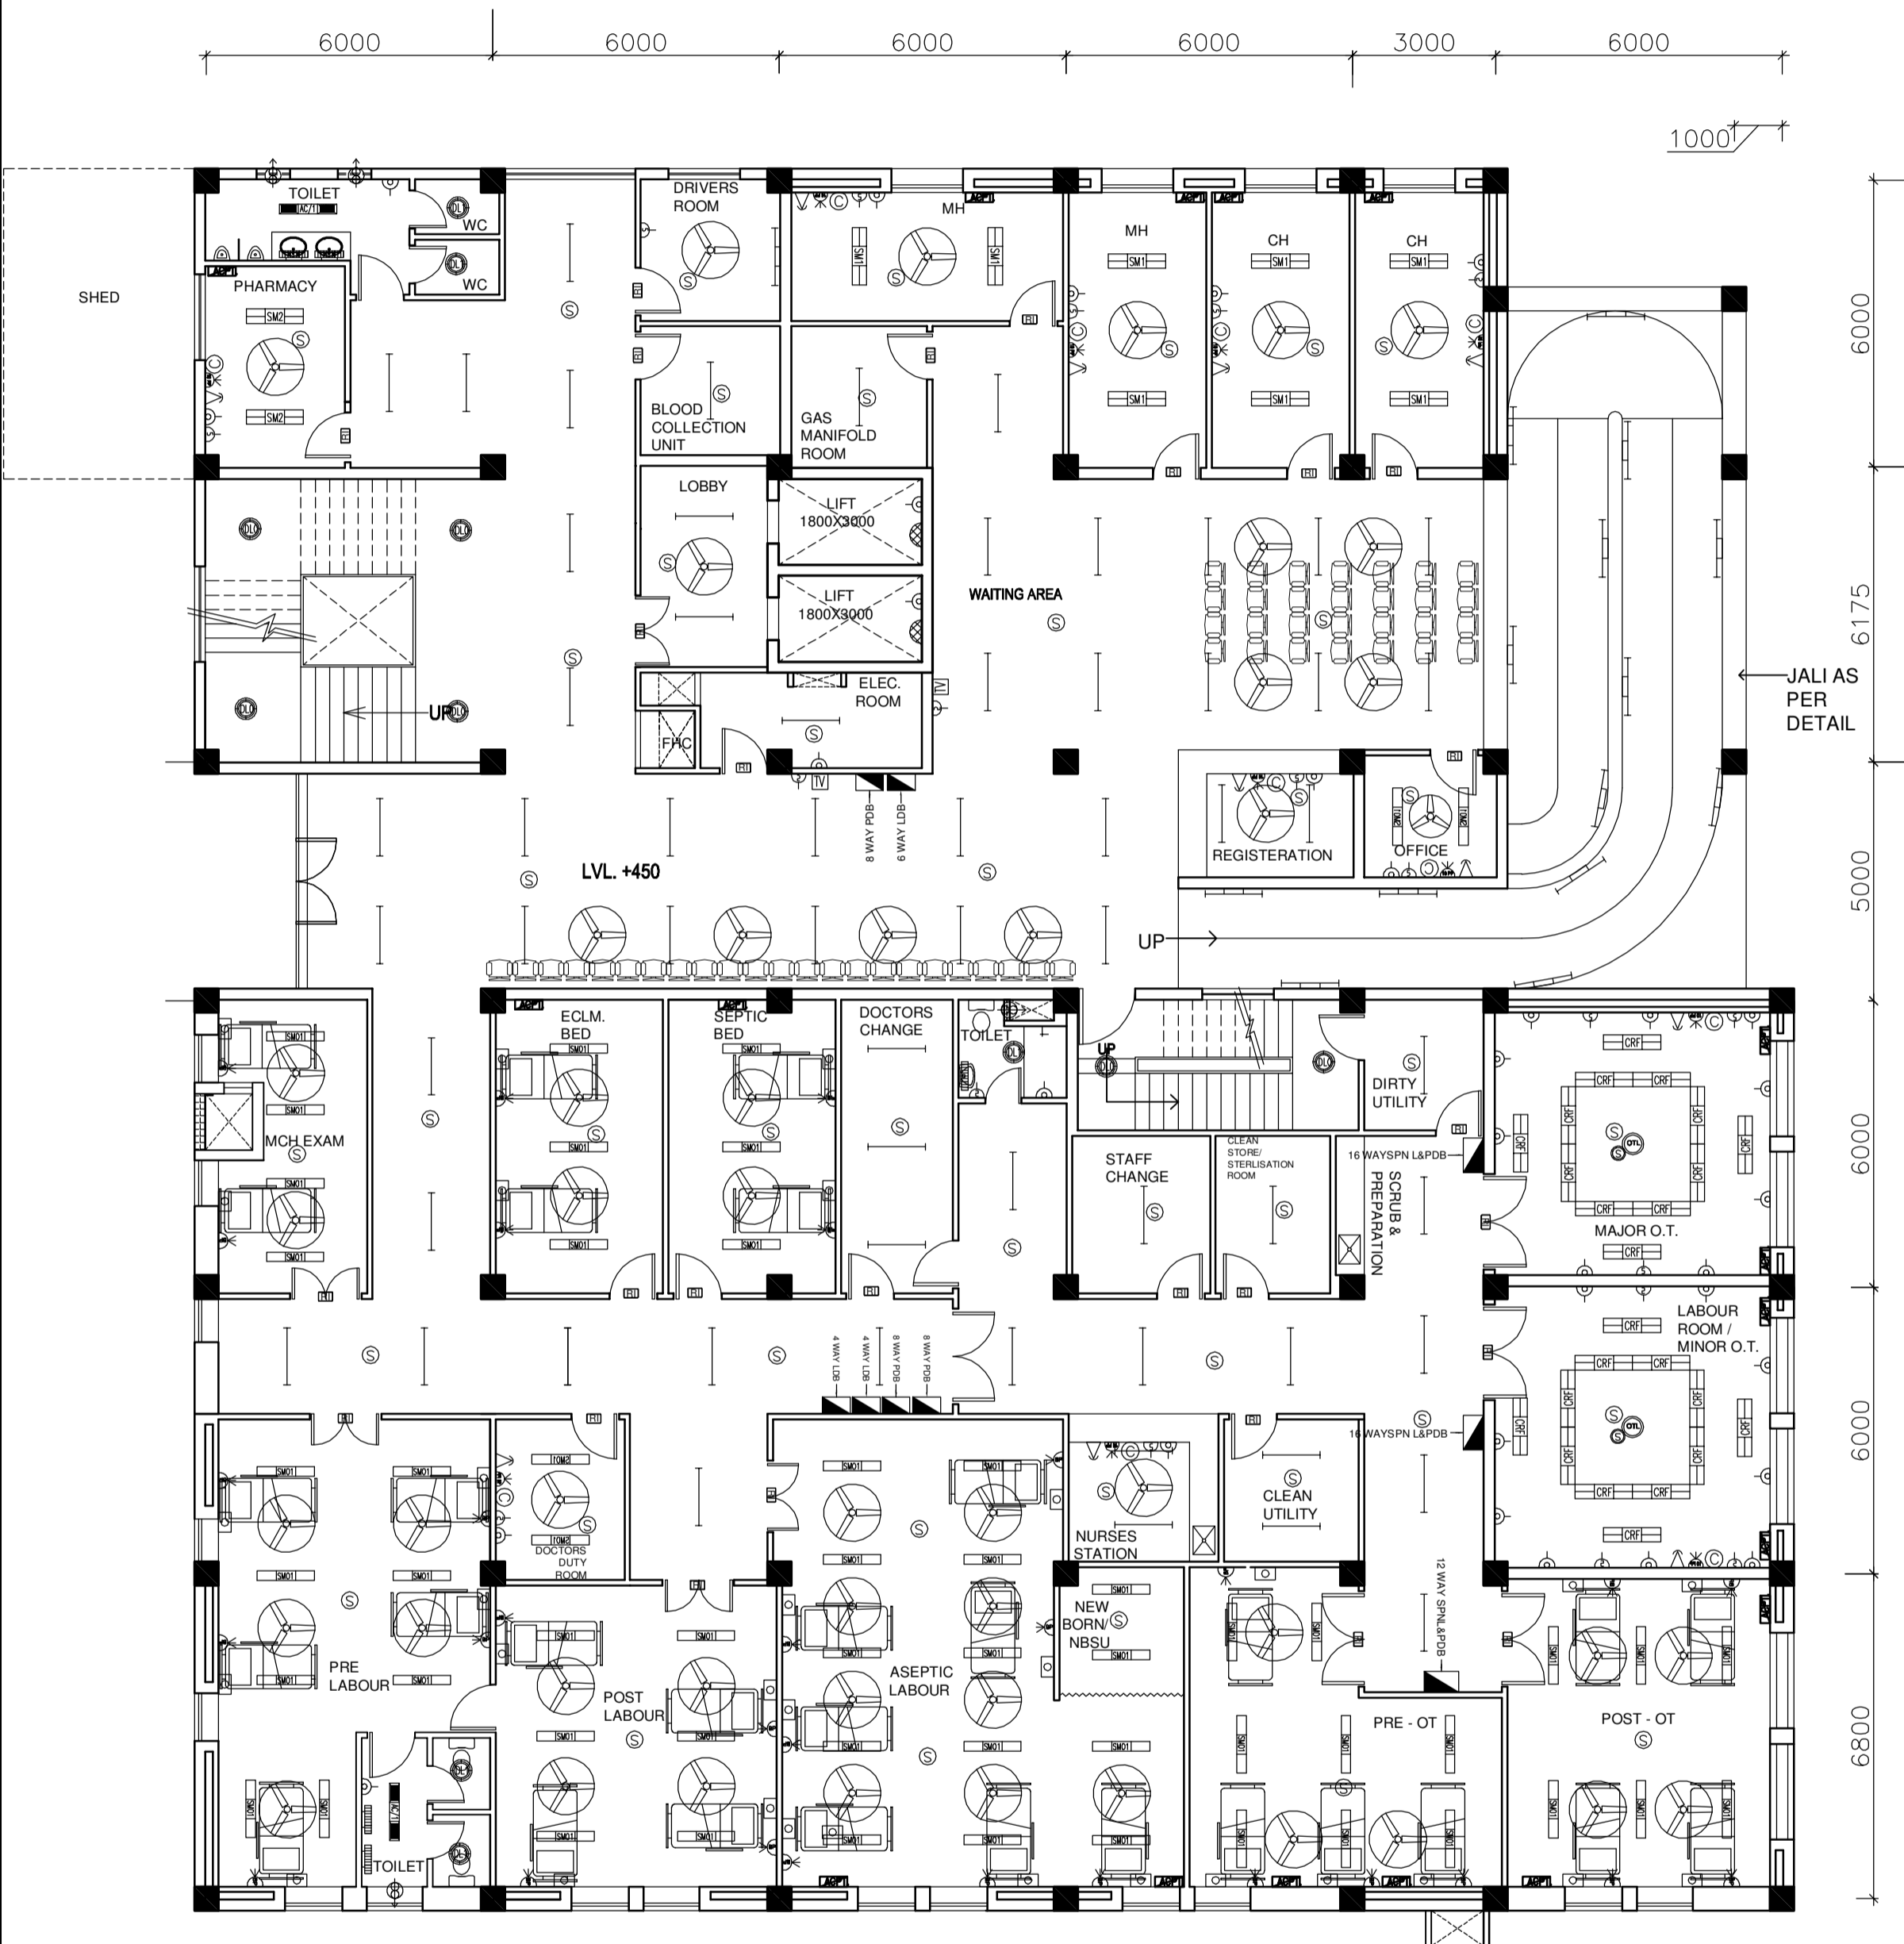

GROUND FLOOR PLAN

REVISION - 01
 REVISED AS PER THE GUIDELINES OF VETTING COMMITTEE

PROJECT
 PROPOSED
 100 BEDDED HOSPITAL
 ALIGARH

TITLE
 TENDER DRAWING
 GROUND FLOOR PLAN
 AREA - 1218.30 SQM
 (ELECTRICAL LAYOUT)

HSCC/TD/ALIGARH/EL-401
 Drawing No. _____ Rev. - _____


Job No.	NTS Scale	Date
App by	Rev. by	Prep. by

HSCC (INDIA) LIMITED
 (A GOVERNMENT OF INDIA ENTERPRISE)
HSCC
 NEW DELHI INDIA

PRODUCED BY AN AUTODESK EDUCATIONAL PRODUCT

This drawing with all its contents is the sole intellectual property of the Hospital Services Consultancy Corporation (India) Ltd. Copying of this drawing or part thereof or its use in any form whatsoever without the written permission of HSCC is prohibited.

- NOTES**
1. DRAWINGS TO BE READ NOT MEASURED
 2. PARTITION WALL IN TOILETS UP TO LINTEL HEIGHT

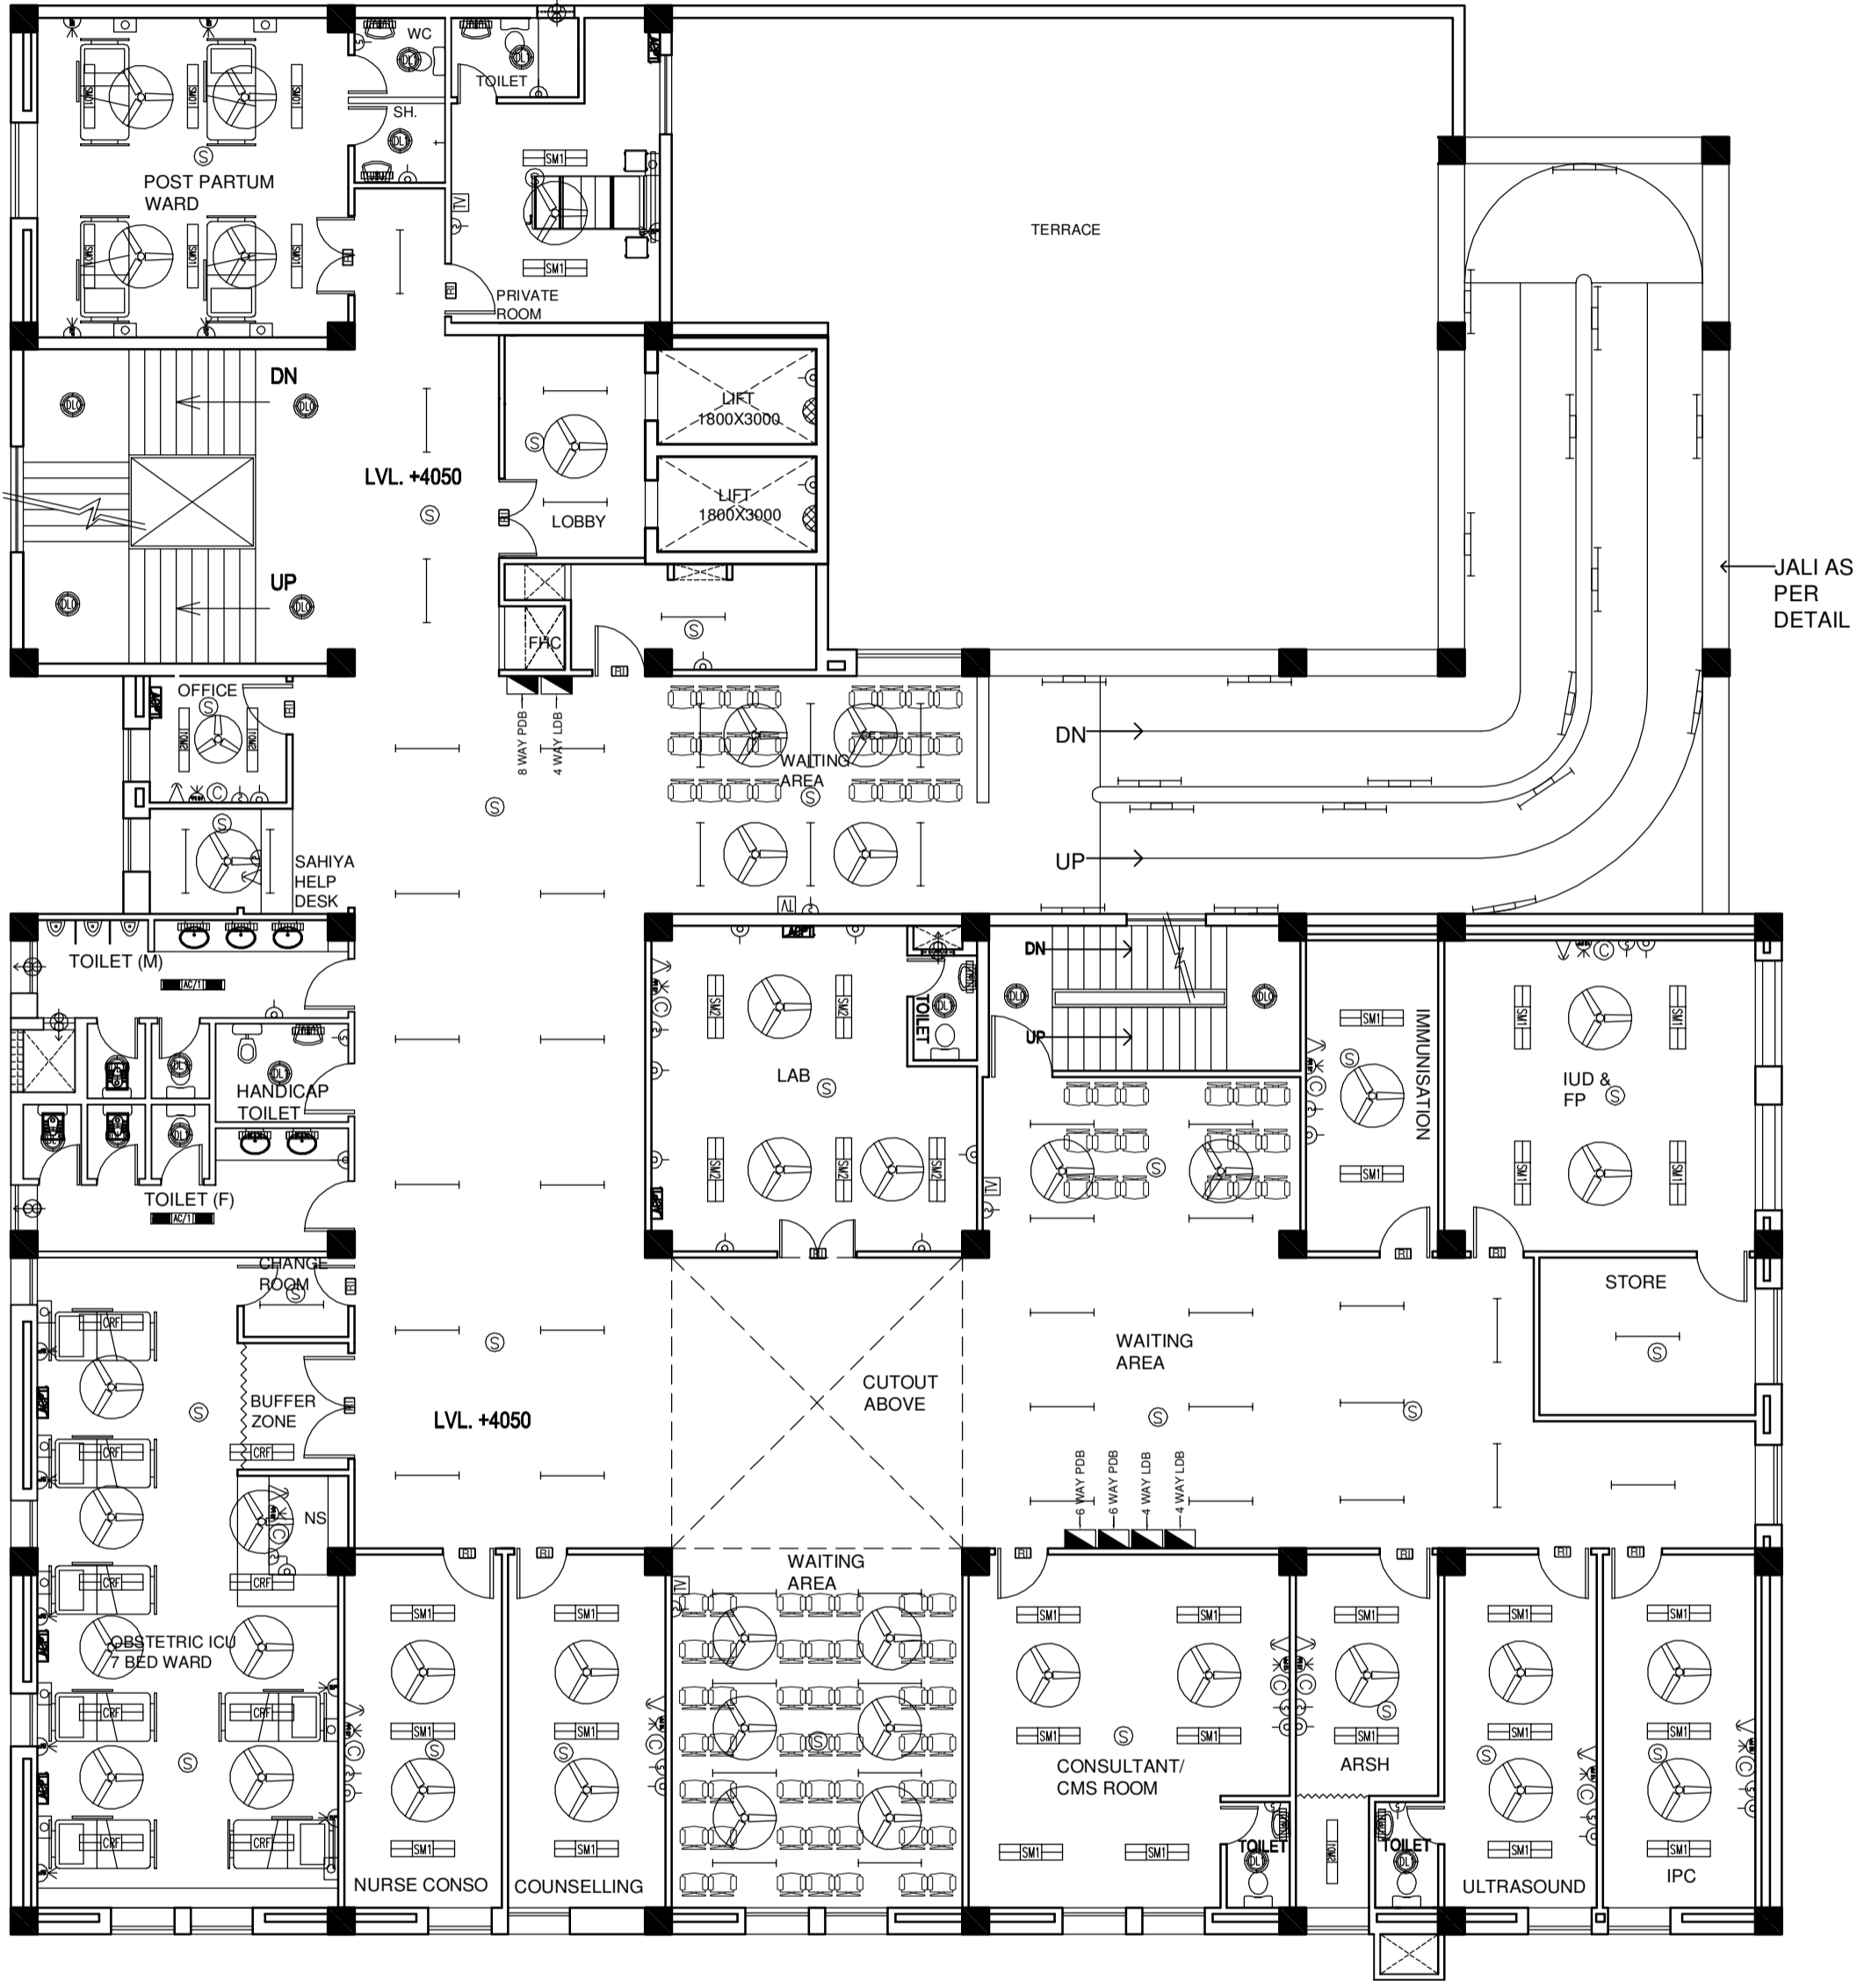

FIRST FLOOR PLAN
OPD + POST PARTUM WARD - 4 BEDDED +
OBSTETRIC ICU - 7 BEDDED + PRIVATE ROOM - 1 BED

REVISION - 01
 REVISED AS PER THE GUIDELINES OF VETTING COMMITTEE

PROJECT
 PROPOSED
 100 BEDDED HOSPITAL
 ALIGARH

TITLE
 TENDER DRAWING
 FIRST FLOOR PLAN
 AREA - 1032.78 SQM
 (ELECTRICAL LAYOUT)


HSCC/TD/ALIGARH/EL-402

Drawing No.		Rev. -
Job No.	NTS Scale	Date
App by	Rev. by	Prep. by

PRODUCED BY AN AUTODESK EDUCATIONAL PRODUCT

This drawing with all its contents is the sole intellectual property of the Hospital Services Consultancy Corporation (India) Ltd. Copying of this drawing or part thereof or its use in any form whatsoever without the written permission of HSCC is prohibited.

- NOTES**
1. DRAWINGS TO BE READ NOT MEASURED
 2. PARTITION WALL IN TOILETS UP TO LINTEL HEIGHT

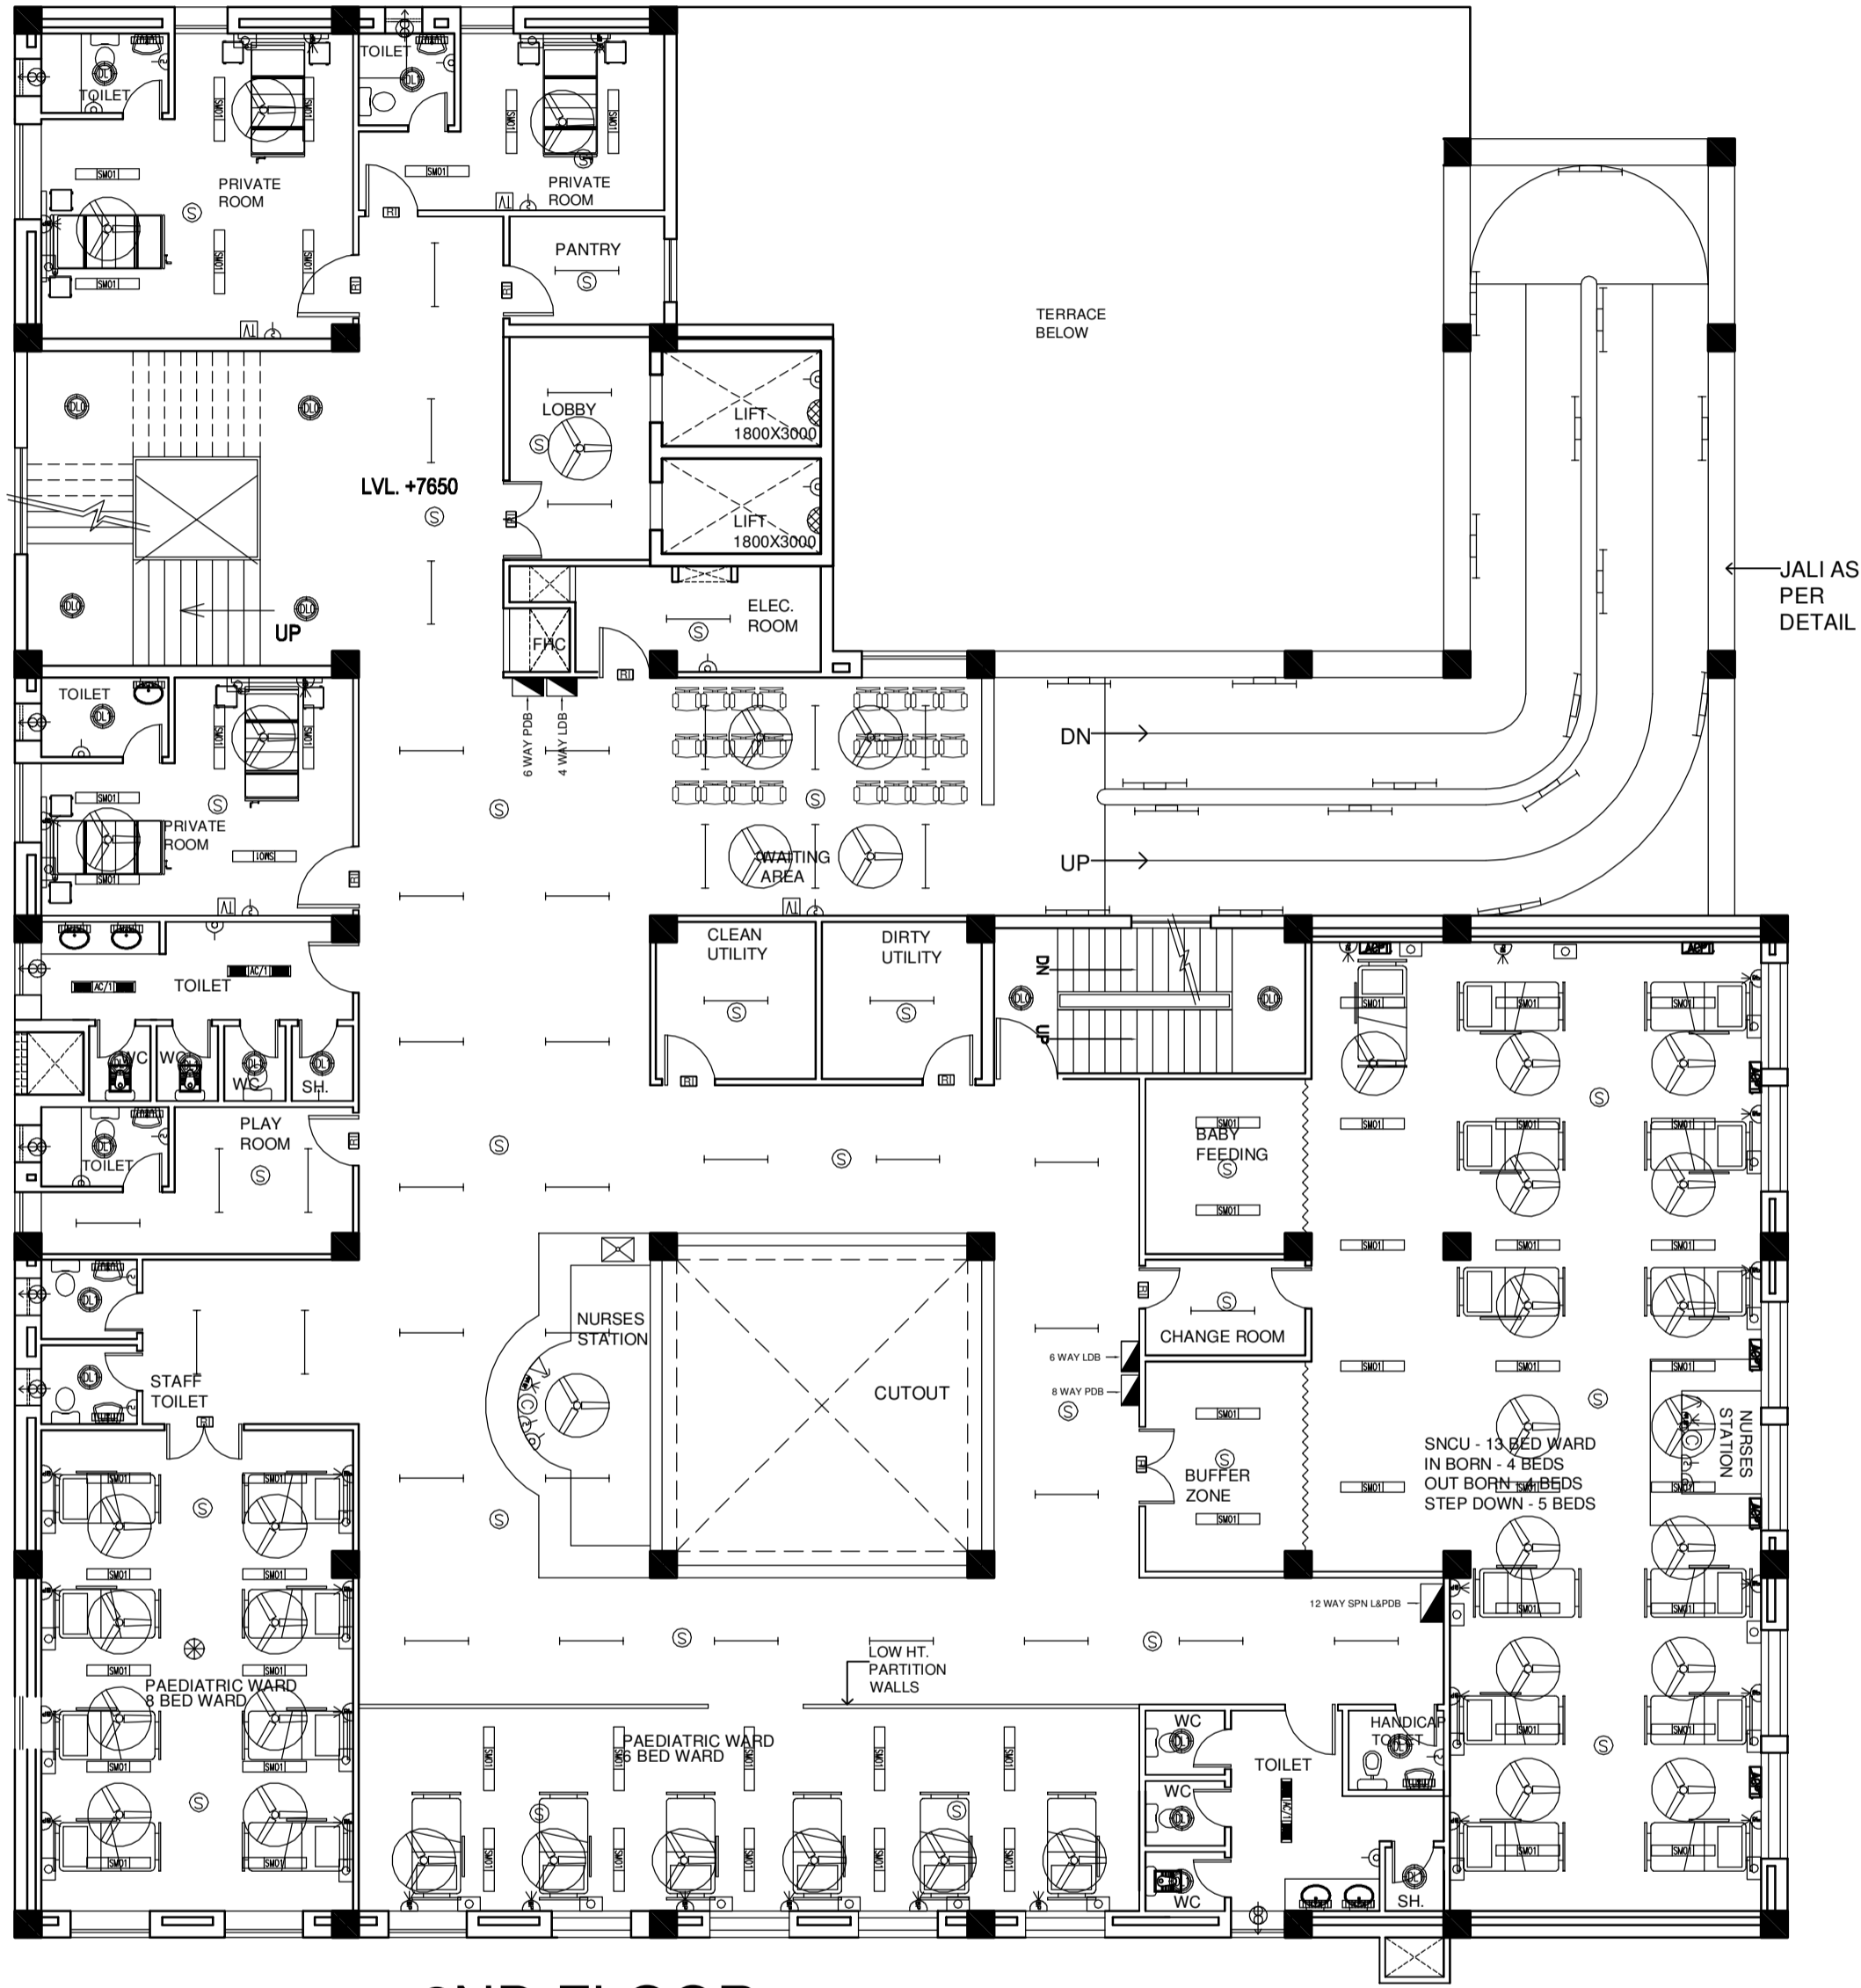

2ND FLOOR
PAEDIATRIC CARE
SNCU WARD - 13 BEDS
PAEDIATRIC WARD - 14 BEDS
PRIVATE ROOMS - 5 BEDS

REVISION - 01
 REVISED AS PER THE GUIDELINES OF VETTING COMMITTEE

PROJECT
 PROPOSED
 100 BEDDED HOSPITAL
 ALIGARH

TITLE
 TENDER DRAWING
 SECOND FLOOR PLAN
 AREA - 1032.78 SQM
 (ELECTRICAL LAYOUT)

HSCC/TD/ALIGARH/EL-403


Drawing No.		Rev. -
Job No.	NTS Scale	Date
App by	Rev. by	Prep. by

PRODUCED BY AN AUTODESK EDUCATIONAL PRODUCT

This drawing with all its contents is the sole intellectual property of the Hospital Services Consultancy Corporation (India) Ltd. Copying of this drawing or part thereof or its use in any form whatsoever without the written permission of HSCC is prohibited.

NOTES

1. DRAWINGS TO BE READ NOT MEASURED
2. PARTITION WALL IN TOILETS UP TO LINTEL HEIGHT

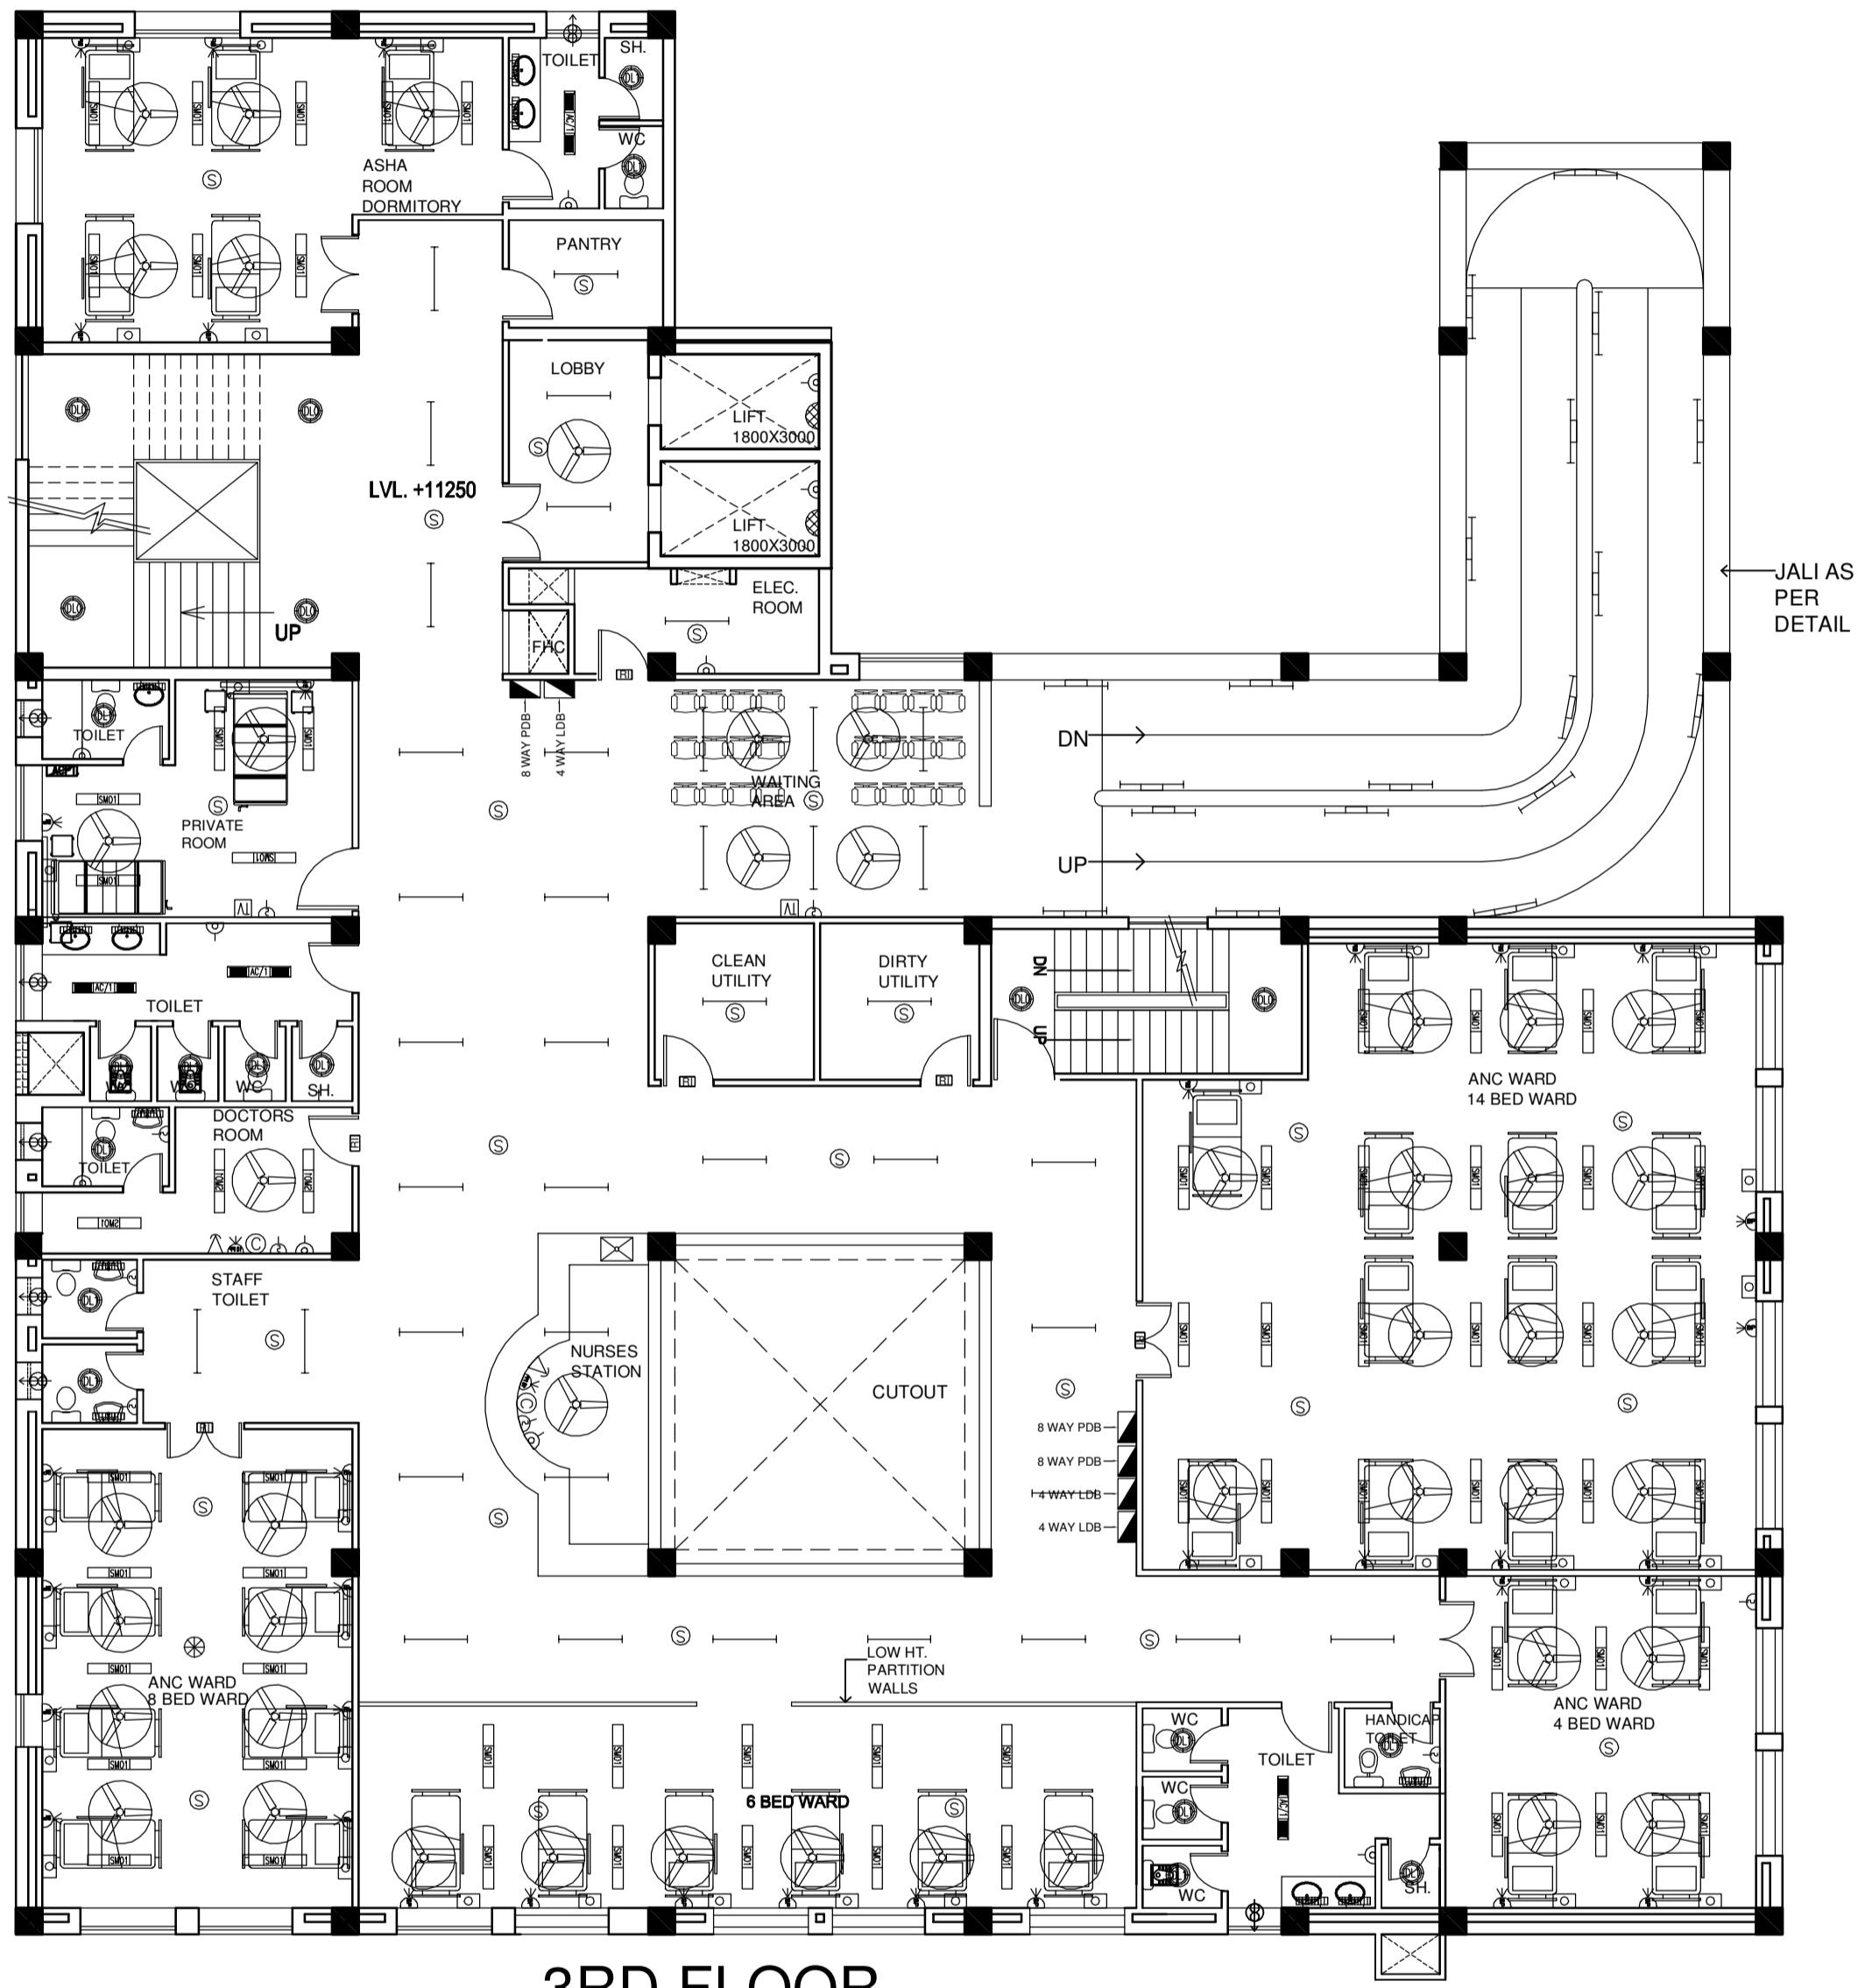

3RD FLOOR -
ANTE NATAL CARE WARD - 32 BEDS
ASHA ROOM DORMITORY - 5 BEDS
PRIVATE ROOM - 2 BEDS

PRODUCED BY AN AUTODESK EDUCATIONAL PRODUCT

REVISION - 01
 REVISED AS PER THE GUIDELINES OF VETTING COMMITTEE

PROJECT
 PROPOSED
 100 BEDDED HOSPITAL
 ALIGARH


TITLE
 TENDER DRAWING
 THIRD FLOOR PLAN
 AREA - 1032.78 SQM
 (ELECTRICAL LAYOUT)

HSCC/TD/ALIGARH/EL-404
 Drawing No. Rev. -

Job No.	NTS Scale	Date
App by	Rev. by	Prep. by

This drawing with all its contents is the sole intellectual property of the Hospital Services Consultancy Corporation (India) Ltd. Copying of this drawing or part thereof or its use in any form whatsoever without the written permission of HSCC is prohibited.

- NOTES**
1. DRAWINGS TO BE READ NOT MEASURED
 2. PARTITION WALL IN TOILETS UP TO LINTEL HEIGHT

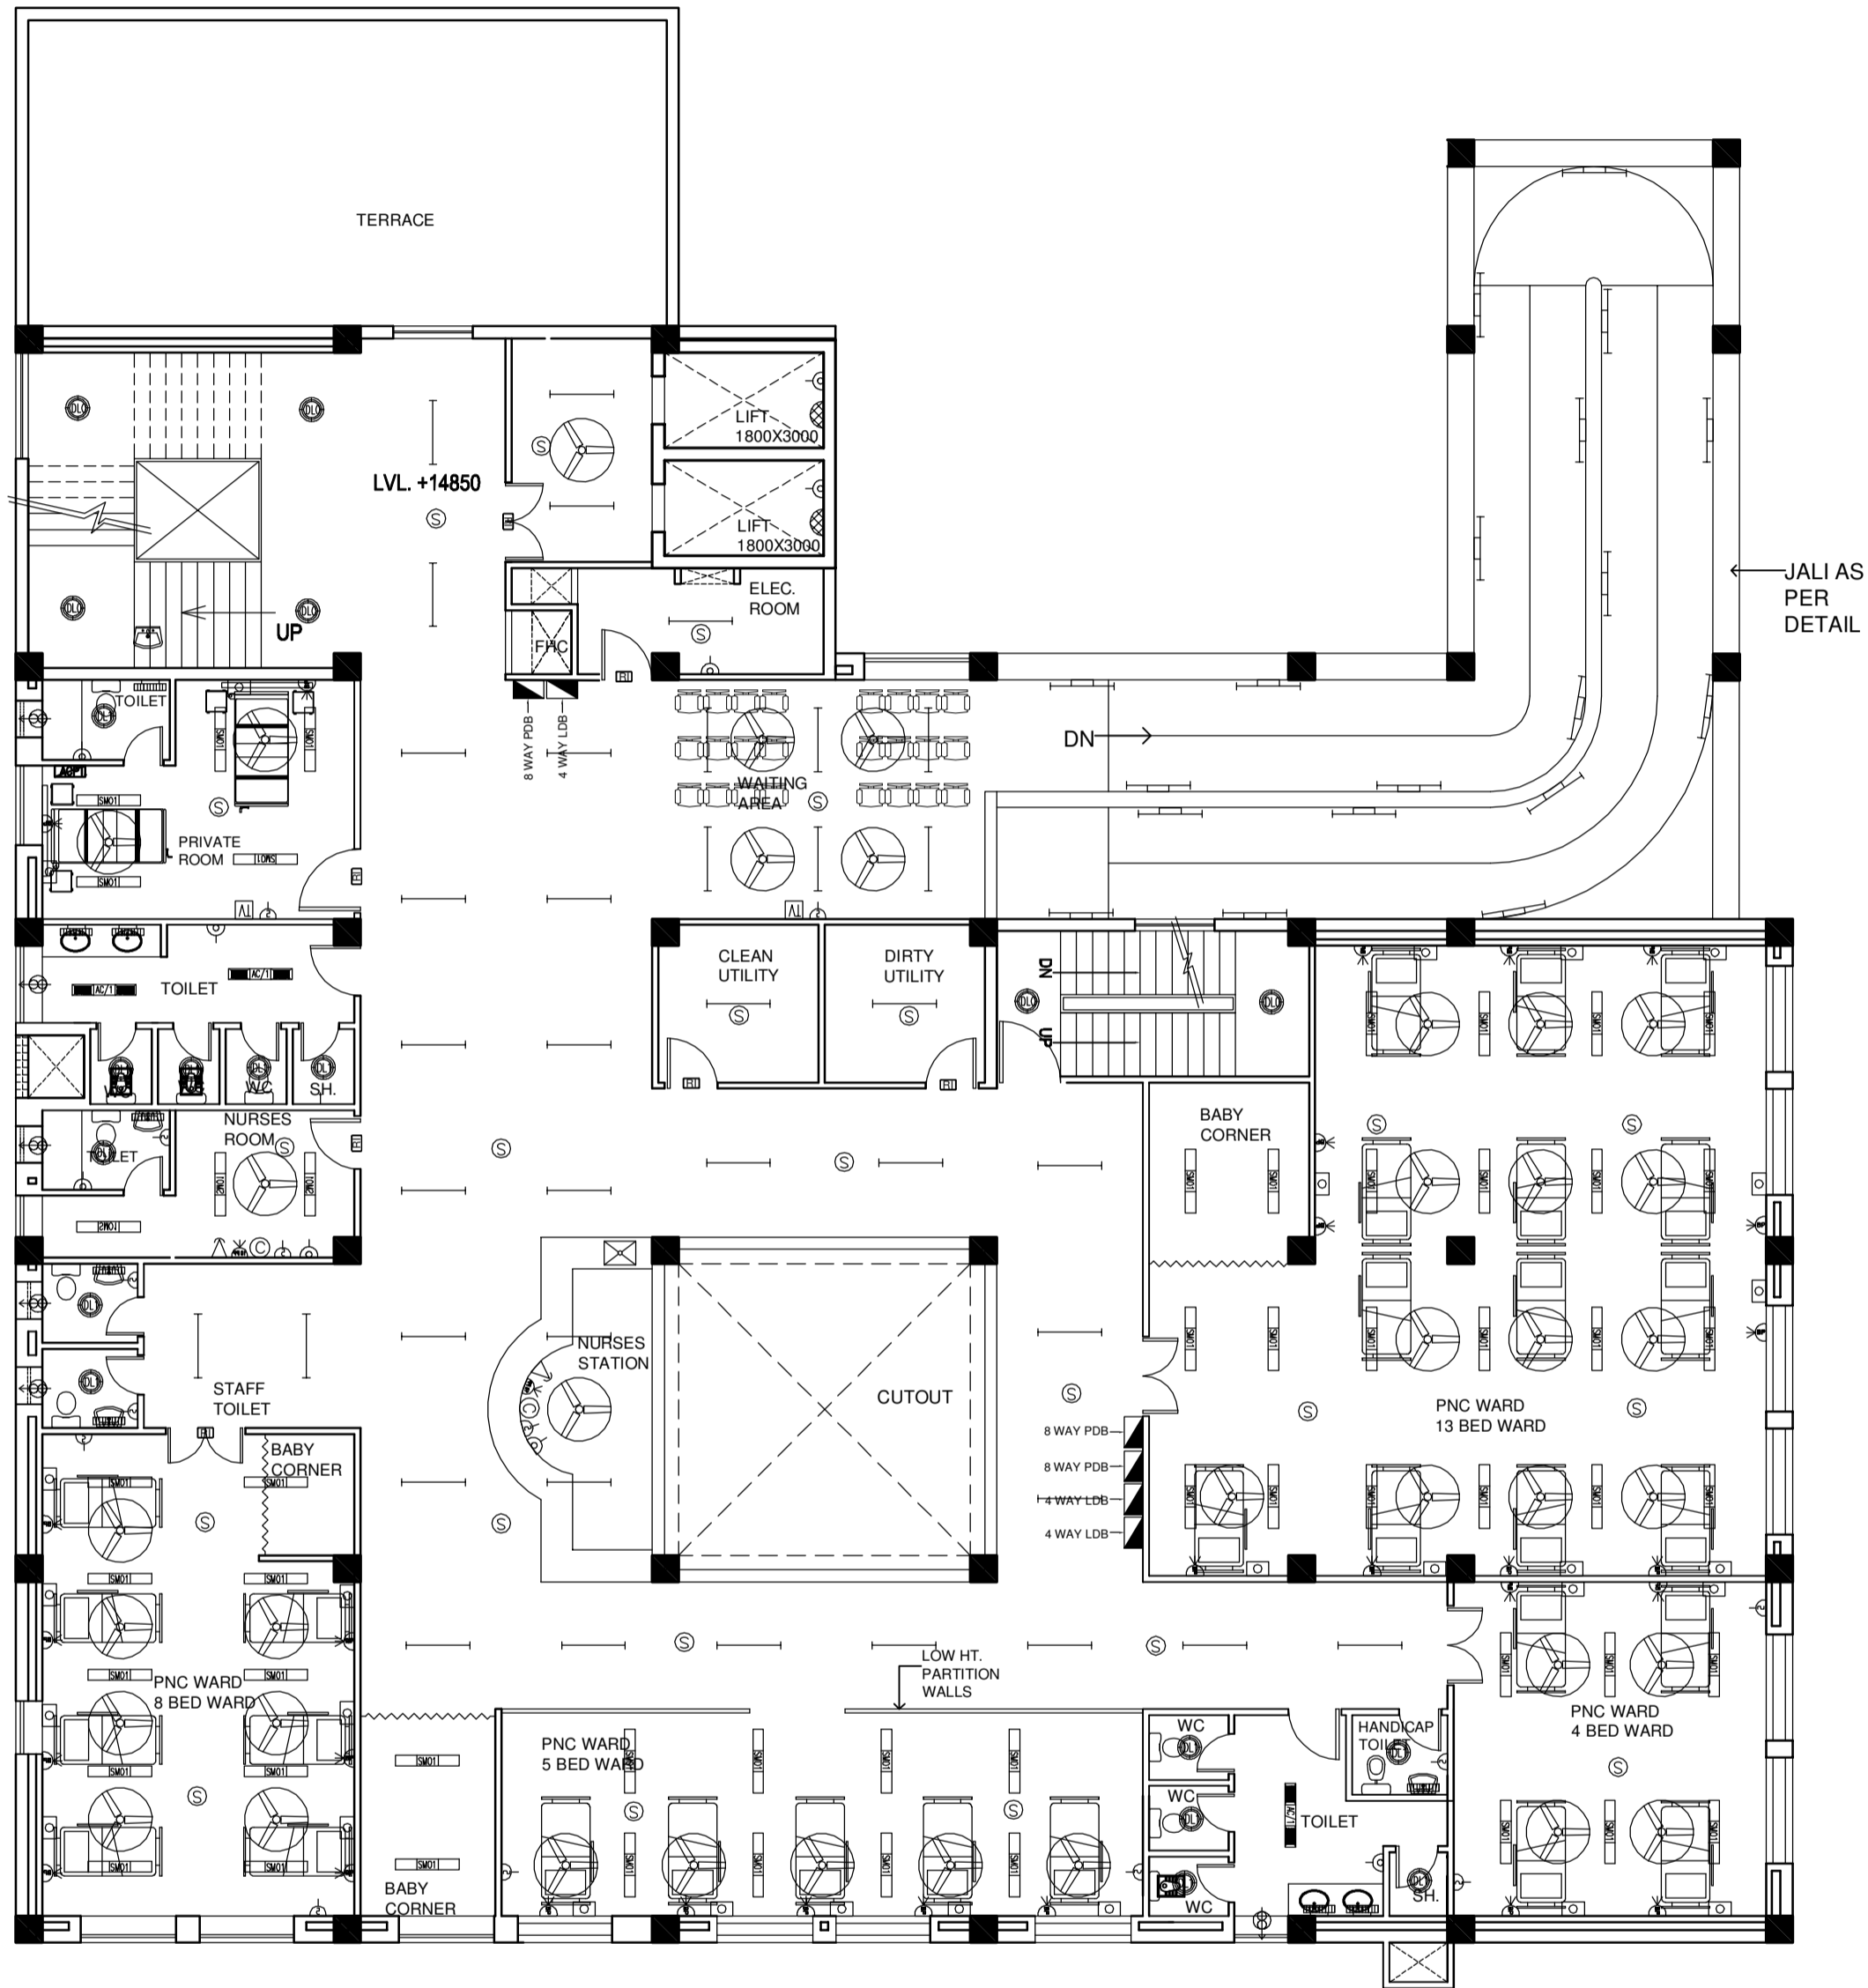

**4TH FLOOR -
 POST NATAL CARE WARD - 32 BEDS
 PRIVATE ROOMS - 2 BEDS**

REVISION - 01
 REVISED AS PER THE GUIDELINES OF VETTING COMMITTEE

PROJECT
 PROPOSED
 100 BEDDED HOSPITAL
 ALIGARH


TITLE
 TENDER DRAWING
 FOURTH FLOOR PLAN
 AREA - 834.53 SQM
 (ELECTRICAL LAYOUT)

HSCC/TD/ALIGARH/EL-405
 Drawing No.

Job No.	NTS Scale	Date
App by	Rev. by	Prep. by

This drawing with all its contents is the sole intellectual property of the Hospital Services Consultancy Corporation (India) Ltd. Copying of this drawing or part thereof or its use in any form whatsoever without the written permission of HSCC is prohibited.

- NOTES**
1. DRAWINGS TO BE READ NOT MEASURED
 2. PARTITION WALL IN TOILETS UP TO LINTEL HEIGHT

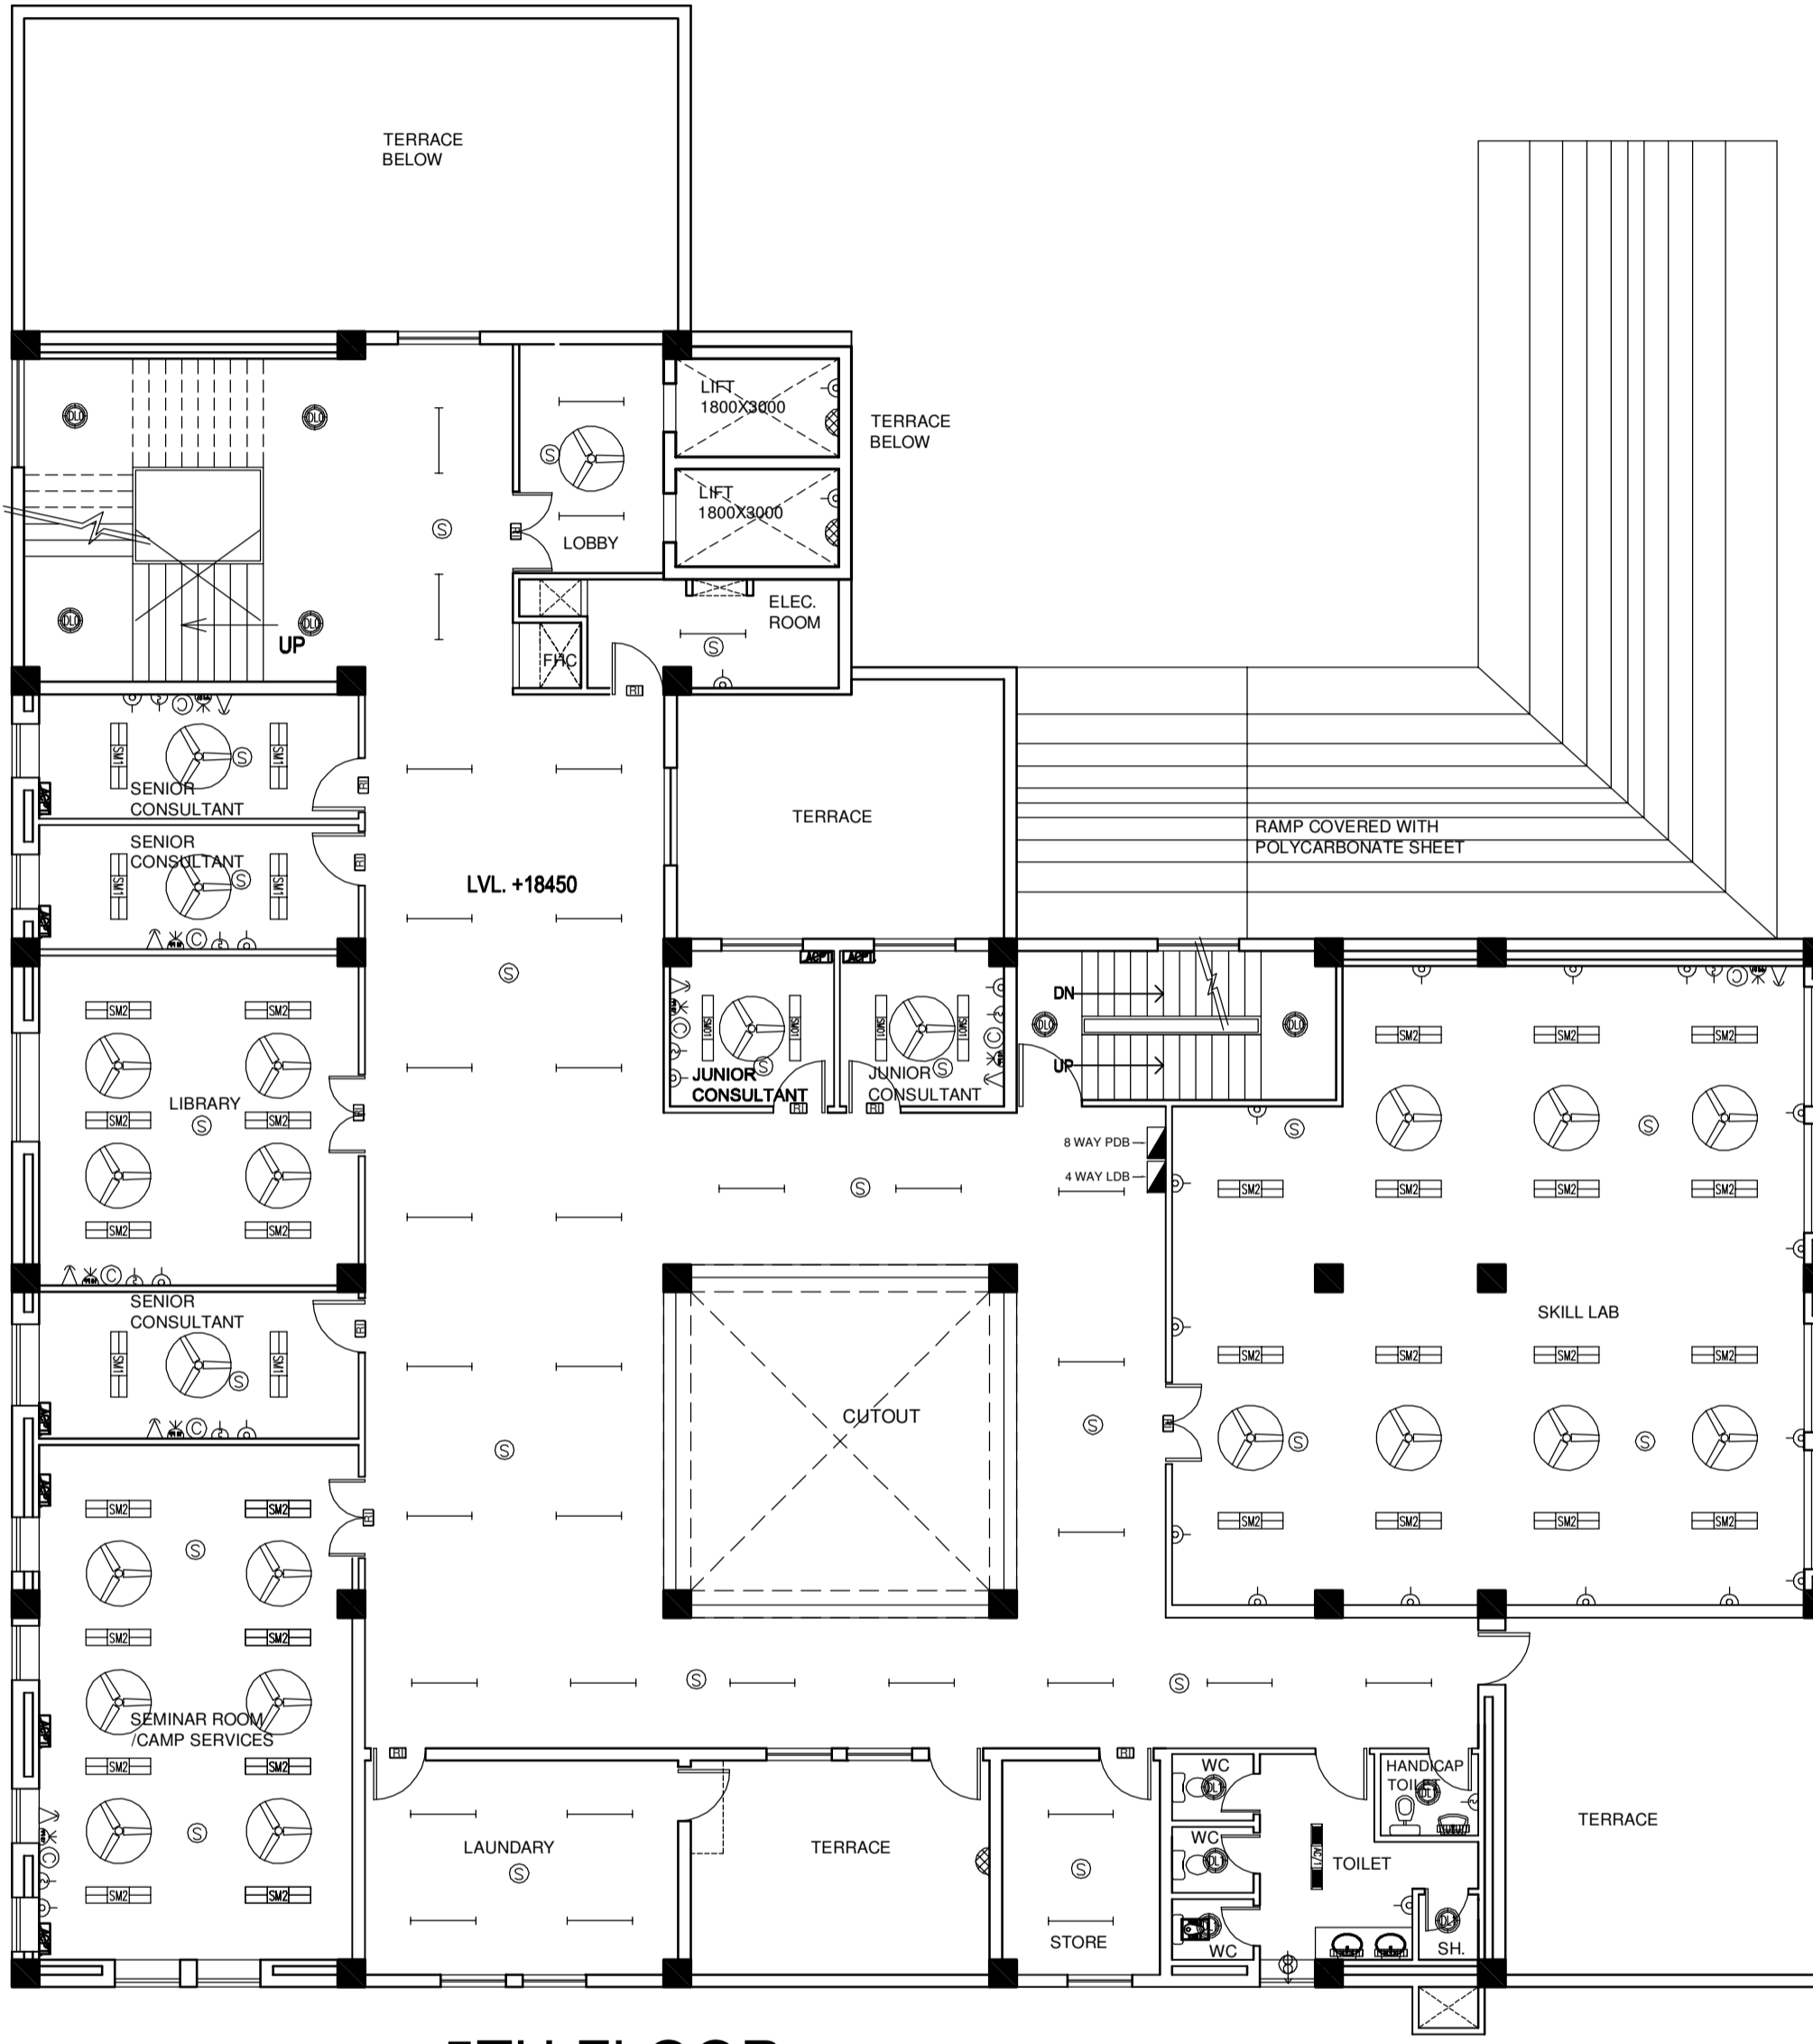

5TH FLOOR

REVISION - 01
 REVISED AS PER THE GUIDELINES OF VETTING COMMITTEE

PROJECT
 PROPOSED
 100 BEDDED HOSPITAL
 ALIGARH

TITLE
 TENDER DRAWING
 FIFTH FLOOR PLAN
 AREA - 741.11 SQM
 (ELECTRICAL LAYOUT)

HSCC/TD/ALIGARH/EL-406
 Drawing No.

Job No.	NTS Scale	Date
App by	Rev. by	Prep. by

PRODUCED BY AN AUTODESK EDUCATIONAL PRODUCT