


NOTES
 1. DRAWINGS TO BE READ NOT MEASURED
 2. PARTITION WALL IN TOILETS UP TO LINTEL HEIGHT

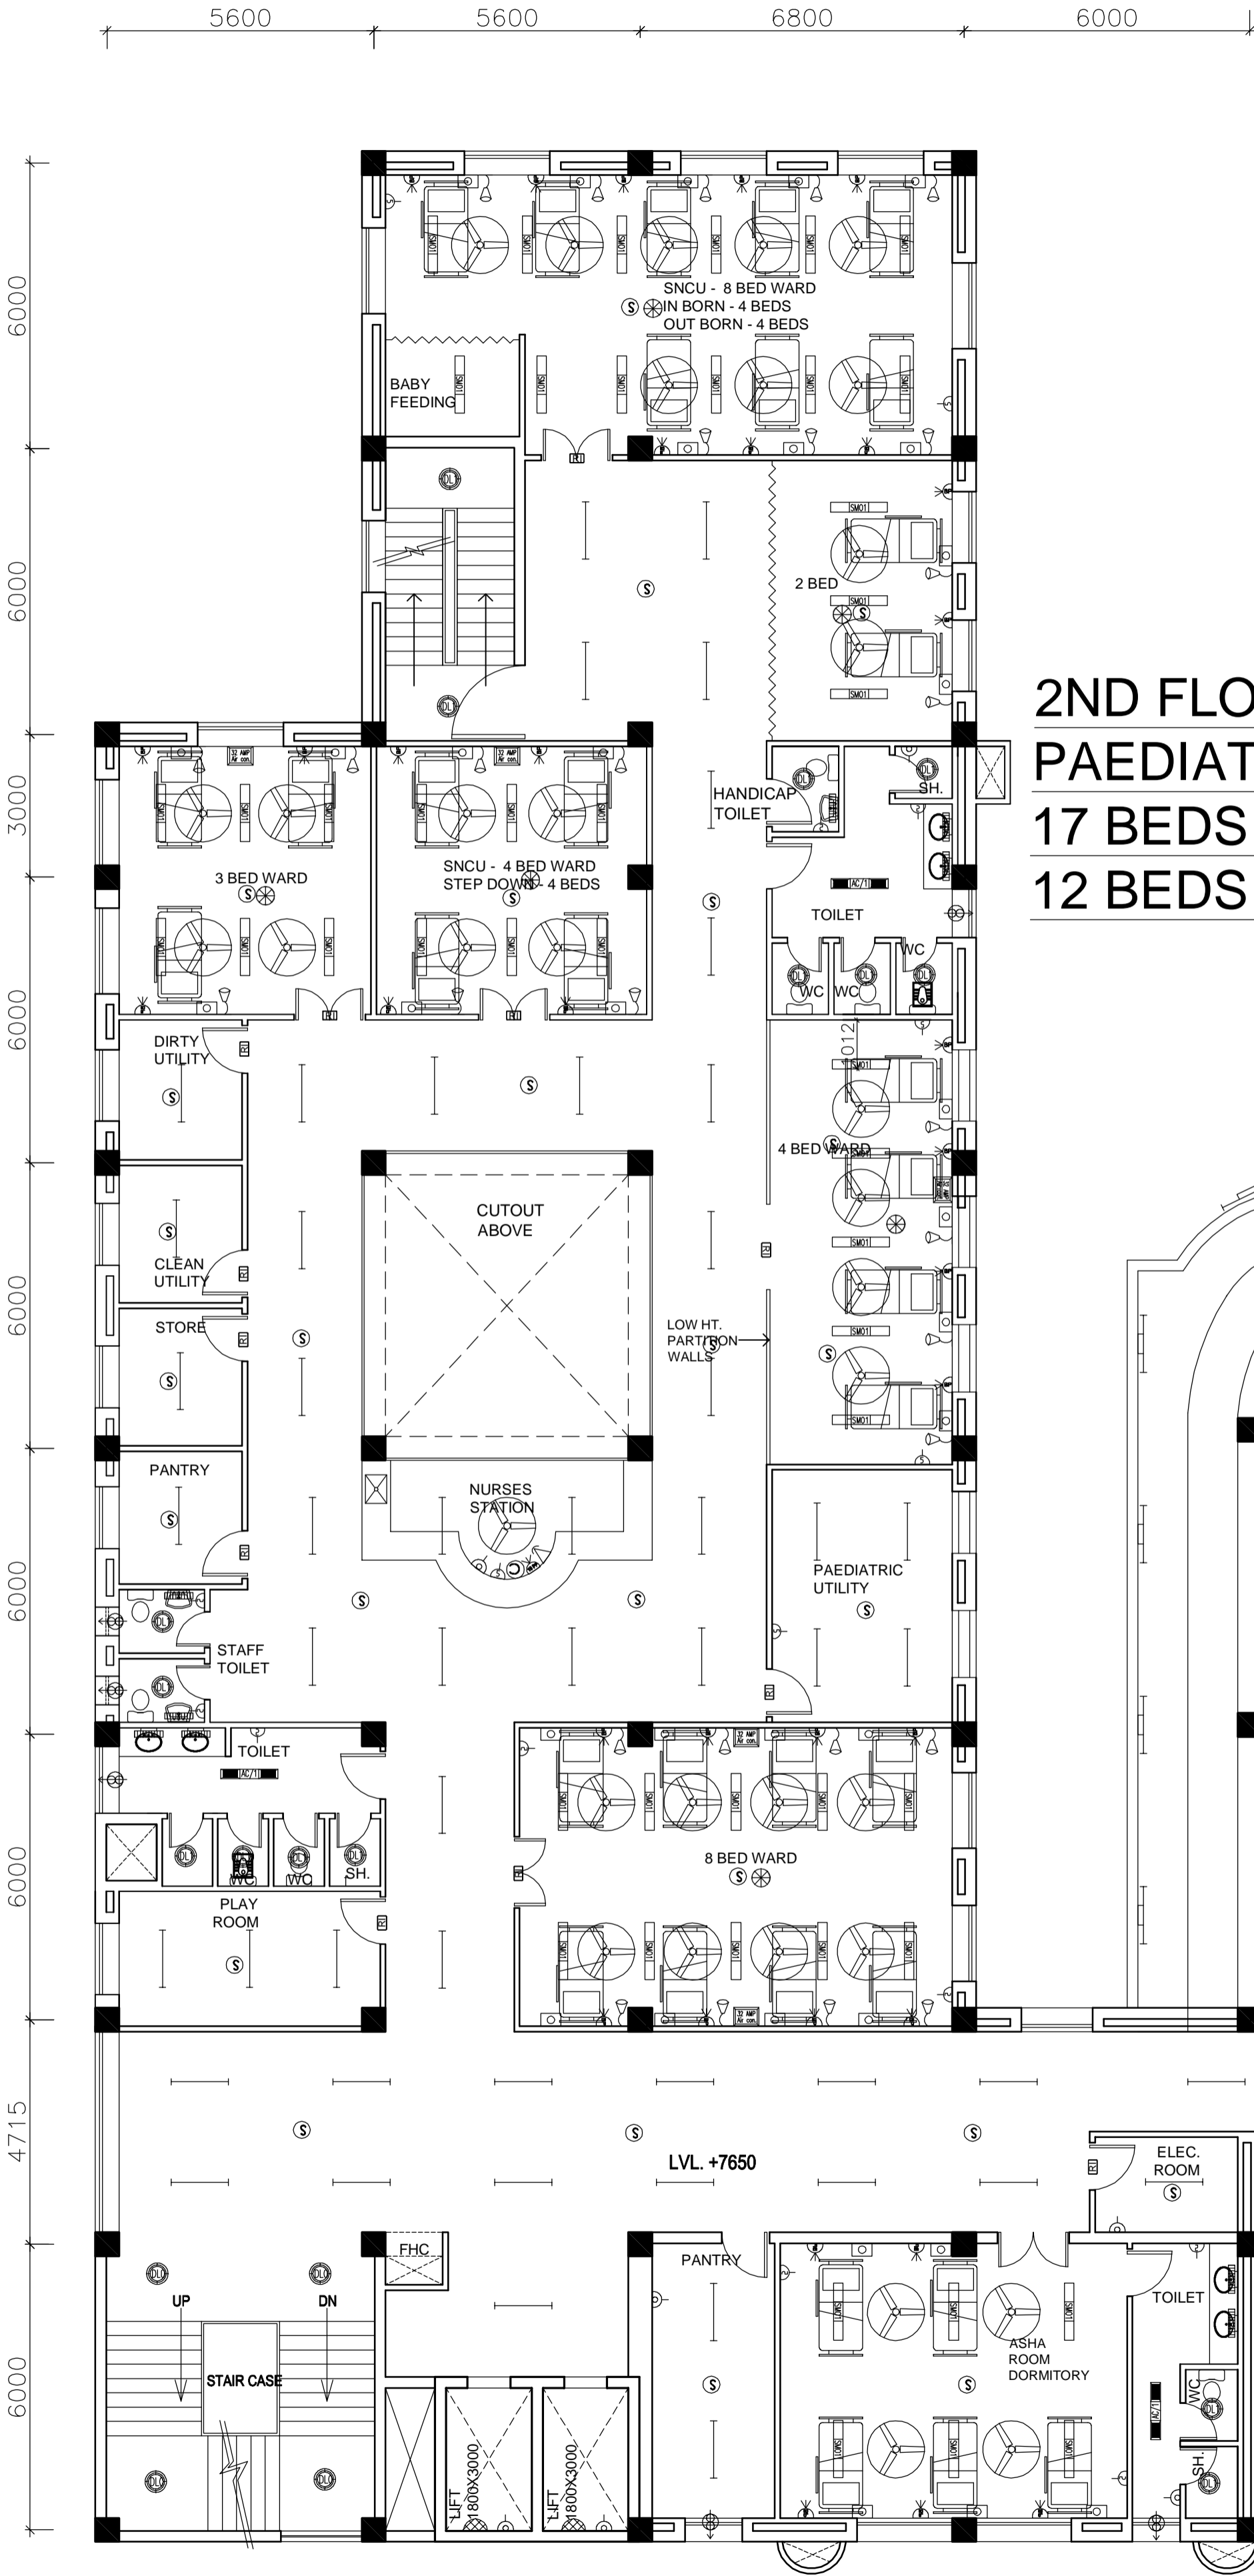

**2ND FLOOR -
 PAEDIATRIC CARE
 17 BEDS - PAEDIATRIC
 12 BEDS - SNCU**

REVISION - 01
 REVISED AS PER THE GUIDELINES OF VETTING COMMITTEE

PROJECT
 PROPOSED
 100 BEDDED HOSPITAL
 MUJAFFARNAGAR


TITLE
 TENDER DRAWING
 SECOND FLOOR PLAN
 AREA - 1030.59 SQM

ELECTRICAL LAYOUT

HSCC/TD/MUJAFFARNAGAR/EL-103
 Drawing No. Rev. - 01

Job No.	Scale	Date
App by	Rev. by	Prep. by

- NOTES**
1. DRAWINGS TO BE READ NOT MEASURED
 2. PARTITION WALL IN TOILETS UP TO LINTEL HEIGHT

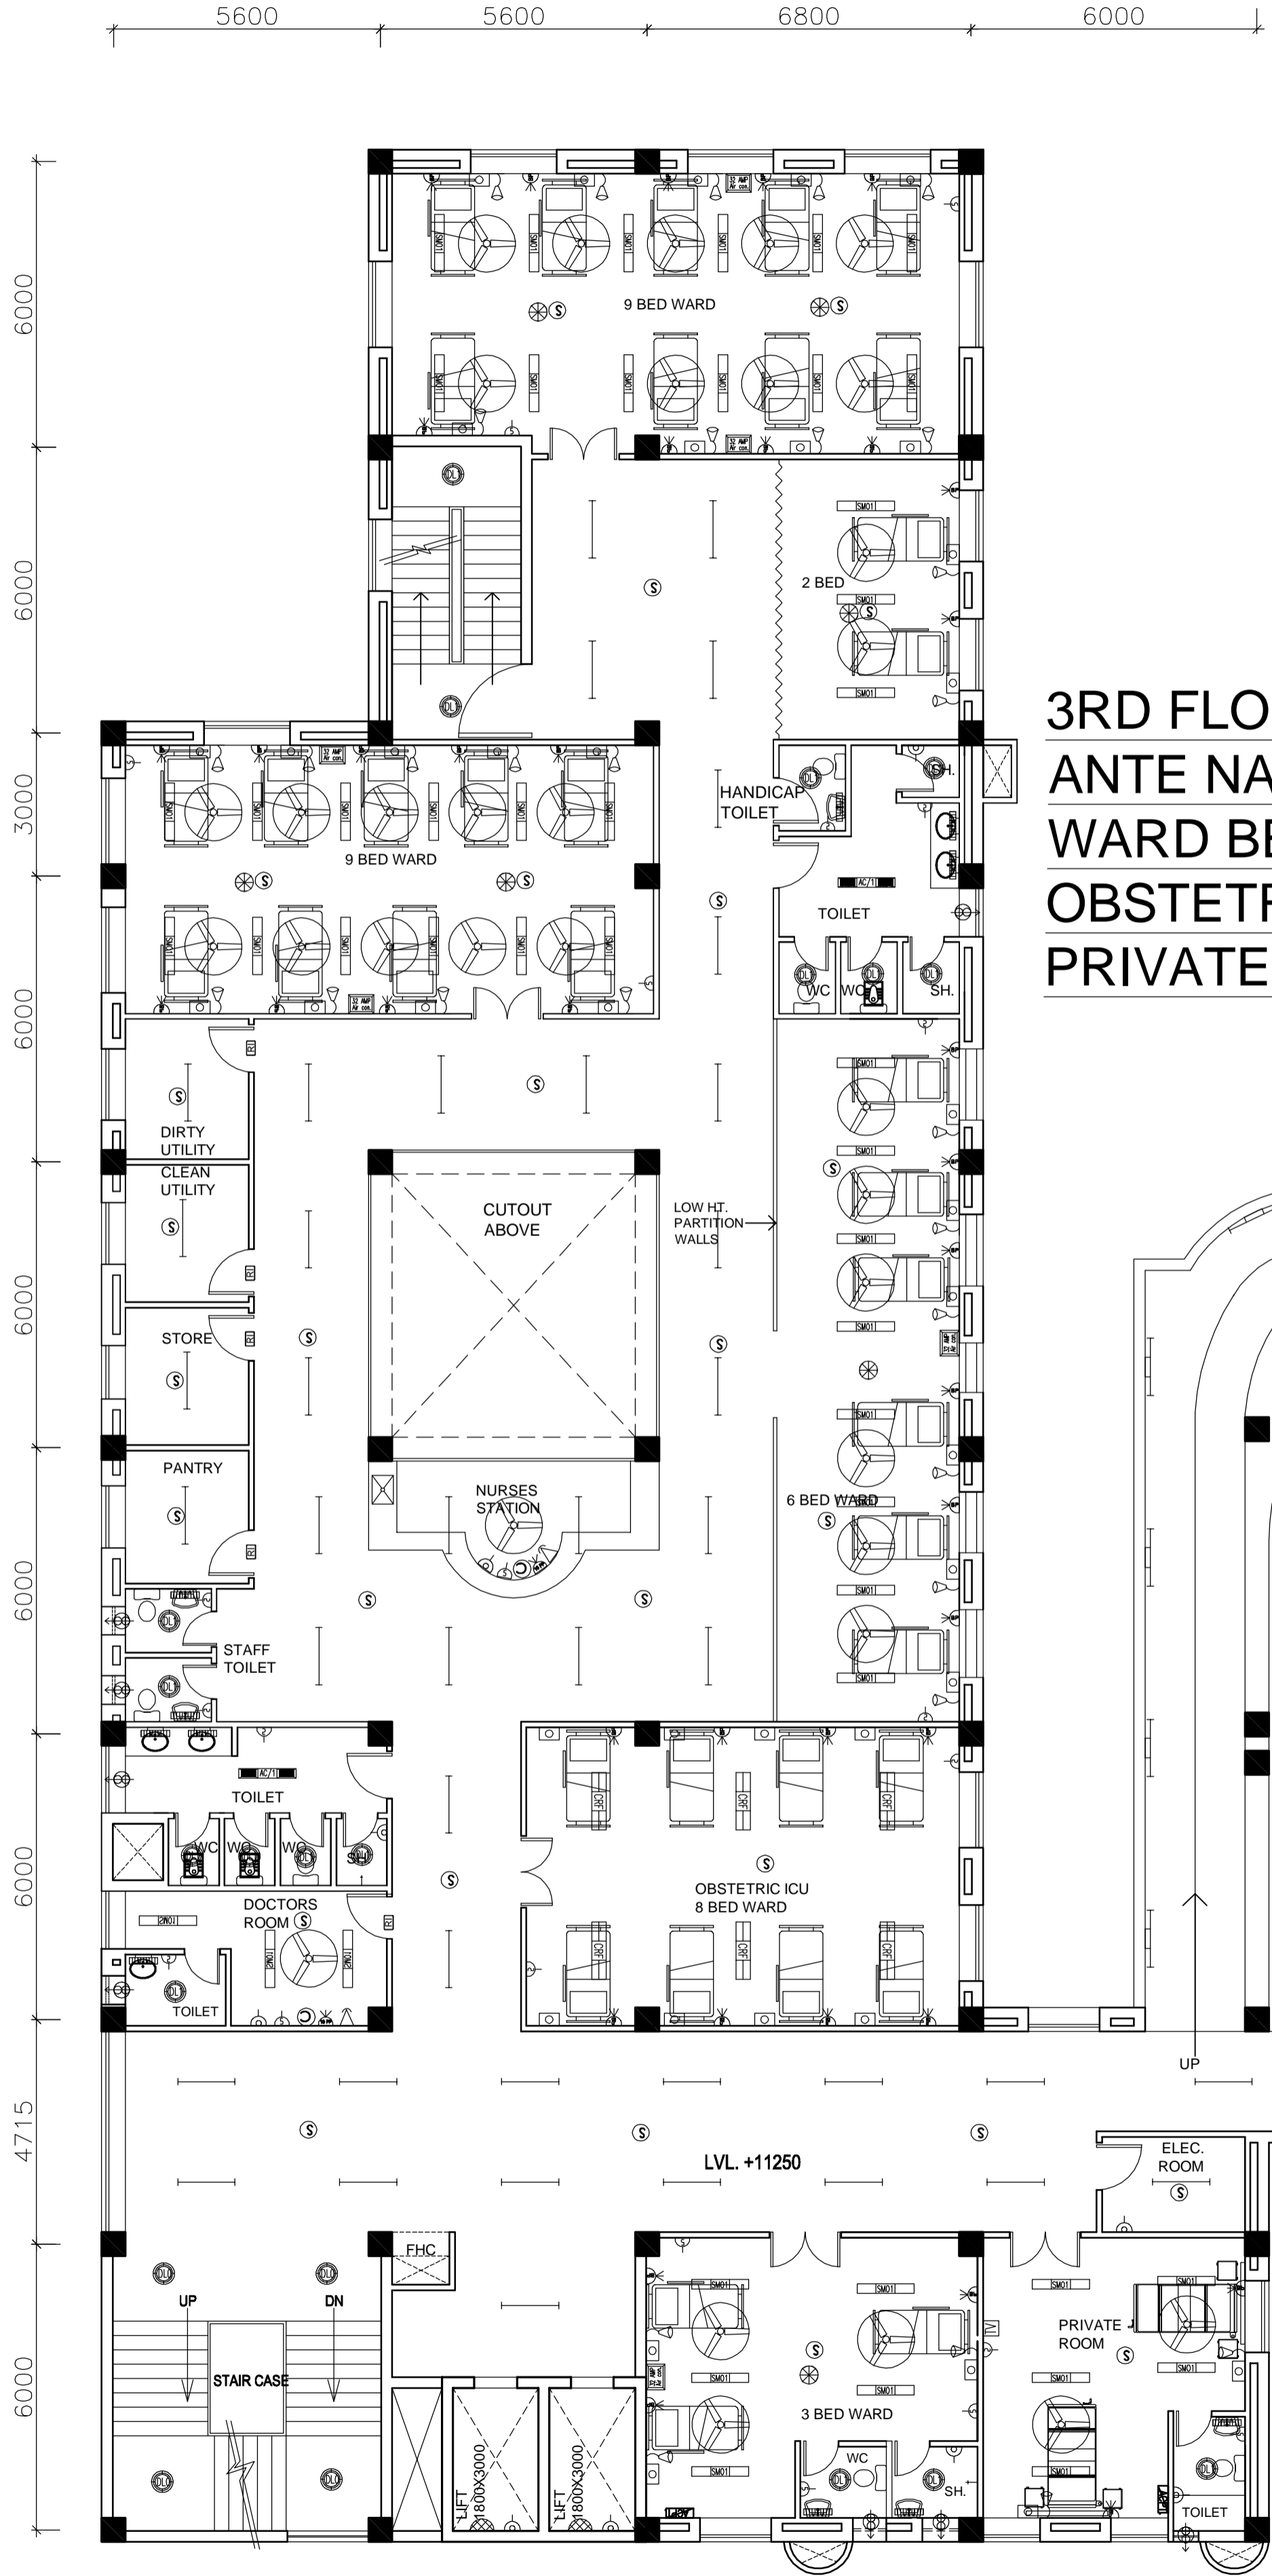

**3RD FLOOR -
 ANTE NATAL CARE
 WARD BEDS - 29 NO.
 OBSTETRIC ICU - 8 BED
 PRIVATE ROOM - 2 BEDS**

REVISION - 01
 REVISED AS PER THE GUIDELINES OF VETTING COMMITTEE

PROJECT
 PROPOSED
 100 BEDDED HOSPITAL
 MUJAFFARNAGAR


TITLE
 TENDER DRAWING
 THIRD FLOOR PLAN
 AREA - 1030.59 SQM

ELECTRICAL LAYOUT

HSCC/TD/MUJAFFARNAGAR/EL-104
 Drawing No. Rev. - 01

Job No.	Scale	Date
App by	Rev. by	Prep. by

- NOTES**
1. DRAWINGS TO BE READ NOT MEASURED
 2. PARTITION WALL IN TOILETS UP TO LINTEL HEIGHT

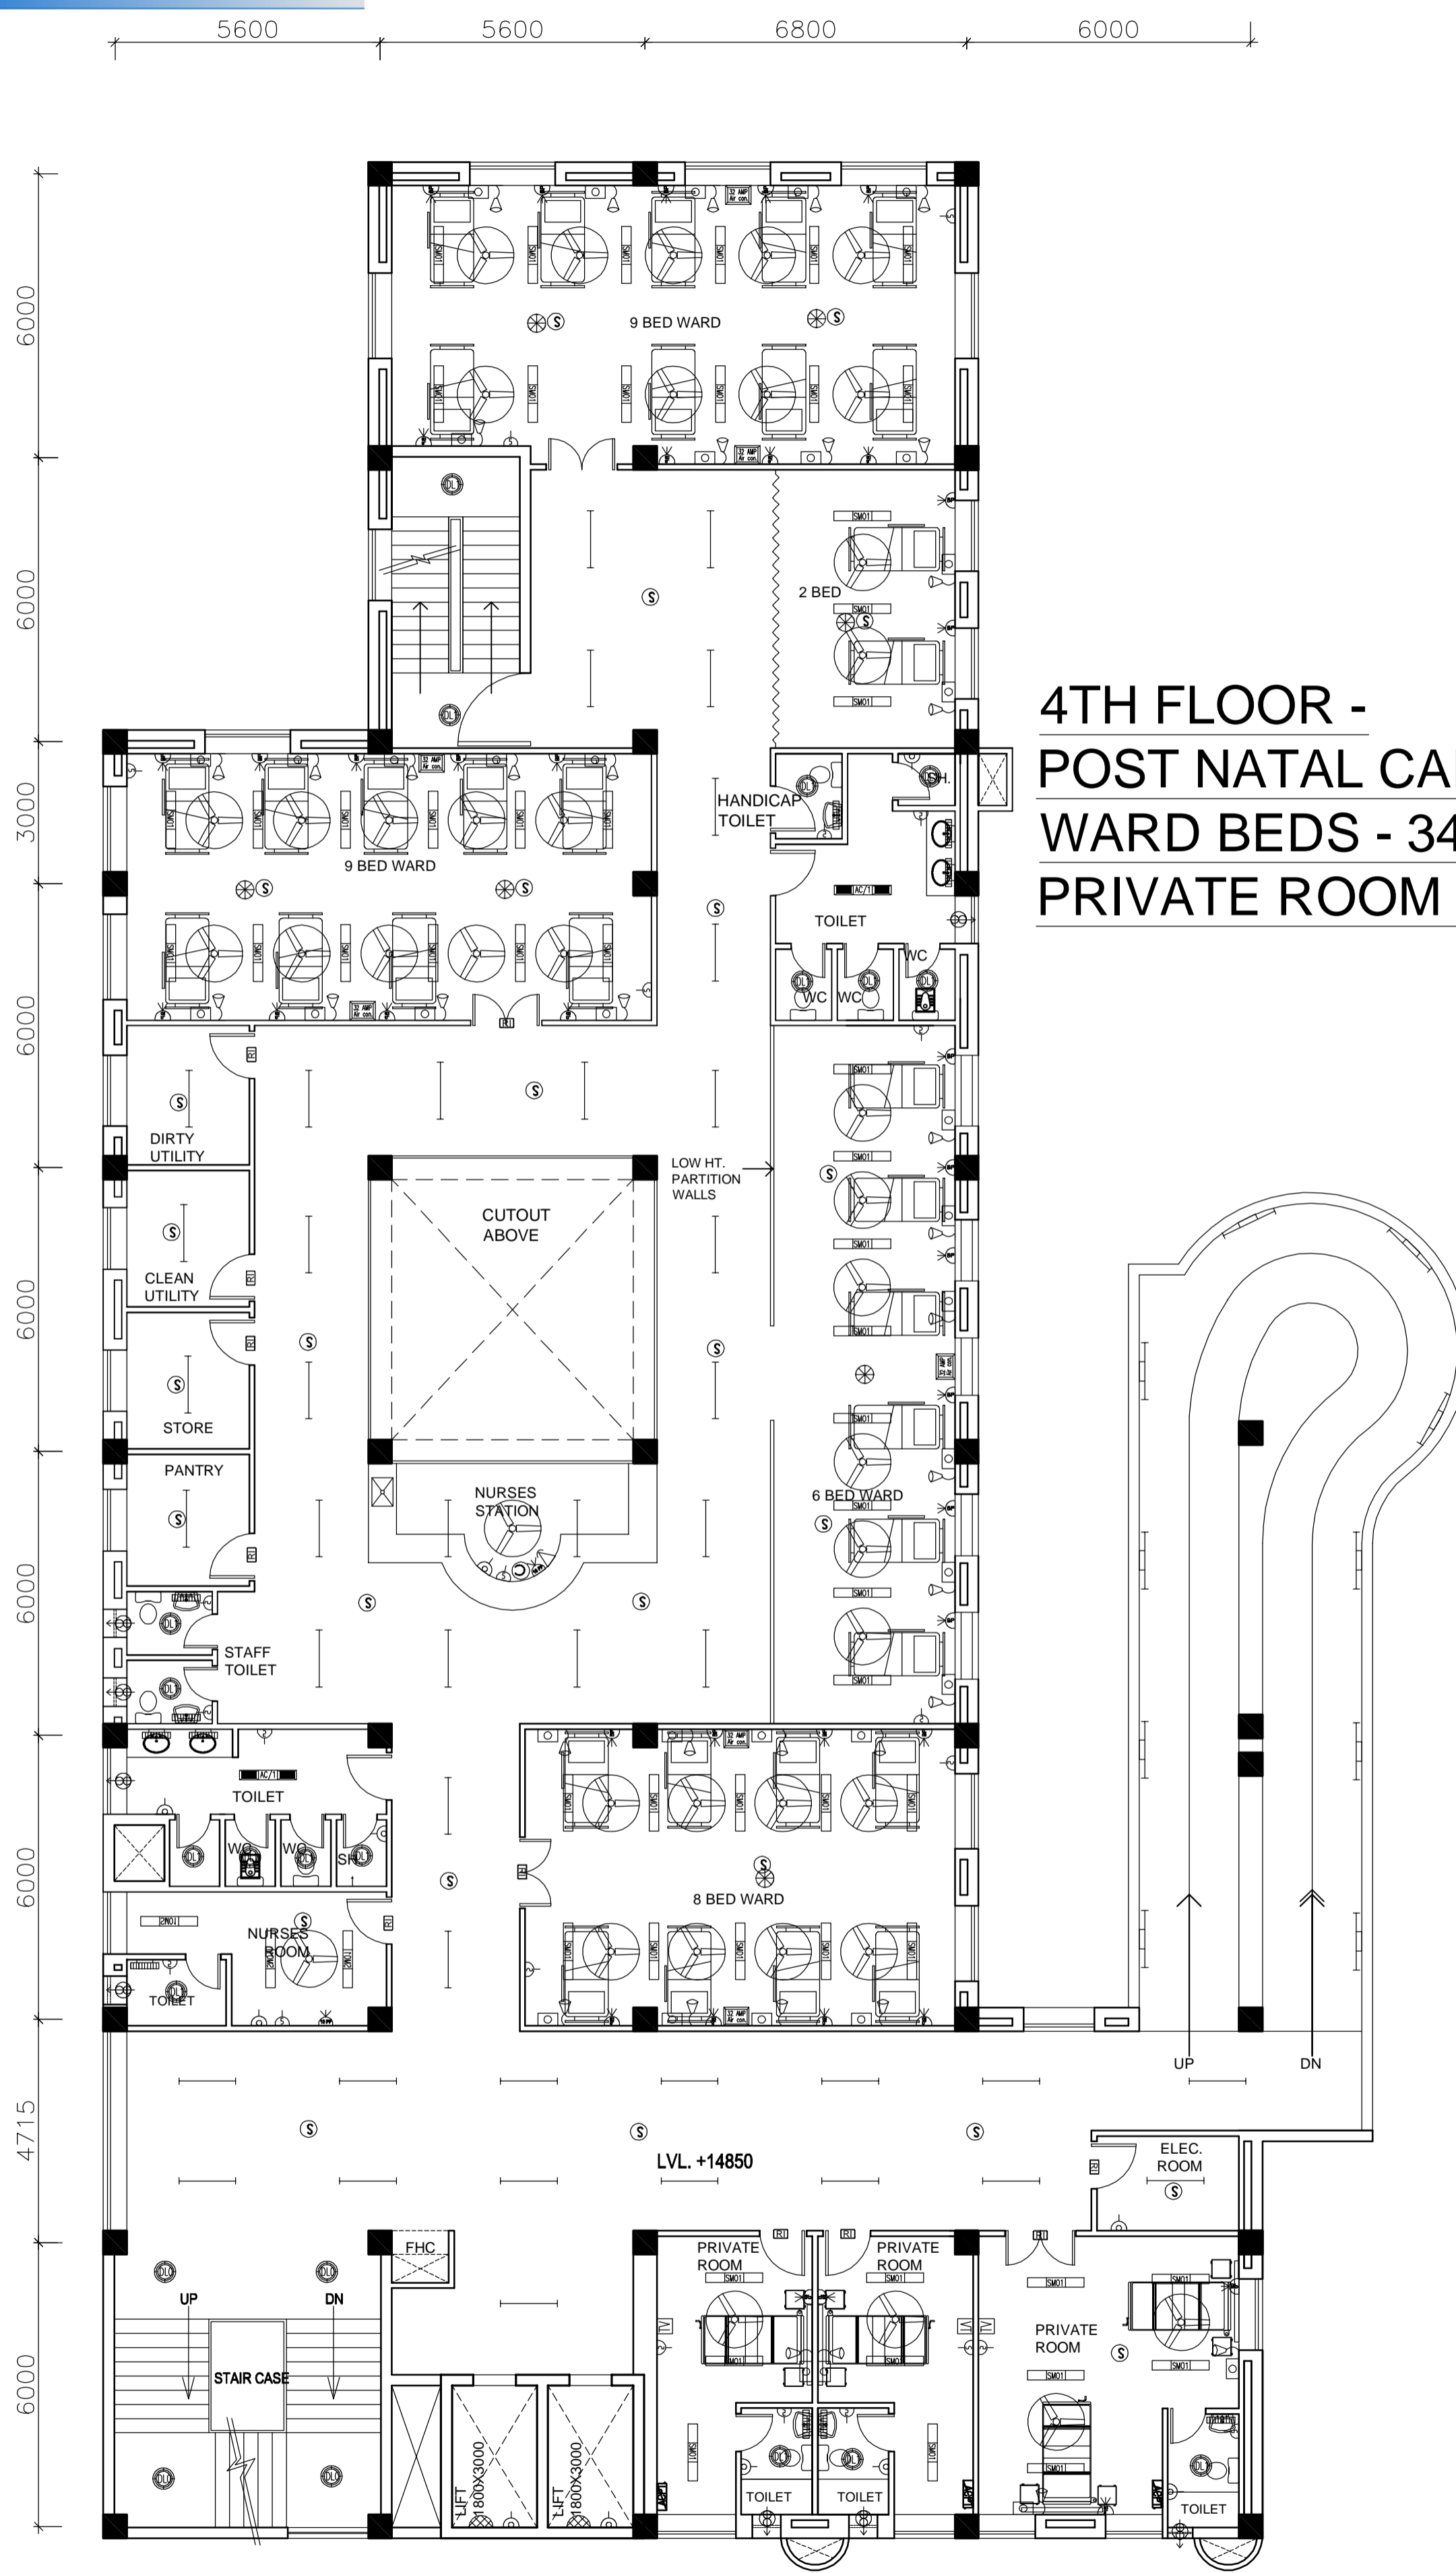

**4TH FLOOR -
 POST NATAL CARE
 WARD BEDS - 34 NO.
 PRIVATE ROOM - 4 BEDS**

REVISION - 01
 REVISED AS PER THE GUIDELINES OF VETTING COMMITTEE

PROJECT
 PROPOSED
 100 BEDDED HOSPITAL
 MUJAFFARNAGAR

TITLE
 TENDER DRAWING
 FOURTH FLOOR PLAN
 AREA - 929 SQM

ELECTRICAL LAYOUT

HSCC/TD/MUJAFFARNAGAR/EL-105
 Drawing No. Rev. - 01

Job No.	Scale	Date
App by	Rev. by	Prep. by