


5TH FLOOR

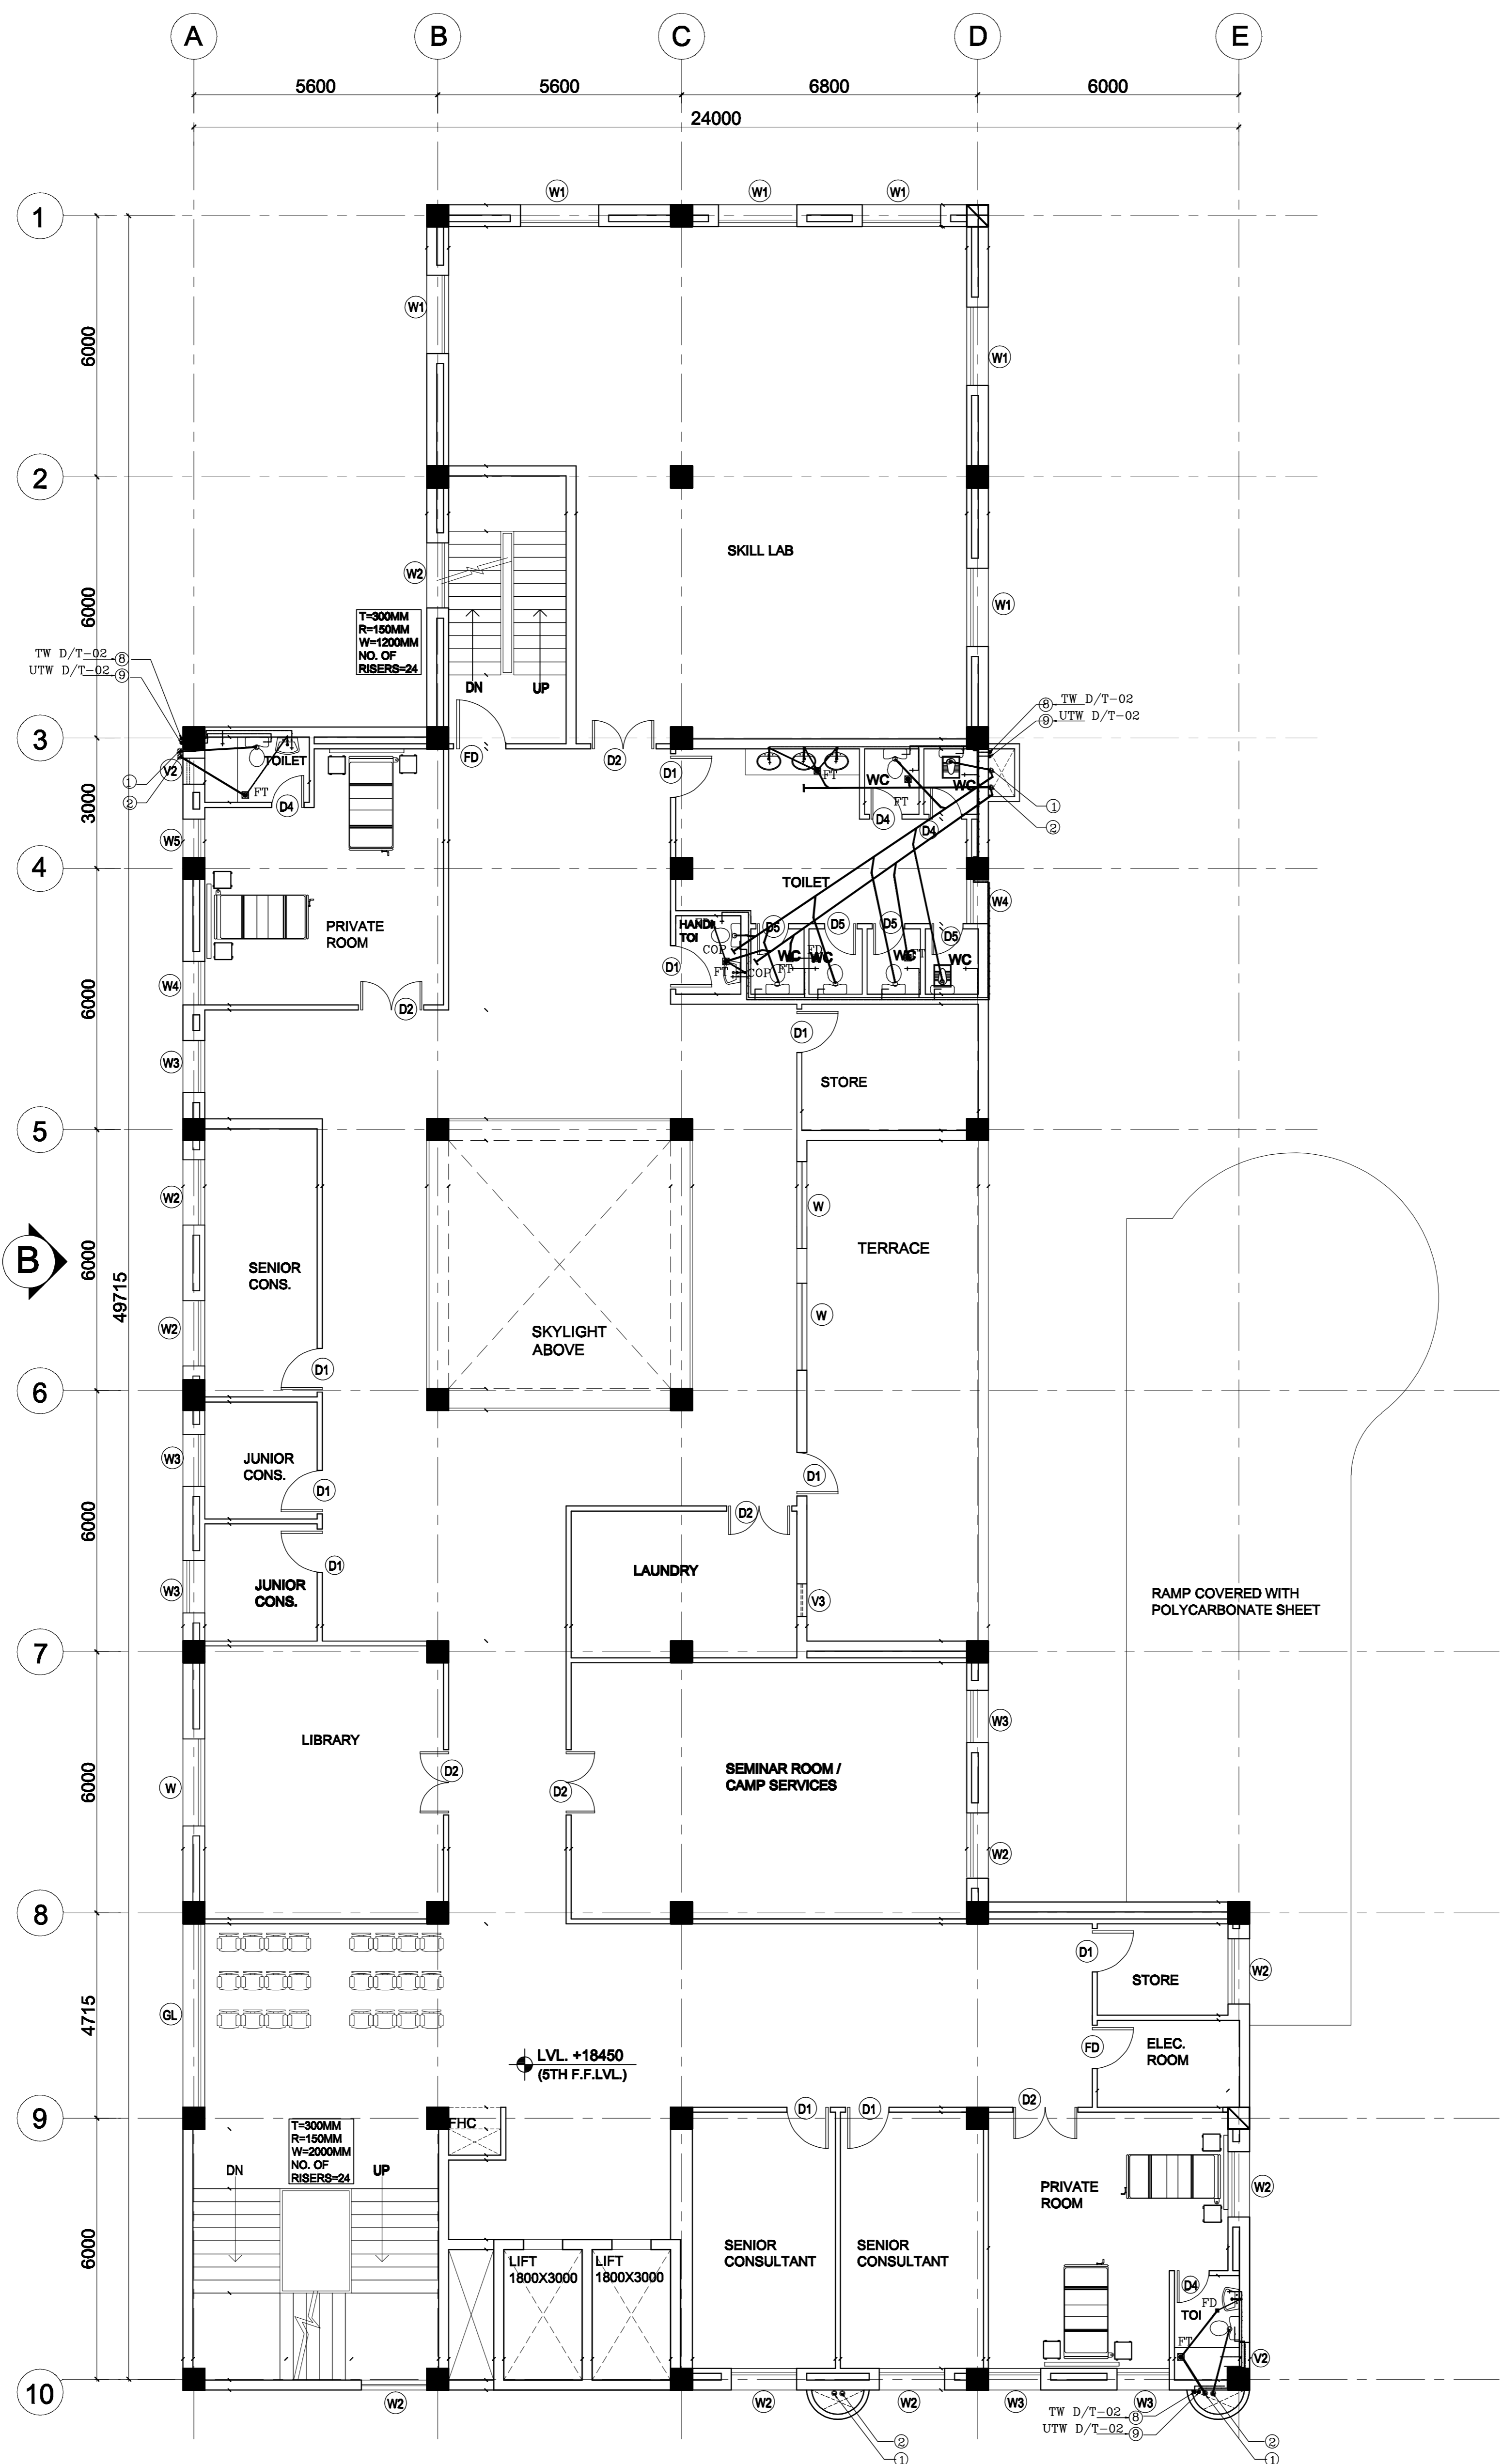

This drawing with all its contents is the sole intellectual property of the Hospital Services Consulting Corporation (HSCC) and shall not be used, copied, reproduced, or otherwise disseminated without the written permission of HSCC as prohibited.

NORTH

LEGEND:

- 1 100 Ø CI SOIL & VENT PIPE
- 2 100Ø CLWASTE & VENT PIPE
- 3 100Ø CI SOIL PIPE
- 4 100Ø CI WASTE PIPE
- 5 50Ø UPVC SOIL PIPE
- 6 40Ø UPVC WASTE PIPE
- 7 32Ø UPVC WASTE PIPE
- 8 TW DN / TAKE
- 9 UTW DN / TAKE
- 150 Ø S.W. PIPE
- F.1 FLOOR TRAP 100X100
- F.D FLOOR DRAIN 50Ø
- FCO FLOOR CLEAN OUT VALVE
- MH MANHOLE (900X800)mm
- GI GULLY TRAP (300X300)mm

PROJECT

PROPOSED
100 BEDED
HOSPITAL
MUJAFARNAGAR
(UP)

TITLE PLUMBING
TENDER DRAWING


FIFTH FLOOR PLAN

HSCC/D&E/M/HS/TD/PL-06
Drawing No.

Job No.	Scale	Date

App by	Rev. by	Prep. by

HSCC (INDIA) LIMITED
(A GOVERNMENT OF INDIA ENTERPRISE)
HSCC
NEW DELHI INDIA

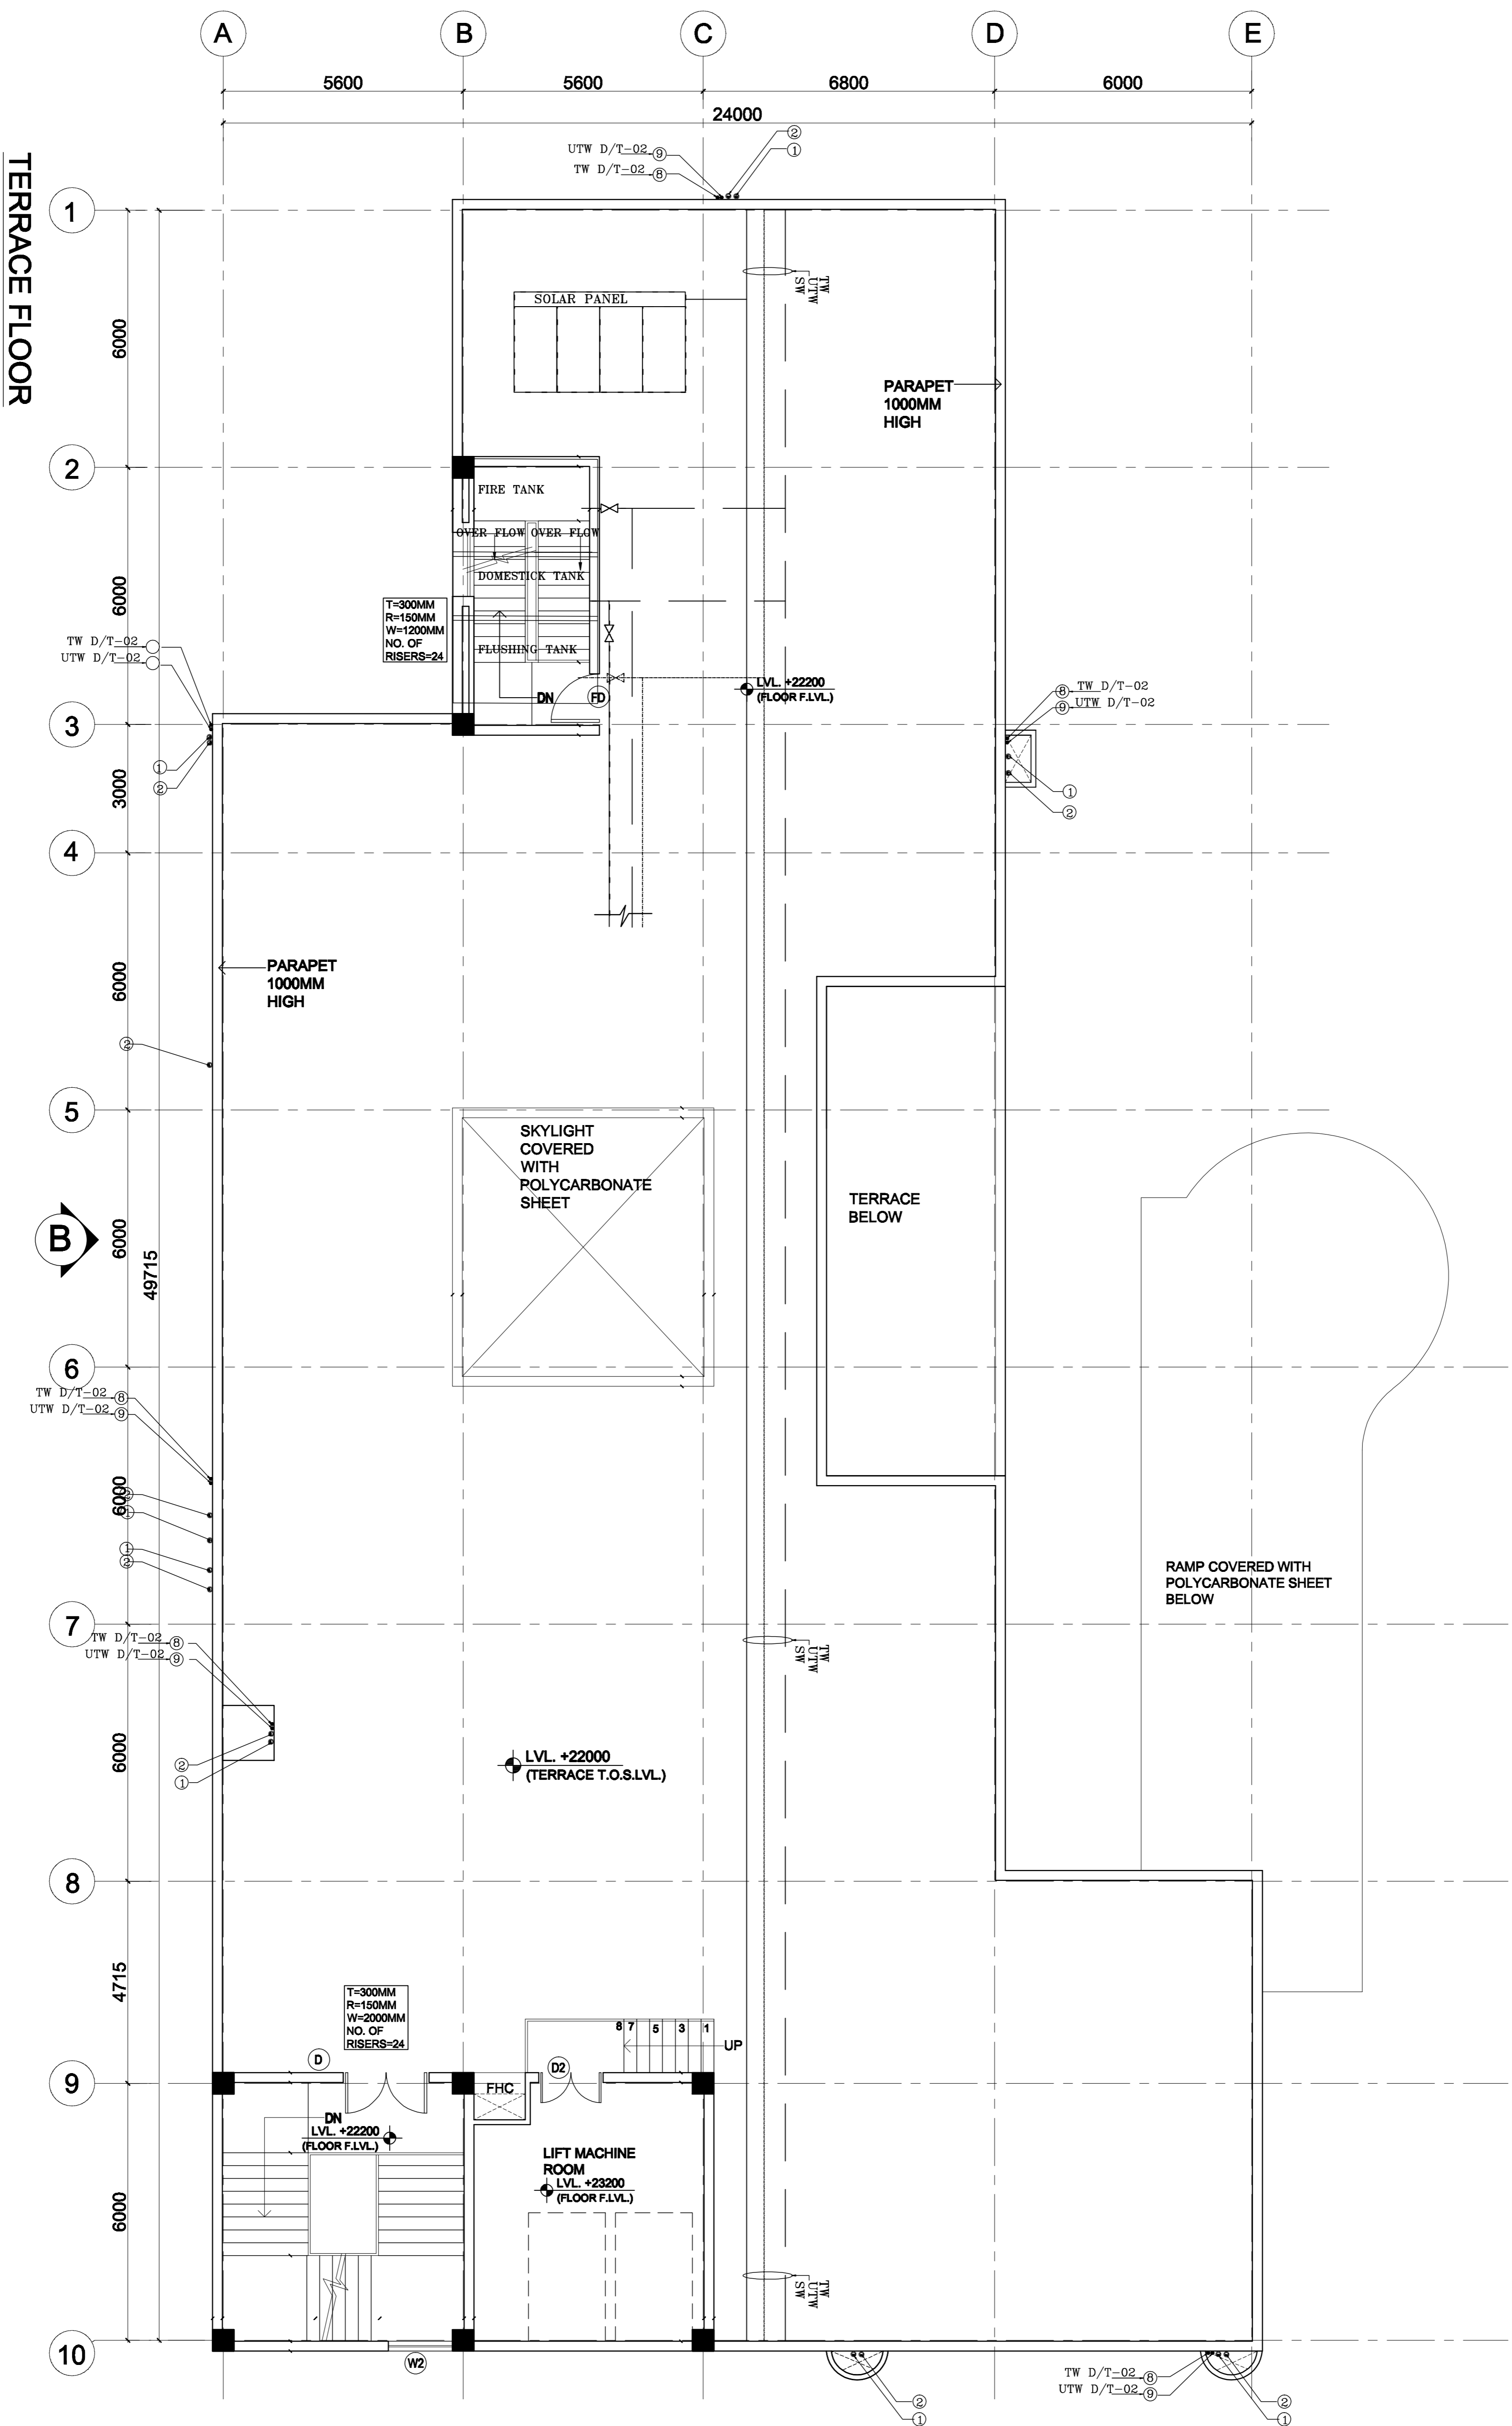

This drawing with all its contents is the sole intellectual property of the Hospital Services Consulting Corporation (HSCC) and shall not be used for any other drawing or part thereof for its use in any form whatsoever without the written permission of HSCC is prohibited.

NORTH

LEGEND:

1	100 Ø CI SOIL & VENT PIPE
2	100Ø CLWASTE & VENT PIPE
3	100Ø CI. SOIL PIPE
4	100Ø CI. WASTE PIPE
5	50Ø uPVC SOIL PIPE
6	40Ø uPVC WASTE PIPE
7	32Ø uPVC WASTE PIPE
8	TW DN / TAKE
9	UTW DN / TAKE
F.1	150 Ø S.W. PIPE
F.D	FLOOR TRAP 100X100
FCO	FLOOR DRAIN 50Ø
X	FLOOR CLEAN OUT VALVE
MH	MANHOLE (900X800)mm
GT	GULLY TRAP (300X300)mm

PROJECT

**PROPOSED
100 BEDEDDED
HOSPITAL
MUJAFARNAGAR
(UP)**

**TITLE PLUMBING
TENDER DRAWING**

FIRST FLOOR PLAN

HSCCD&E/M/HS/TD/PL-07			
Drawing No.			
Job No.	Scale	Date	
App by	Rev. by	Prep. by	

HSCC (INDIA) LIMITED
(A GOVERNMENT OF INDIA ENTERPRISE)
HSCC
NEW DELHI INDIA

NOTES

1. DRAWINGS TO BE READ NOT MEASURED
2. PARTITION WALL IN TOILETS UP TO LINTEL HEIGHT

REVISION - 01
REVISED AS PER THE GUIDELINES OF VETTING COMMITTEE

PROJECT


PROPOSED
100 BEDDED HOSPITAL
MUJAFFARNAGAR

TITLE

TENDER DRAWING
GROUND FLOOR PLAN
AREA - 1067.29 SQM
ELECTRICAL LAYOUT


HSCC/TD/MUJAFFARNAGAR/EL-101
Drawing No. Rev. - 01

Job No.	NTS Scale	Date
App by	Rev. by	Prep. by

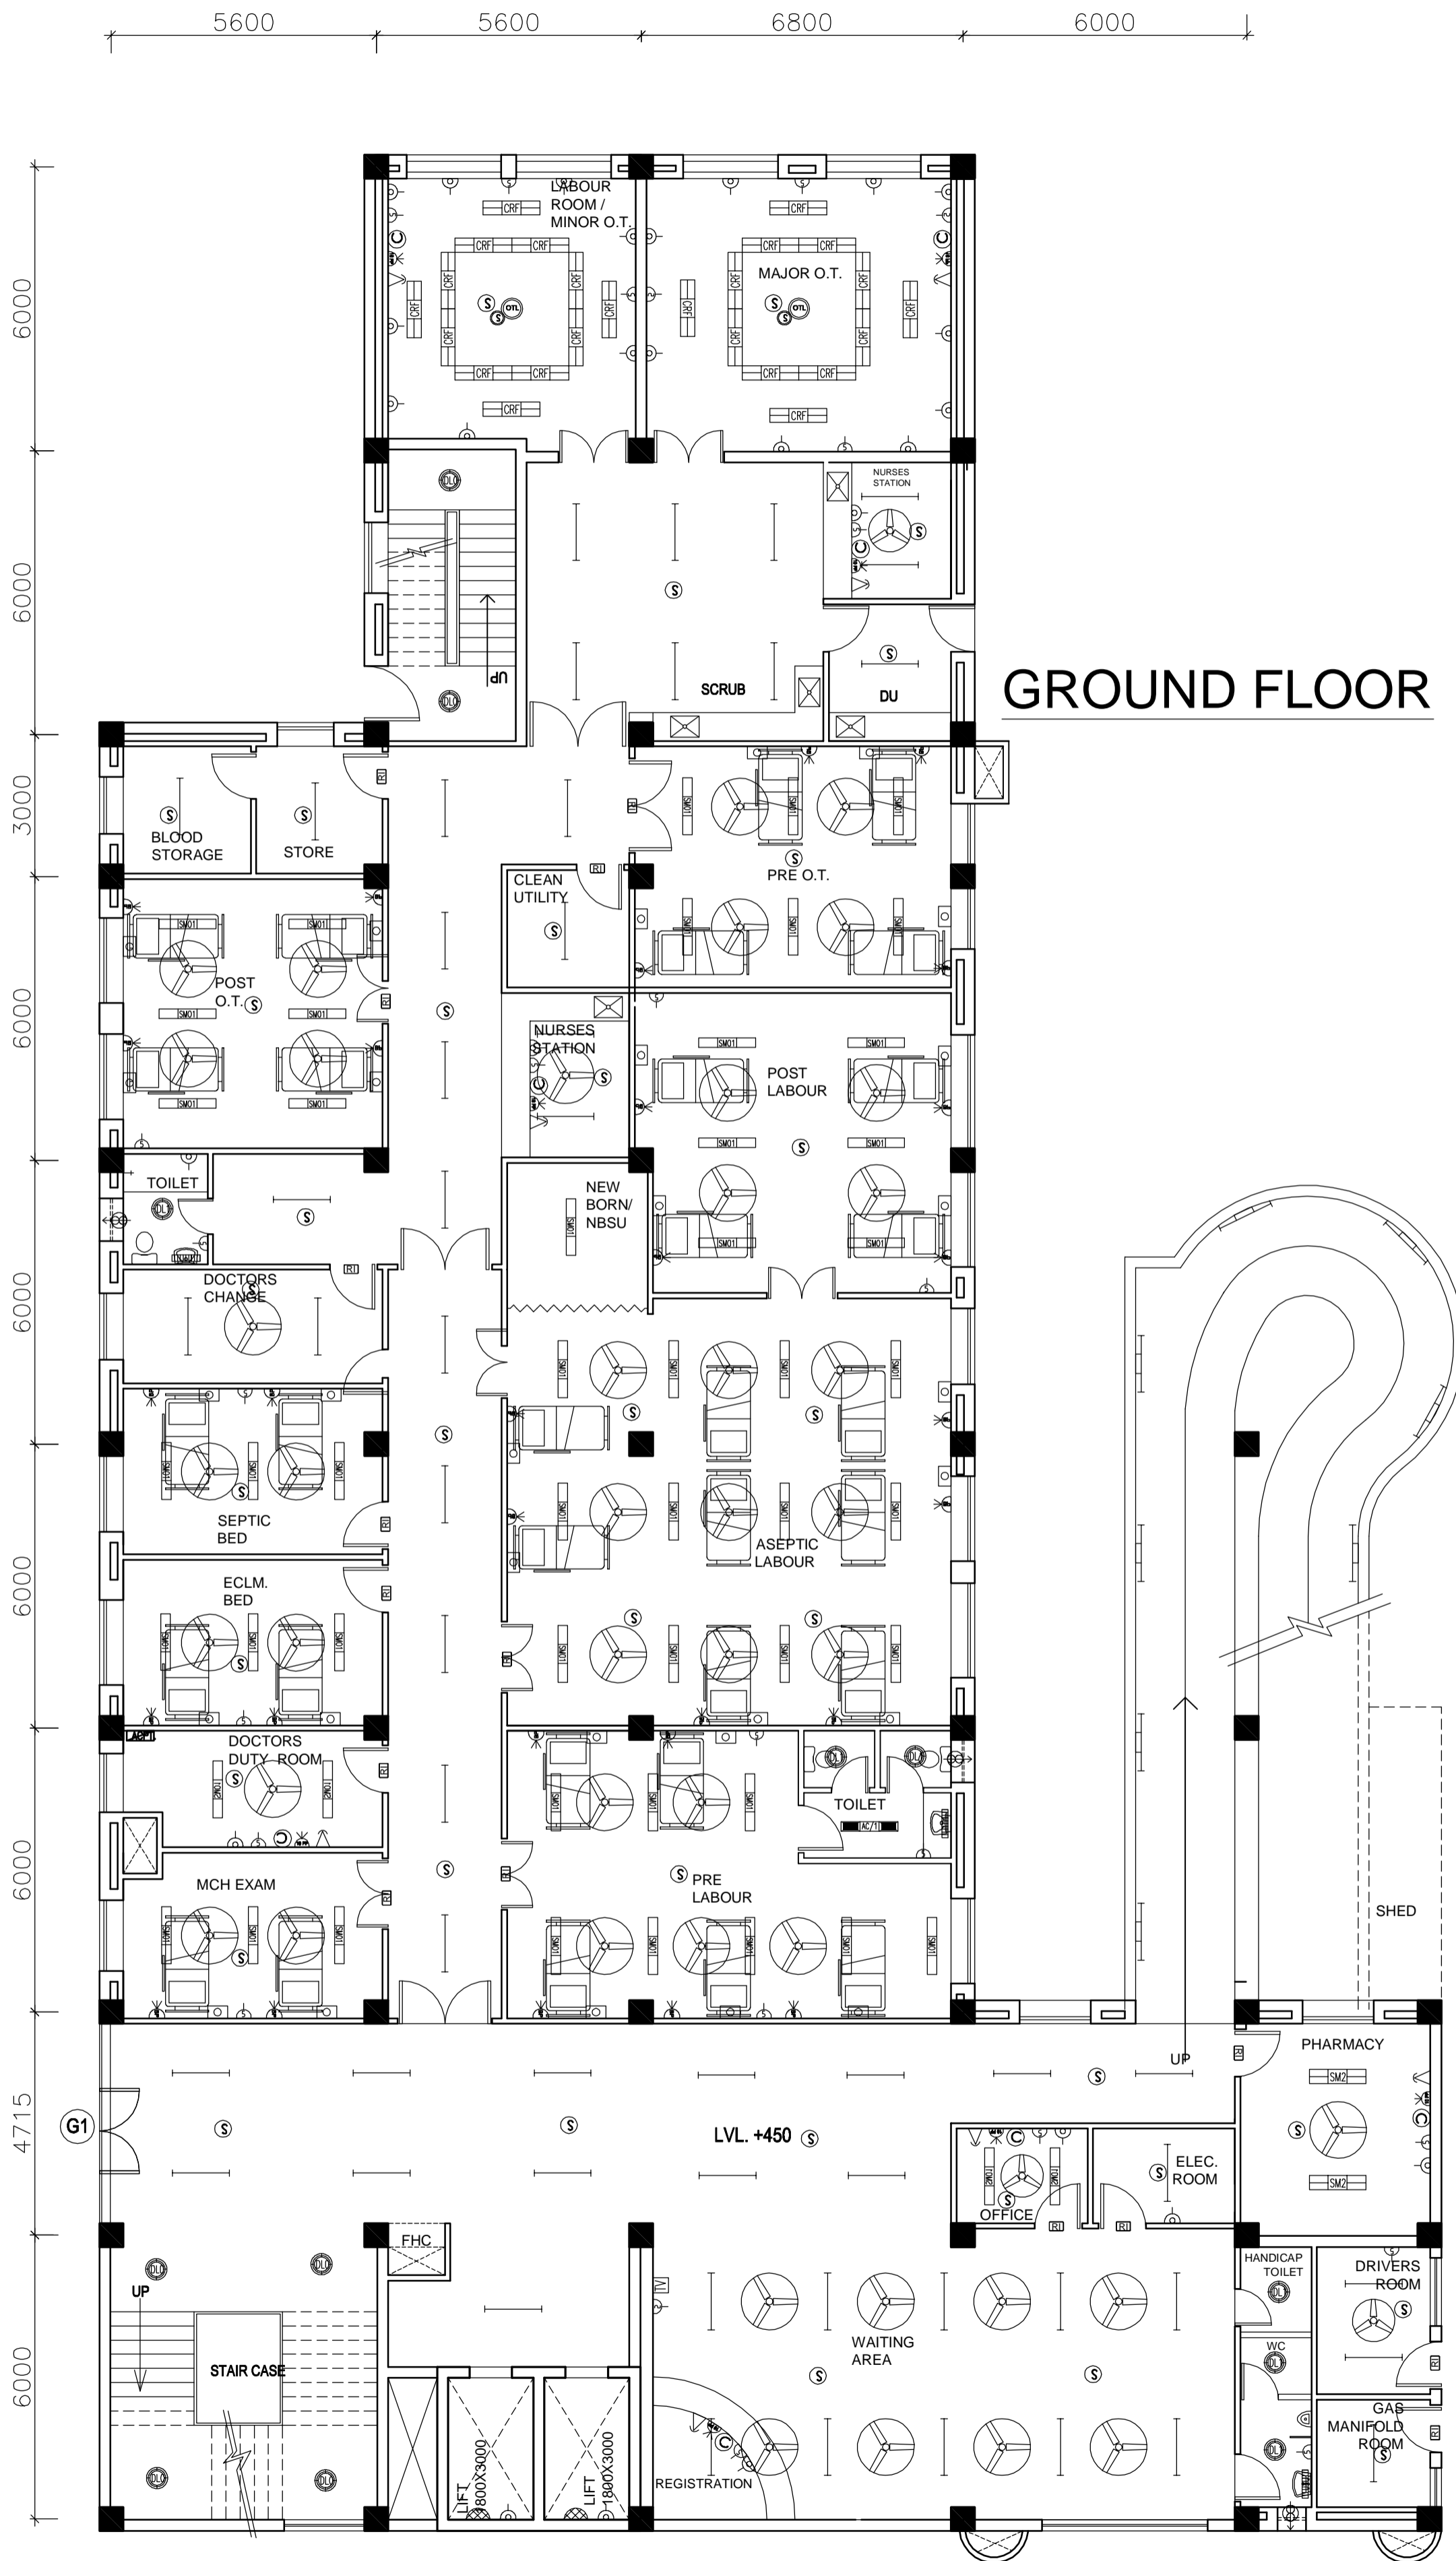

GROUND FLOOR

- NOTES**
1. DRAWINGS TO BE READ NOT MEASURED
 2. PARTITION WALL IN TOILETS UP TO LINTEL HEIGHT

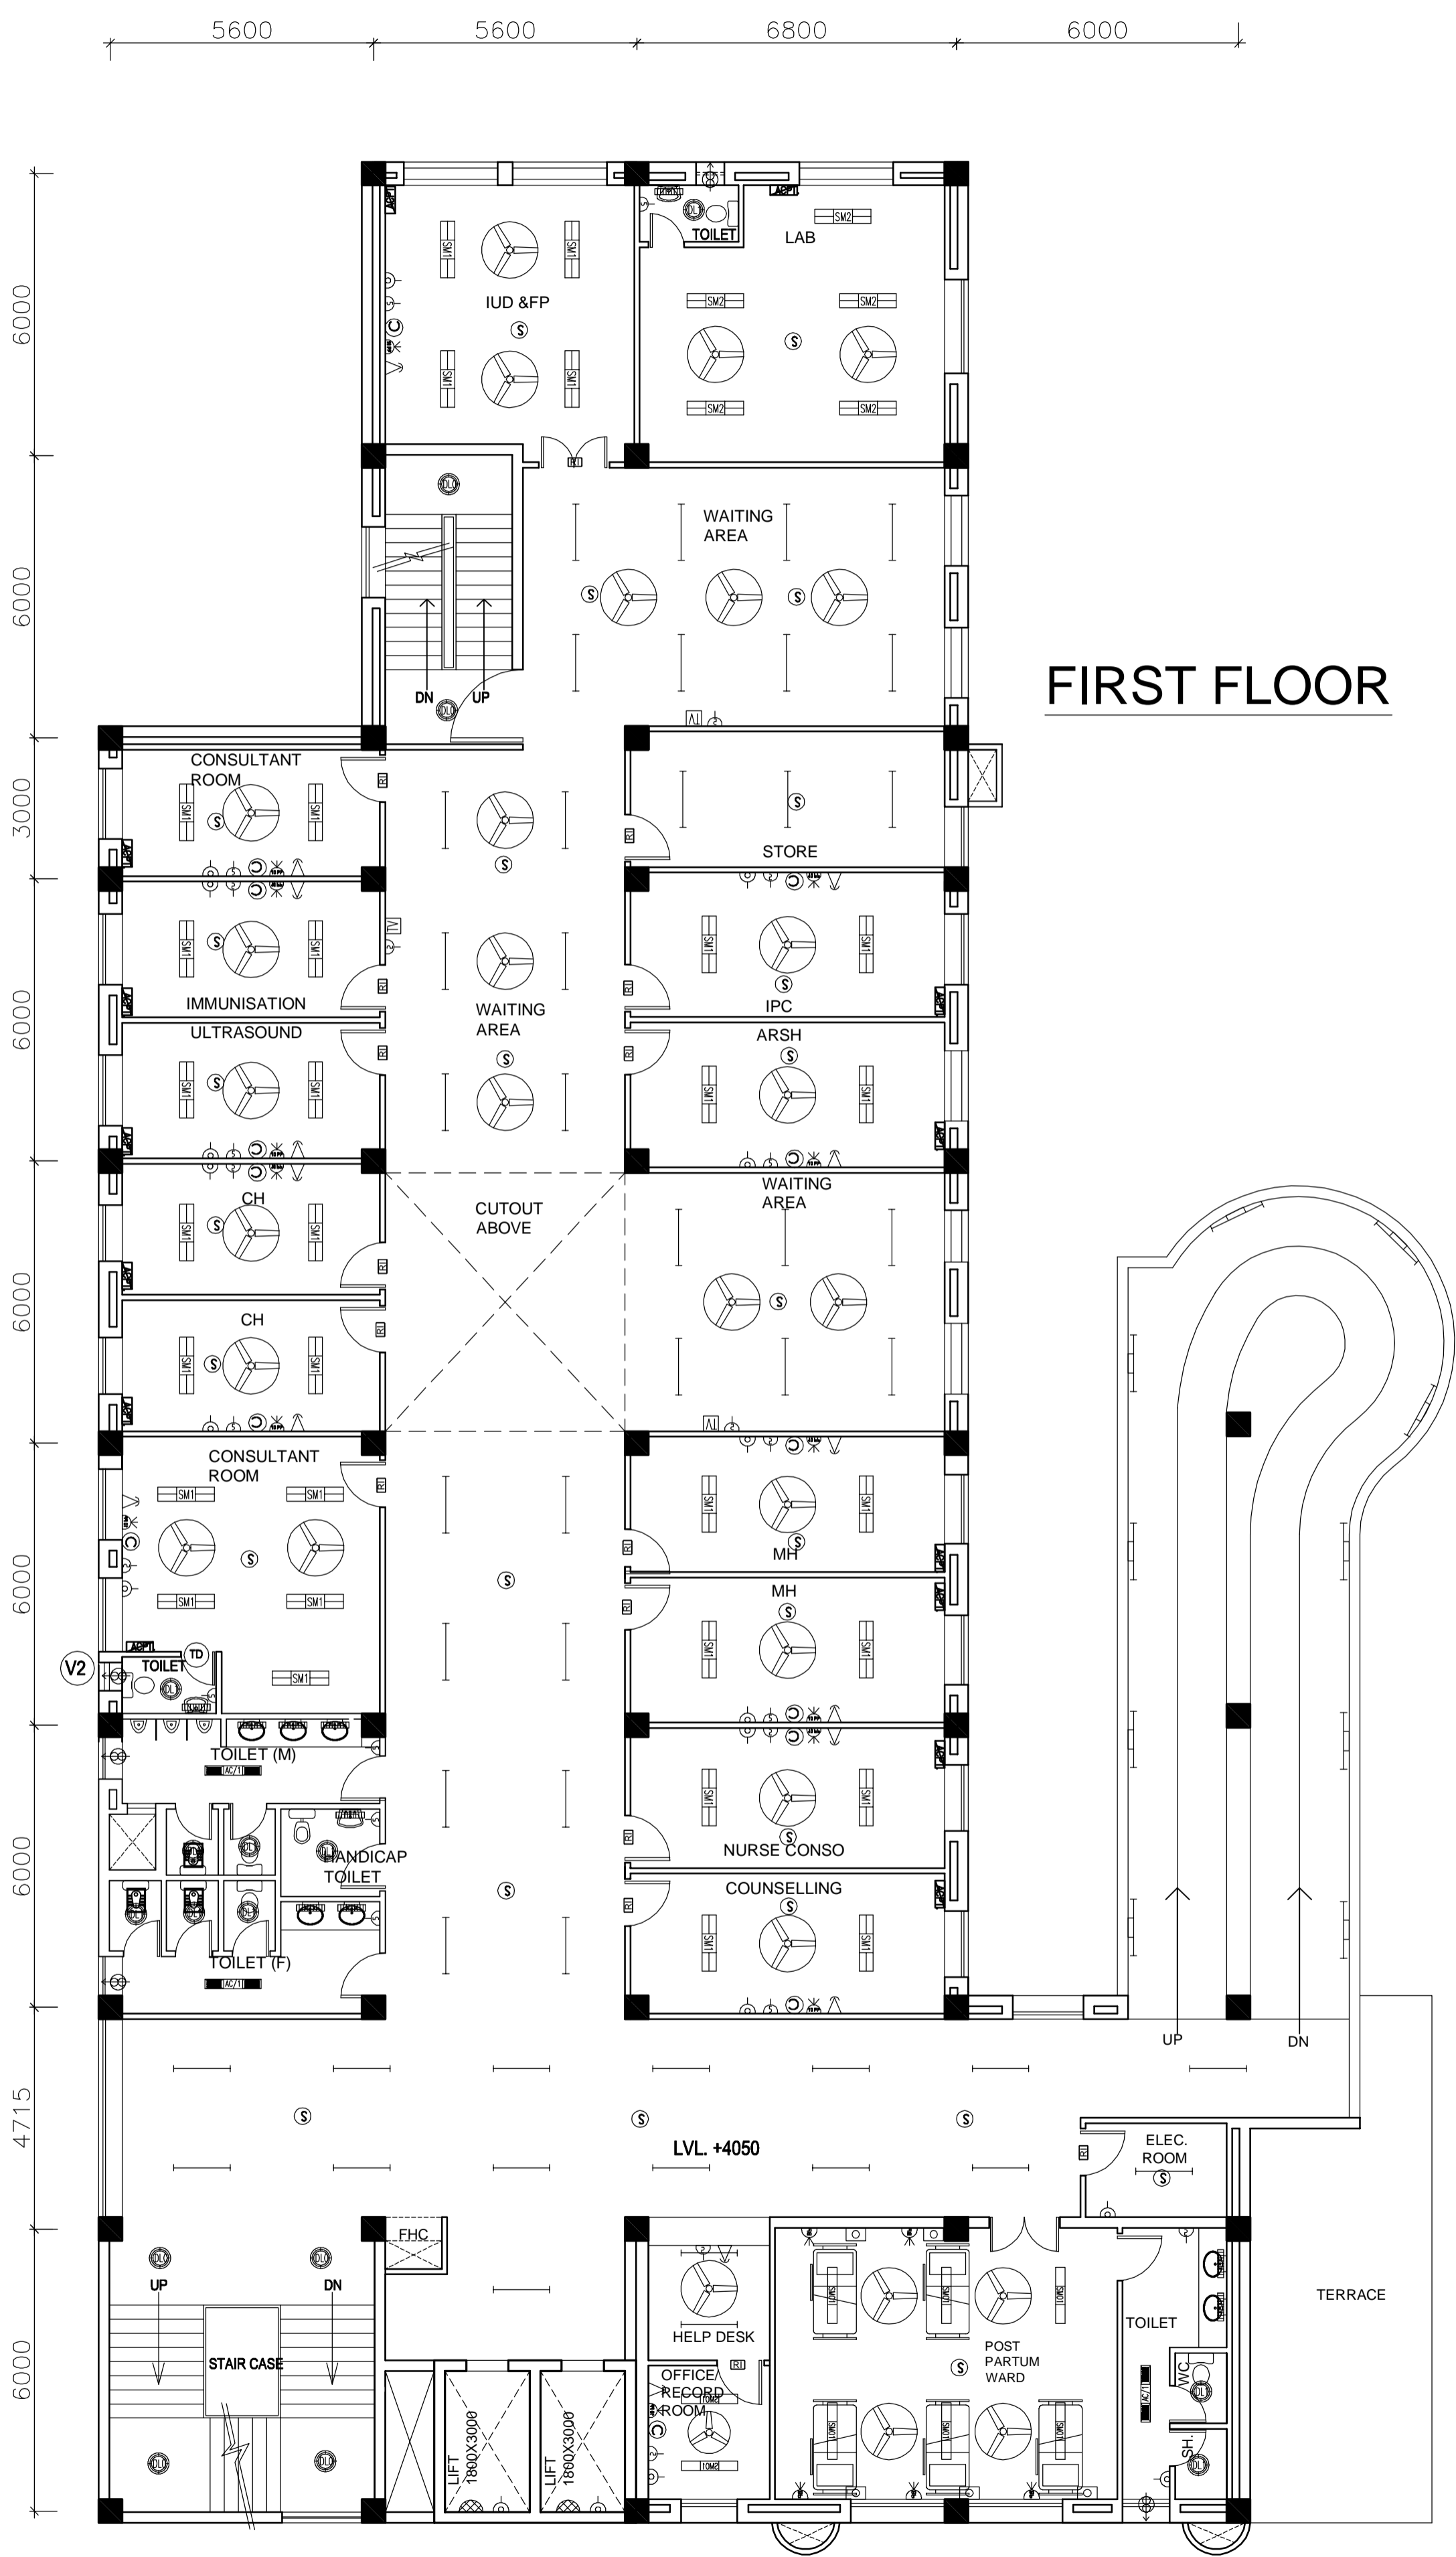

FIRST FLOOR

REVISION - 01
 REVISED AS PER THE GUIDELINES OF VETTING COMMITTEE

PROJECT
 PROPOSED
 100 BEDDED HOSPITAL
 MUJAFFARNAGAR

TITLE
 TENDER DRAWING
 FIRST FLOOR PLAN
 AREA - 1030.59 SQM

ELECTRICAL LAYOUT

HSCC/TD/MUJAFFARNAGAR/EL-102
 Drawing No. Rev. - 01

Job No.	Scale	Date
App by	Rev. by	Prep. by