

3RD FLOOR - ANTE NATAL CARE
WARD BEDS - 30 NO.
OBSTETRIC ICU - 5 BEDS
PRIVATE ROOM - 2 BEDS

NORTH

This drawing with all its contents is the sole intellectual property of the Hospital Services Consulting Corporation (HSCC) and shall not be used for any other drawing or part thereof for its use in any form whatsoever without the written permission of HSCC is prohibited.

LEGEND:

1	100 Ø CI SOIL & VENT PIPE
2	100Ø CLWASTE & VENT PIPE
3	100Ø CI SOIL PIPE
4	100Ø CI WASTE PIPE
5	50Ø uPVC SOIL PIPE
6	40Ø uPVC WASTE PIPE
7	32Ø uPVC WASTE PIPE
8	TW DN / TAKE
9	UTW DN / TAKE
F.T	FLOOR TRAP 100X100
F.D	FLOOR DRAIN 50Ø
FCO	FLOOR CLEAN OUT
X	VALVE
MH	MANHOLE (900X800)mm
GT	GULLY TRAP (300X300)mm

PROJECT


**PROPOSED
 100 BEDED
 HOSPITAL
 PLIBHIT
 (UP)**

**TITLE PLUMBING
 TENDER DRAWING**

THIRD FLOOR PLAN

HSCC/DAE/PT/HS/TTD/PL-04		
Drawing No.		
Job No.	Scale	Date
App by	Rev. by	Prep. by



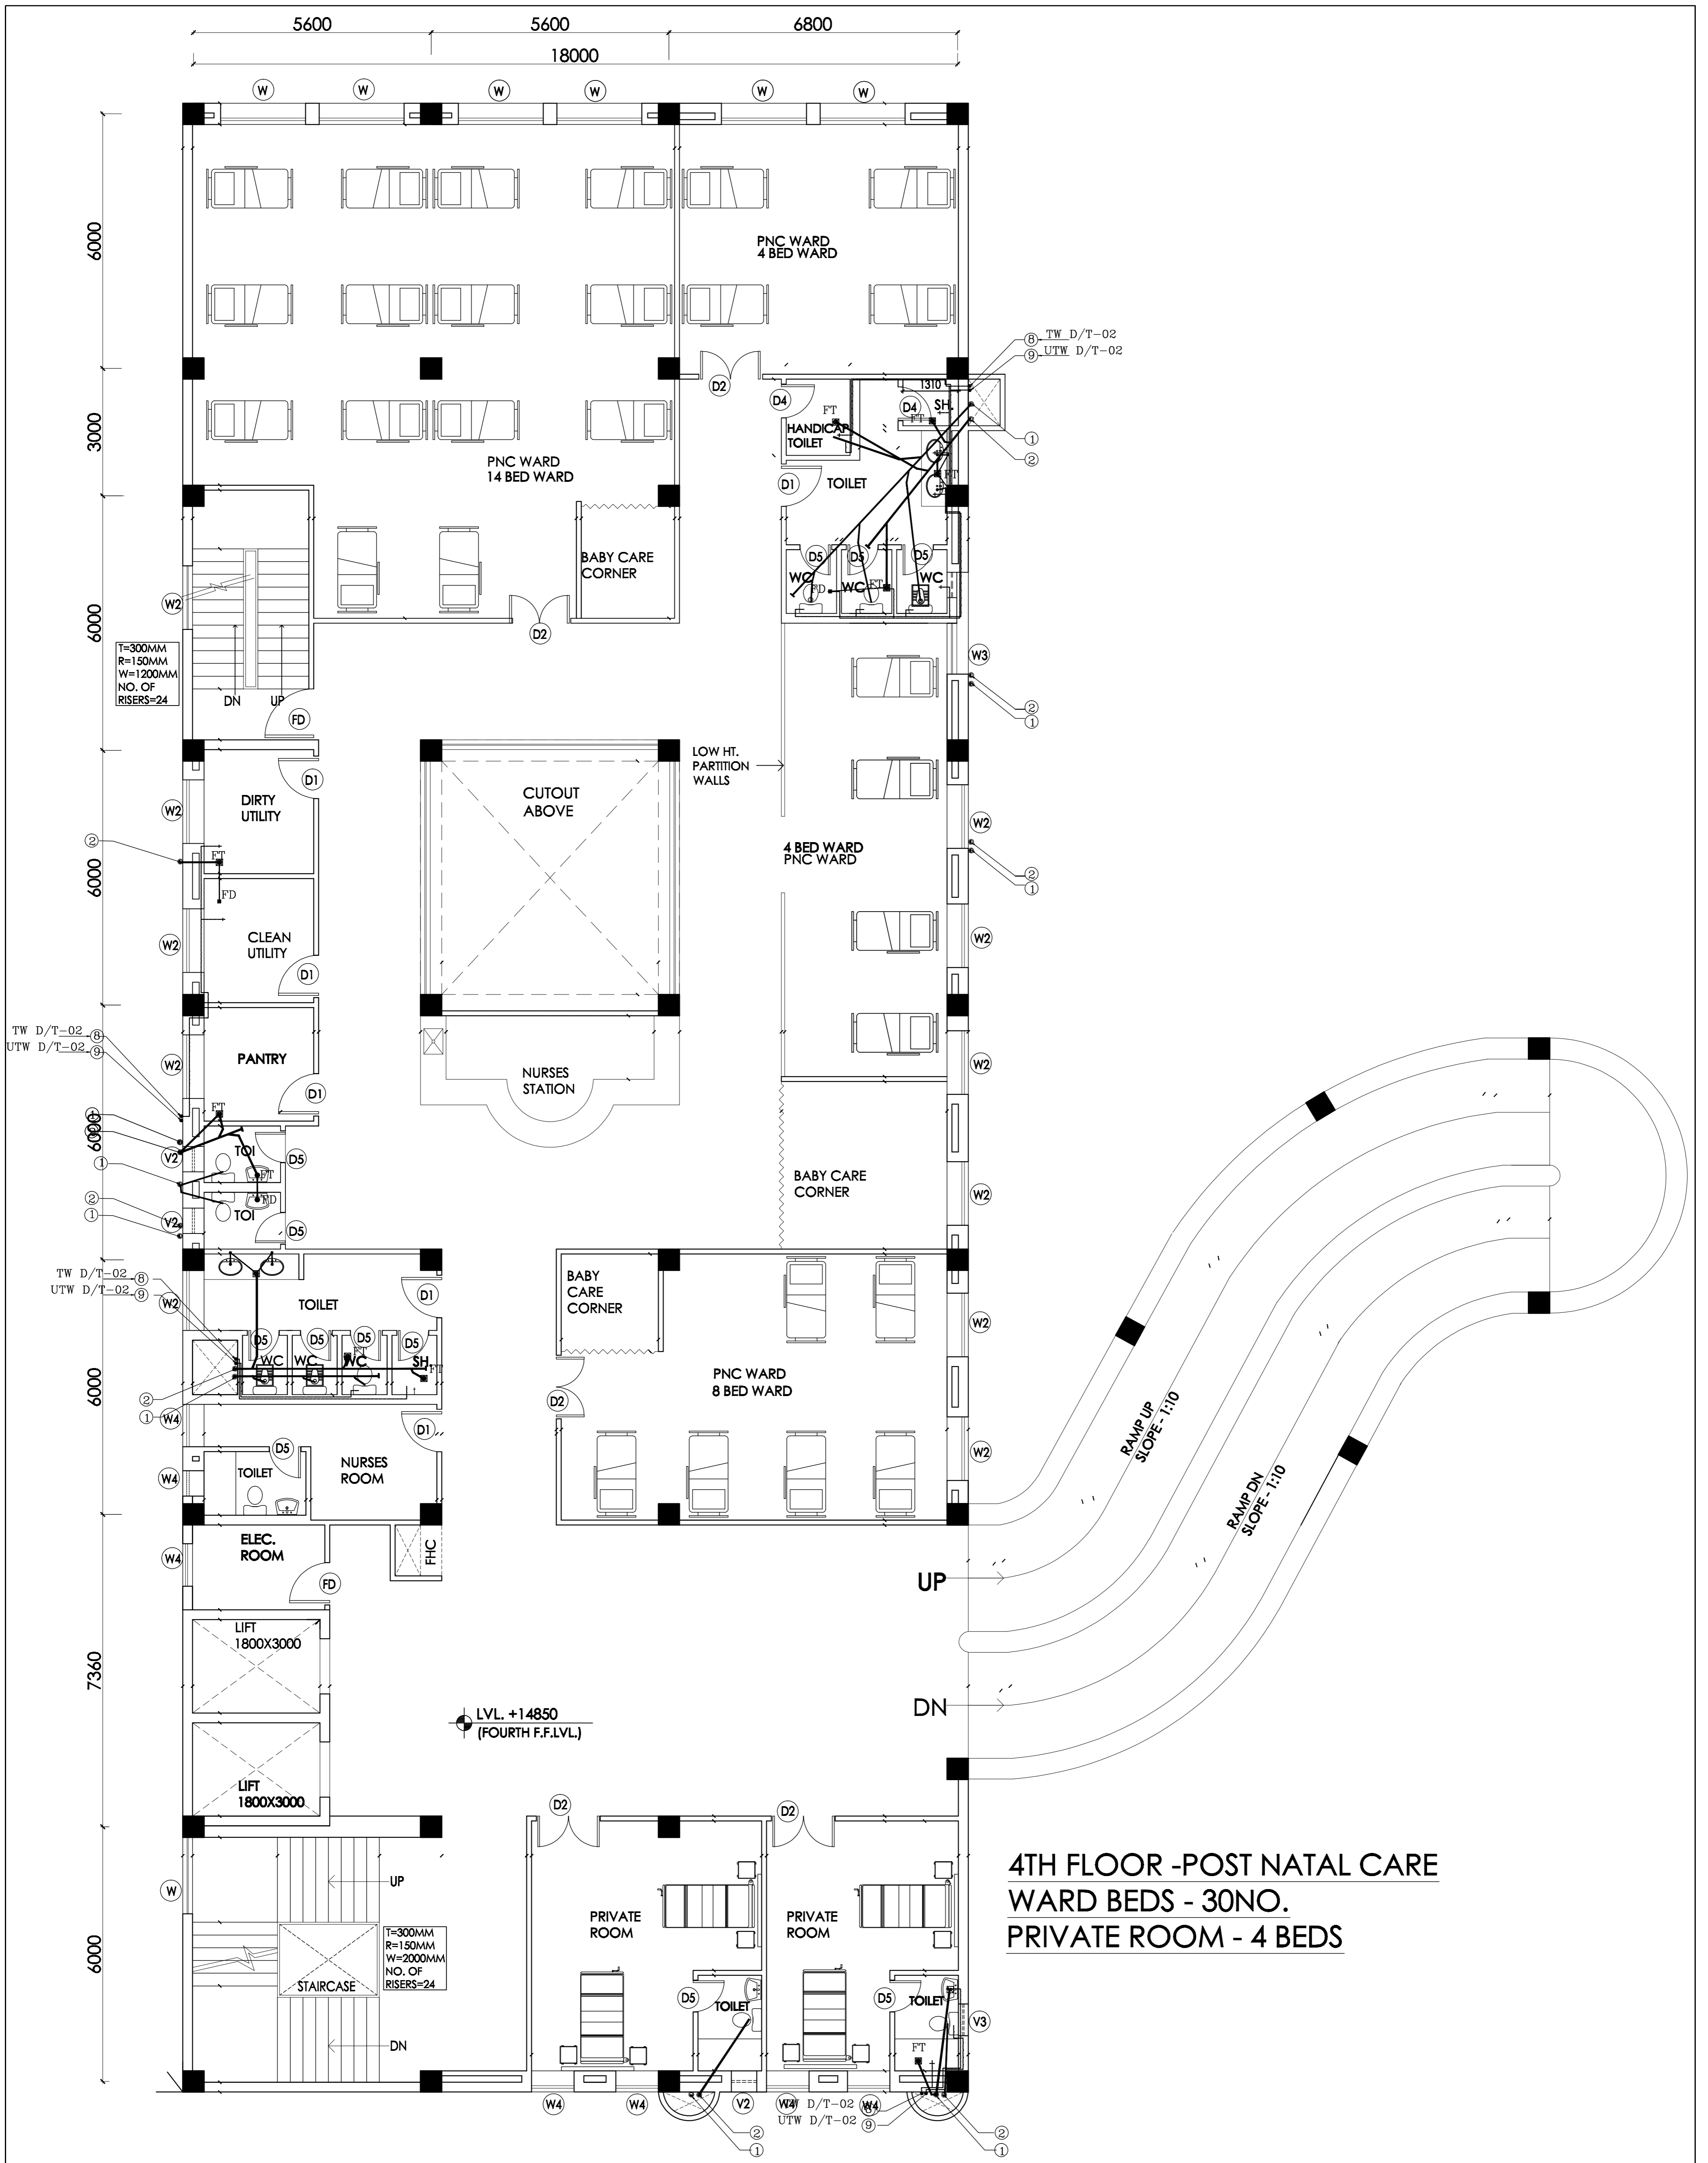

4TH FLOOR -POST NATAL CARE
WARD BEDS - 30NO.
PRIVATE ROOM - 4 BEDS

NORTH

This drawing with all its contents is the sole intellectual property of the Hospital Services Consulting Corporation (HSCC) and shall remain the property of HSCC. No part of this drawing or part thereof shall be used in any form whatsoever without the written permission of HSCC is prohibited.

LEGEND:

1	100 Ø CI SOIL & VENT PIPE
2	100Ø CLWASTE & VENT PIPE
3	100Ø CI SOIL PIPE
4	100Ø CI WASTE PIPE
5	50Ø uPVC SOIL PIPE
6	40Ø uPVC WASTE PIPE
7	32Ø uPVC WASTE PIPE
8	TW DN / TAKE
9	UTW DN / TAKE
F.1	150 Ø S.W. PIPE
F.D	FLOOR TRAP 100X100
FCO	FLOOR DRAIN 50Ø
FC	FLOOR CLEAN OUT
X	VALVE
MH	MANHOLE (900X800)mm
GT	GULLY TRAP(300X300)mm

PROJECT

**PROPOSED
100 BEDED
HOSPITAL
PLIBHIT
(UP)**

**TITLE PLUMBING
TENDER DRAWING**

FOURTH FLOOR PLAN

HSCC/DAE/PS/HS/TD/PL-05	
Drawing No.	
Job No.	Scale
App by	Rev. by
	Prep. by
	Date

HSCC (INDIA) LIMITED
(A GOVERNMENT OF INDIA ENTERPRISE)
HSCC
NEW DELHI INDIA