


NOTES

1. DRAWINGS TO BE READ NOT MEASURED
2. PARTITION WALL IN TOILETS UP TO LINTEL HEIGHT

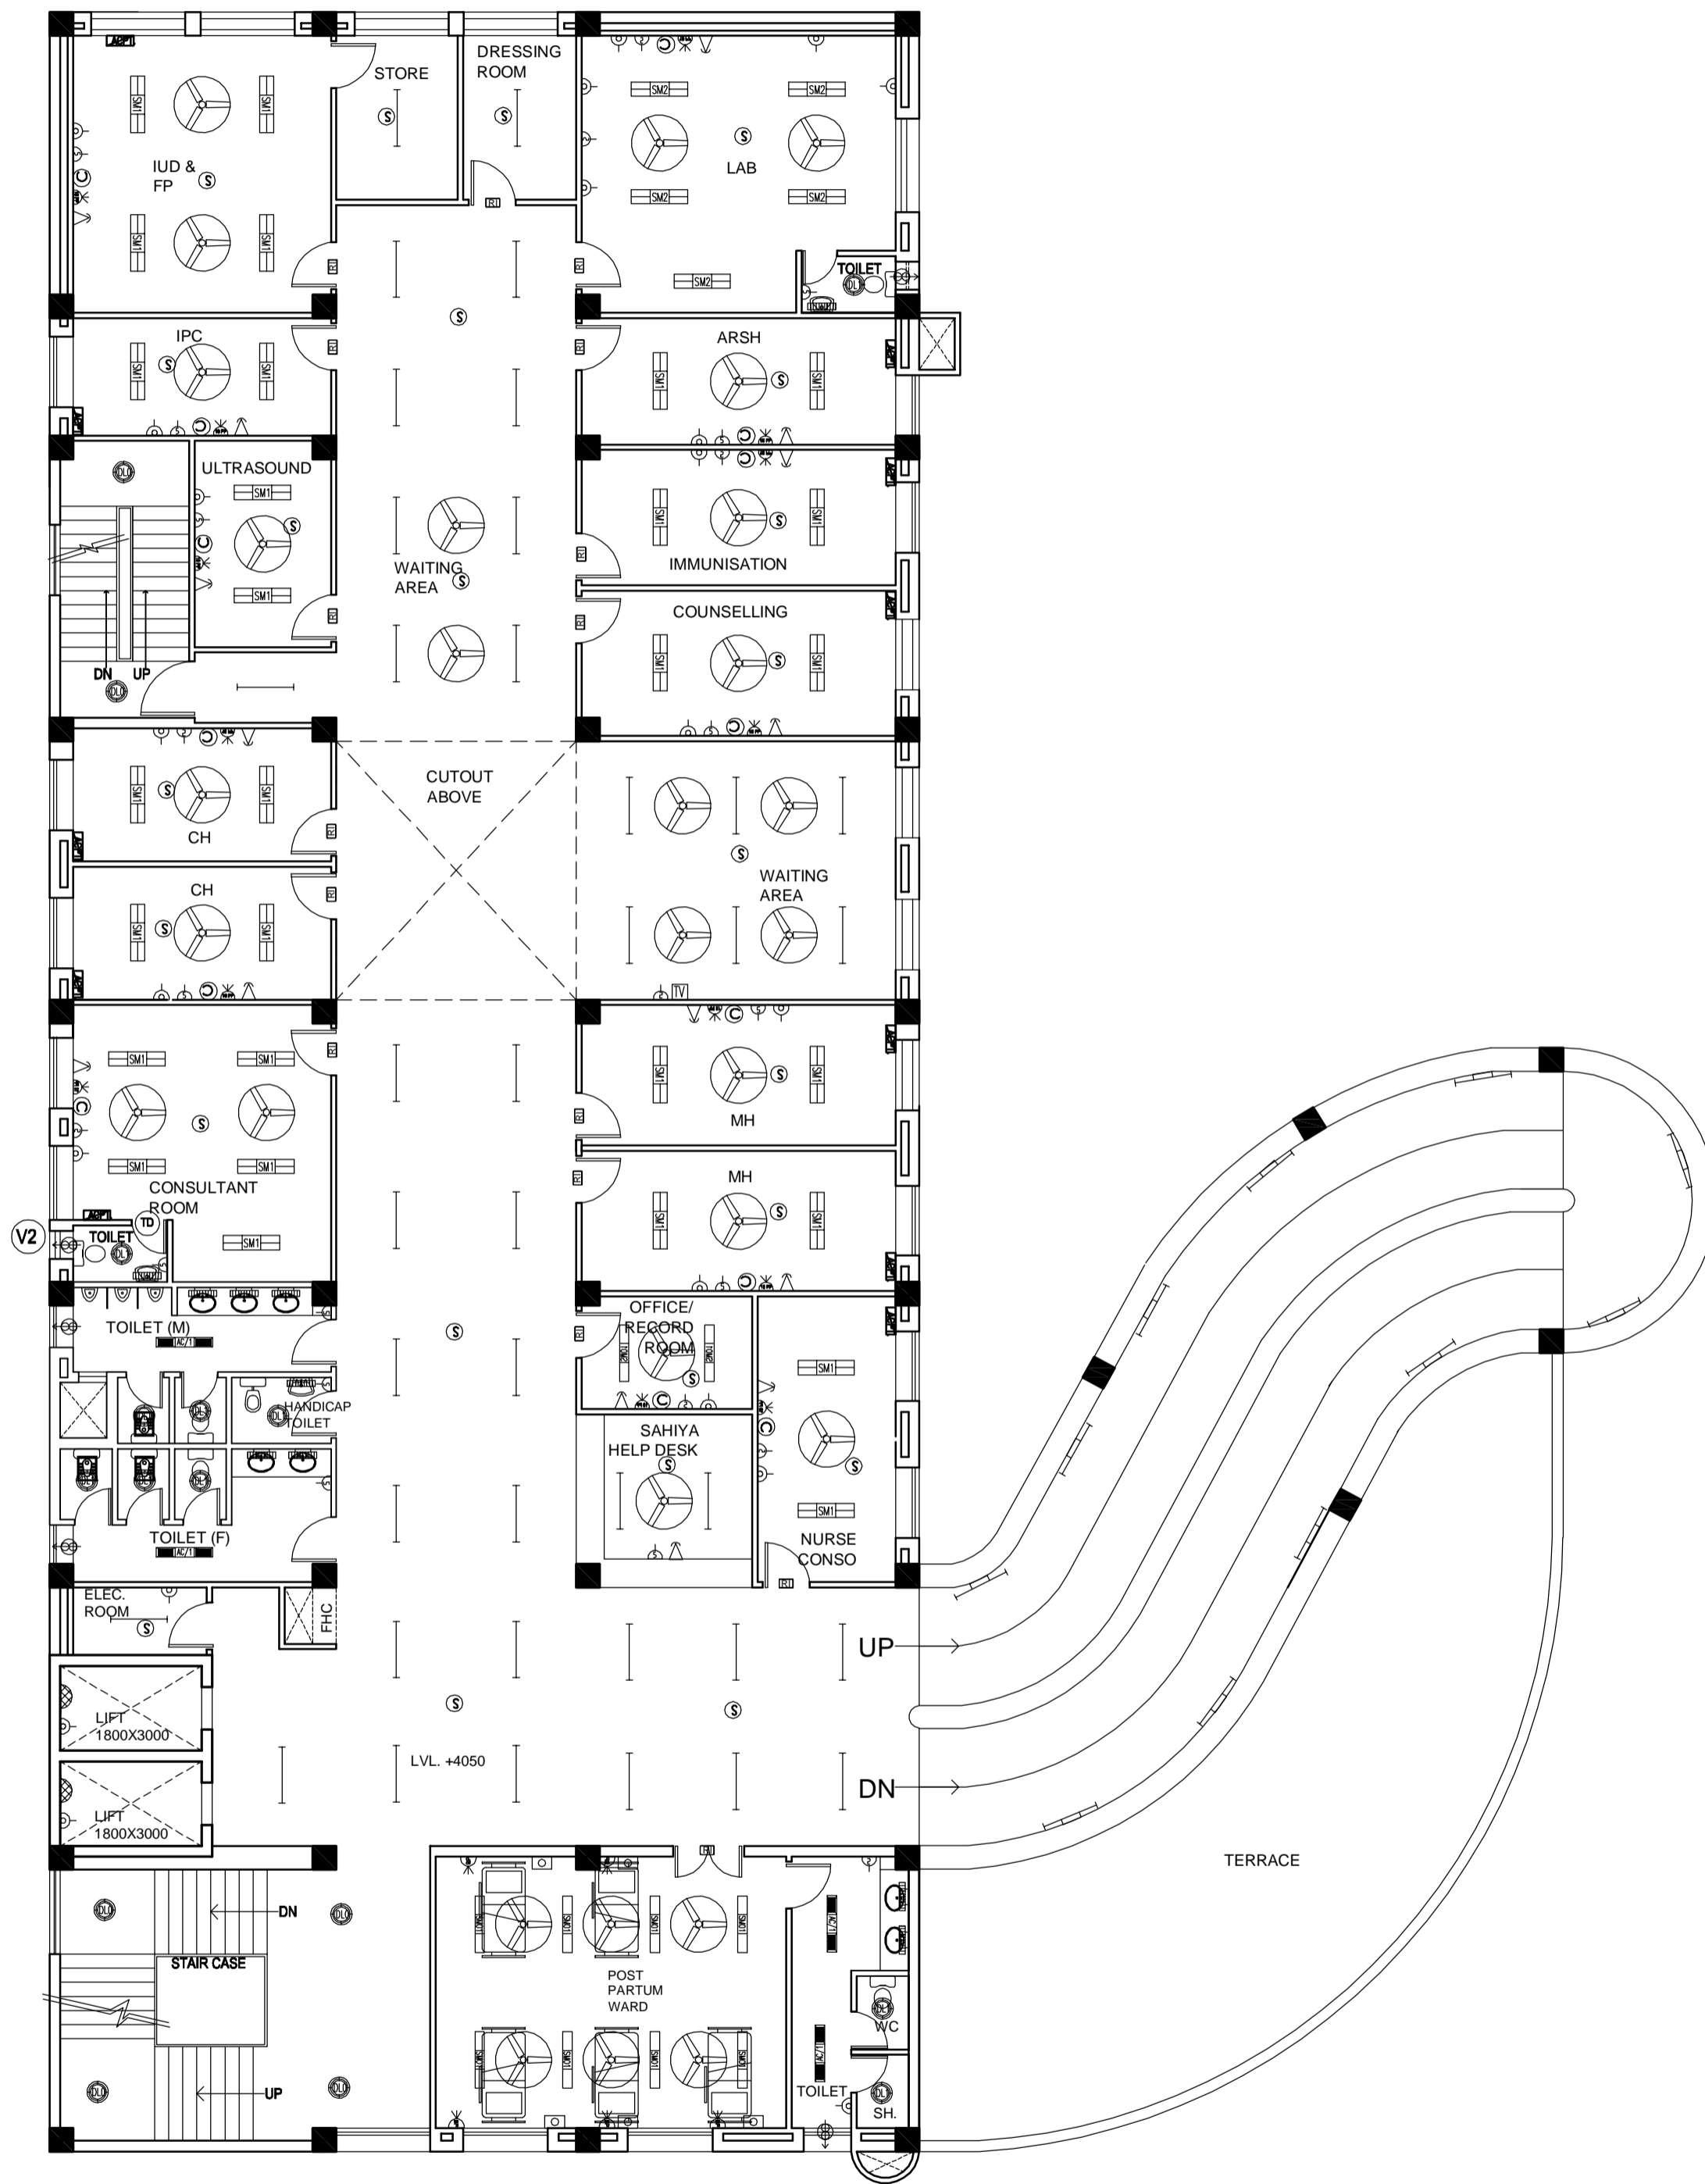

FIRST FLOOR

REVISION - 01
REVISED AS PER THE GUIDELINES OF VETTING COMMITTEE

PROJECT

PROPOSED
100 BEDDED HOSPITAL
PILIBHIT

TITLE

TENDER DRAWING
FIRST FLOOR PLAN
AREA - 980.58 SQM


ELECTRICAL LAYOUT

HSCC/TD/PILIBHIT/EL-202
Drawing No. Rev. - 01

Job No.	NTS Scale	Date
App by	Rev. by	Prep. by

NOTES

1. DRAWINGS TO BE READ NOT MEASURED
2. PARTITION WALL IN TOILETS UP TO LINTEL HEIGHT

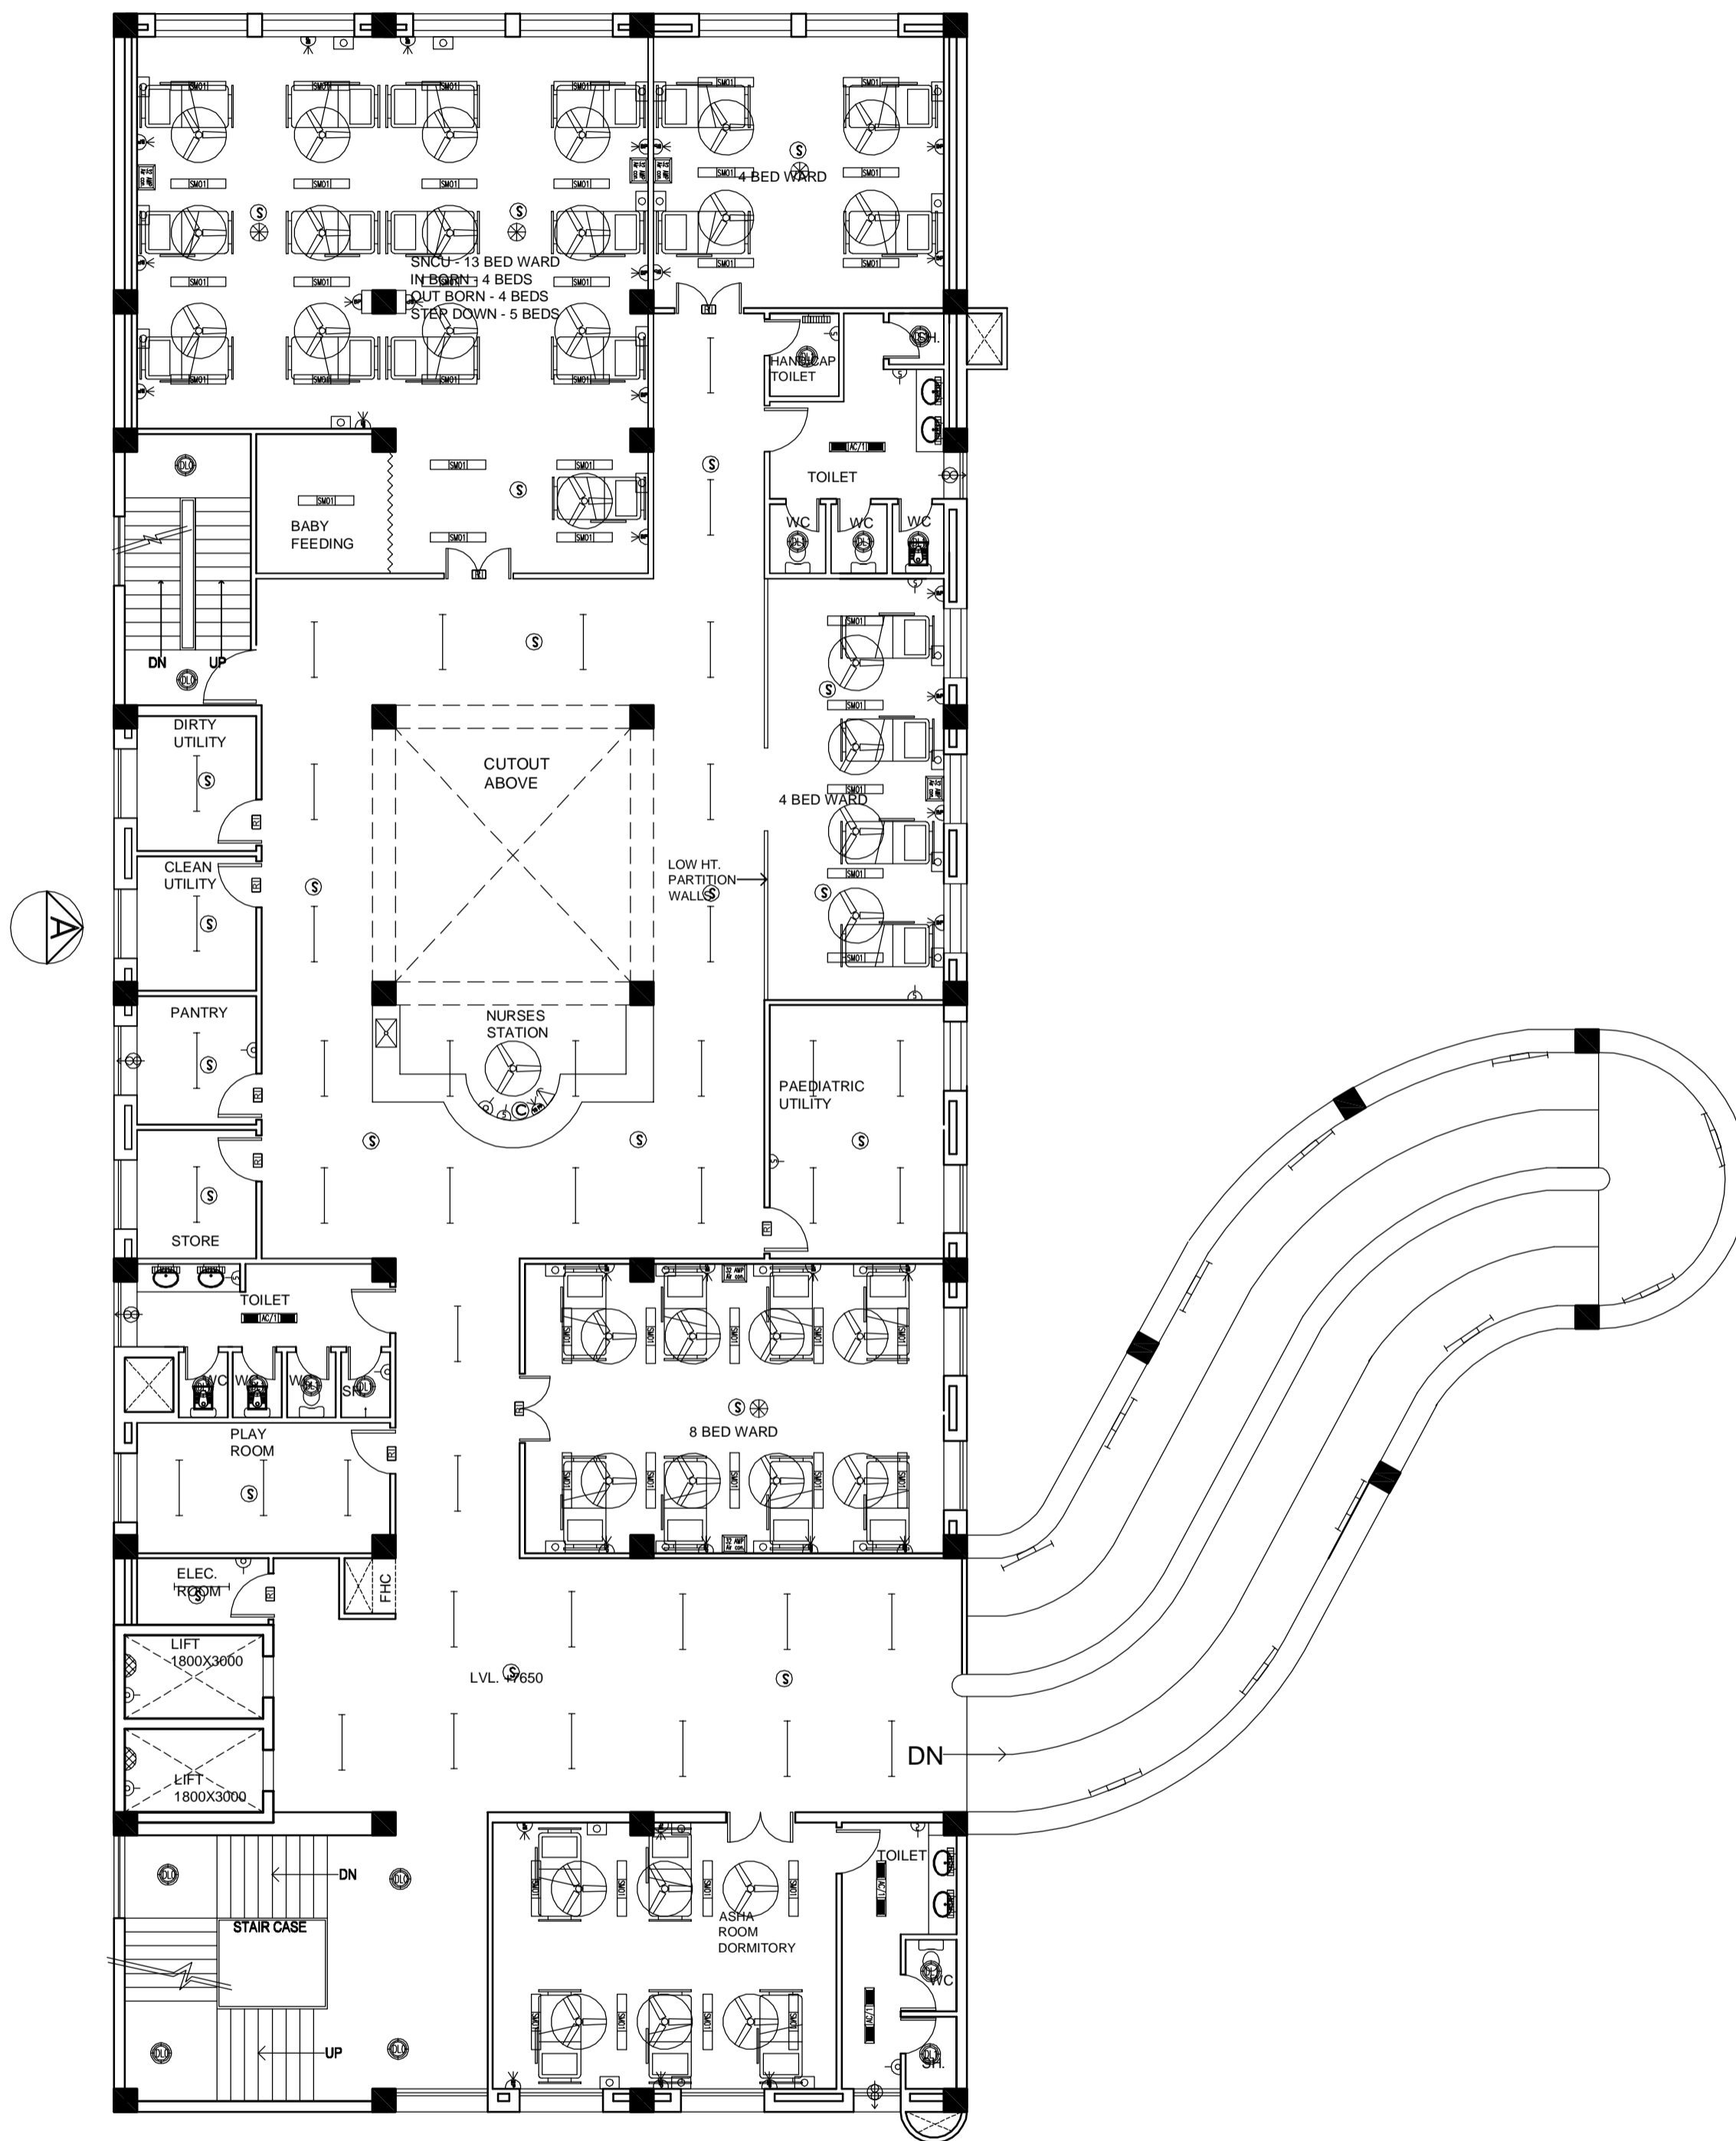

2ND FLOOR -PAEDIATRIC CARE
16 BEDS - PAEDIATRIC
13 BEDS - SNCU
5 BEDS - ASHA ROOM

REVISION - 01
 REVISED AS PER THE GUIDELINES OF VETTING COMMITTEE

PROJECT

PROPOSED
 100 BEDDED HOSPITAL
 PILIBHIT

TITLE

TENDER DRAWING
 SECOND FLOOR PLAN
 AREA - 980.58 SQM

ELECTRICAL LAYOUT


HSCC/TD/PILIBHIT/EL-203

Drawing No. Rev. - 01

Job No.	NTS Scale	Date

App by	Rev. by	Prep. by

- NOTES**
1. DRAWINGS TO BE READ NOT MEASURED
 2. PARTITION WALL IN TOILETS UP TO LINTEL HEIGHT

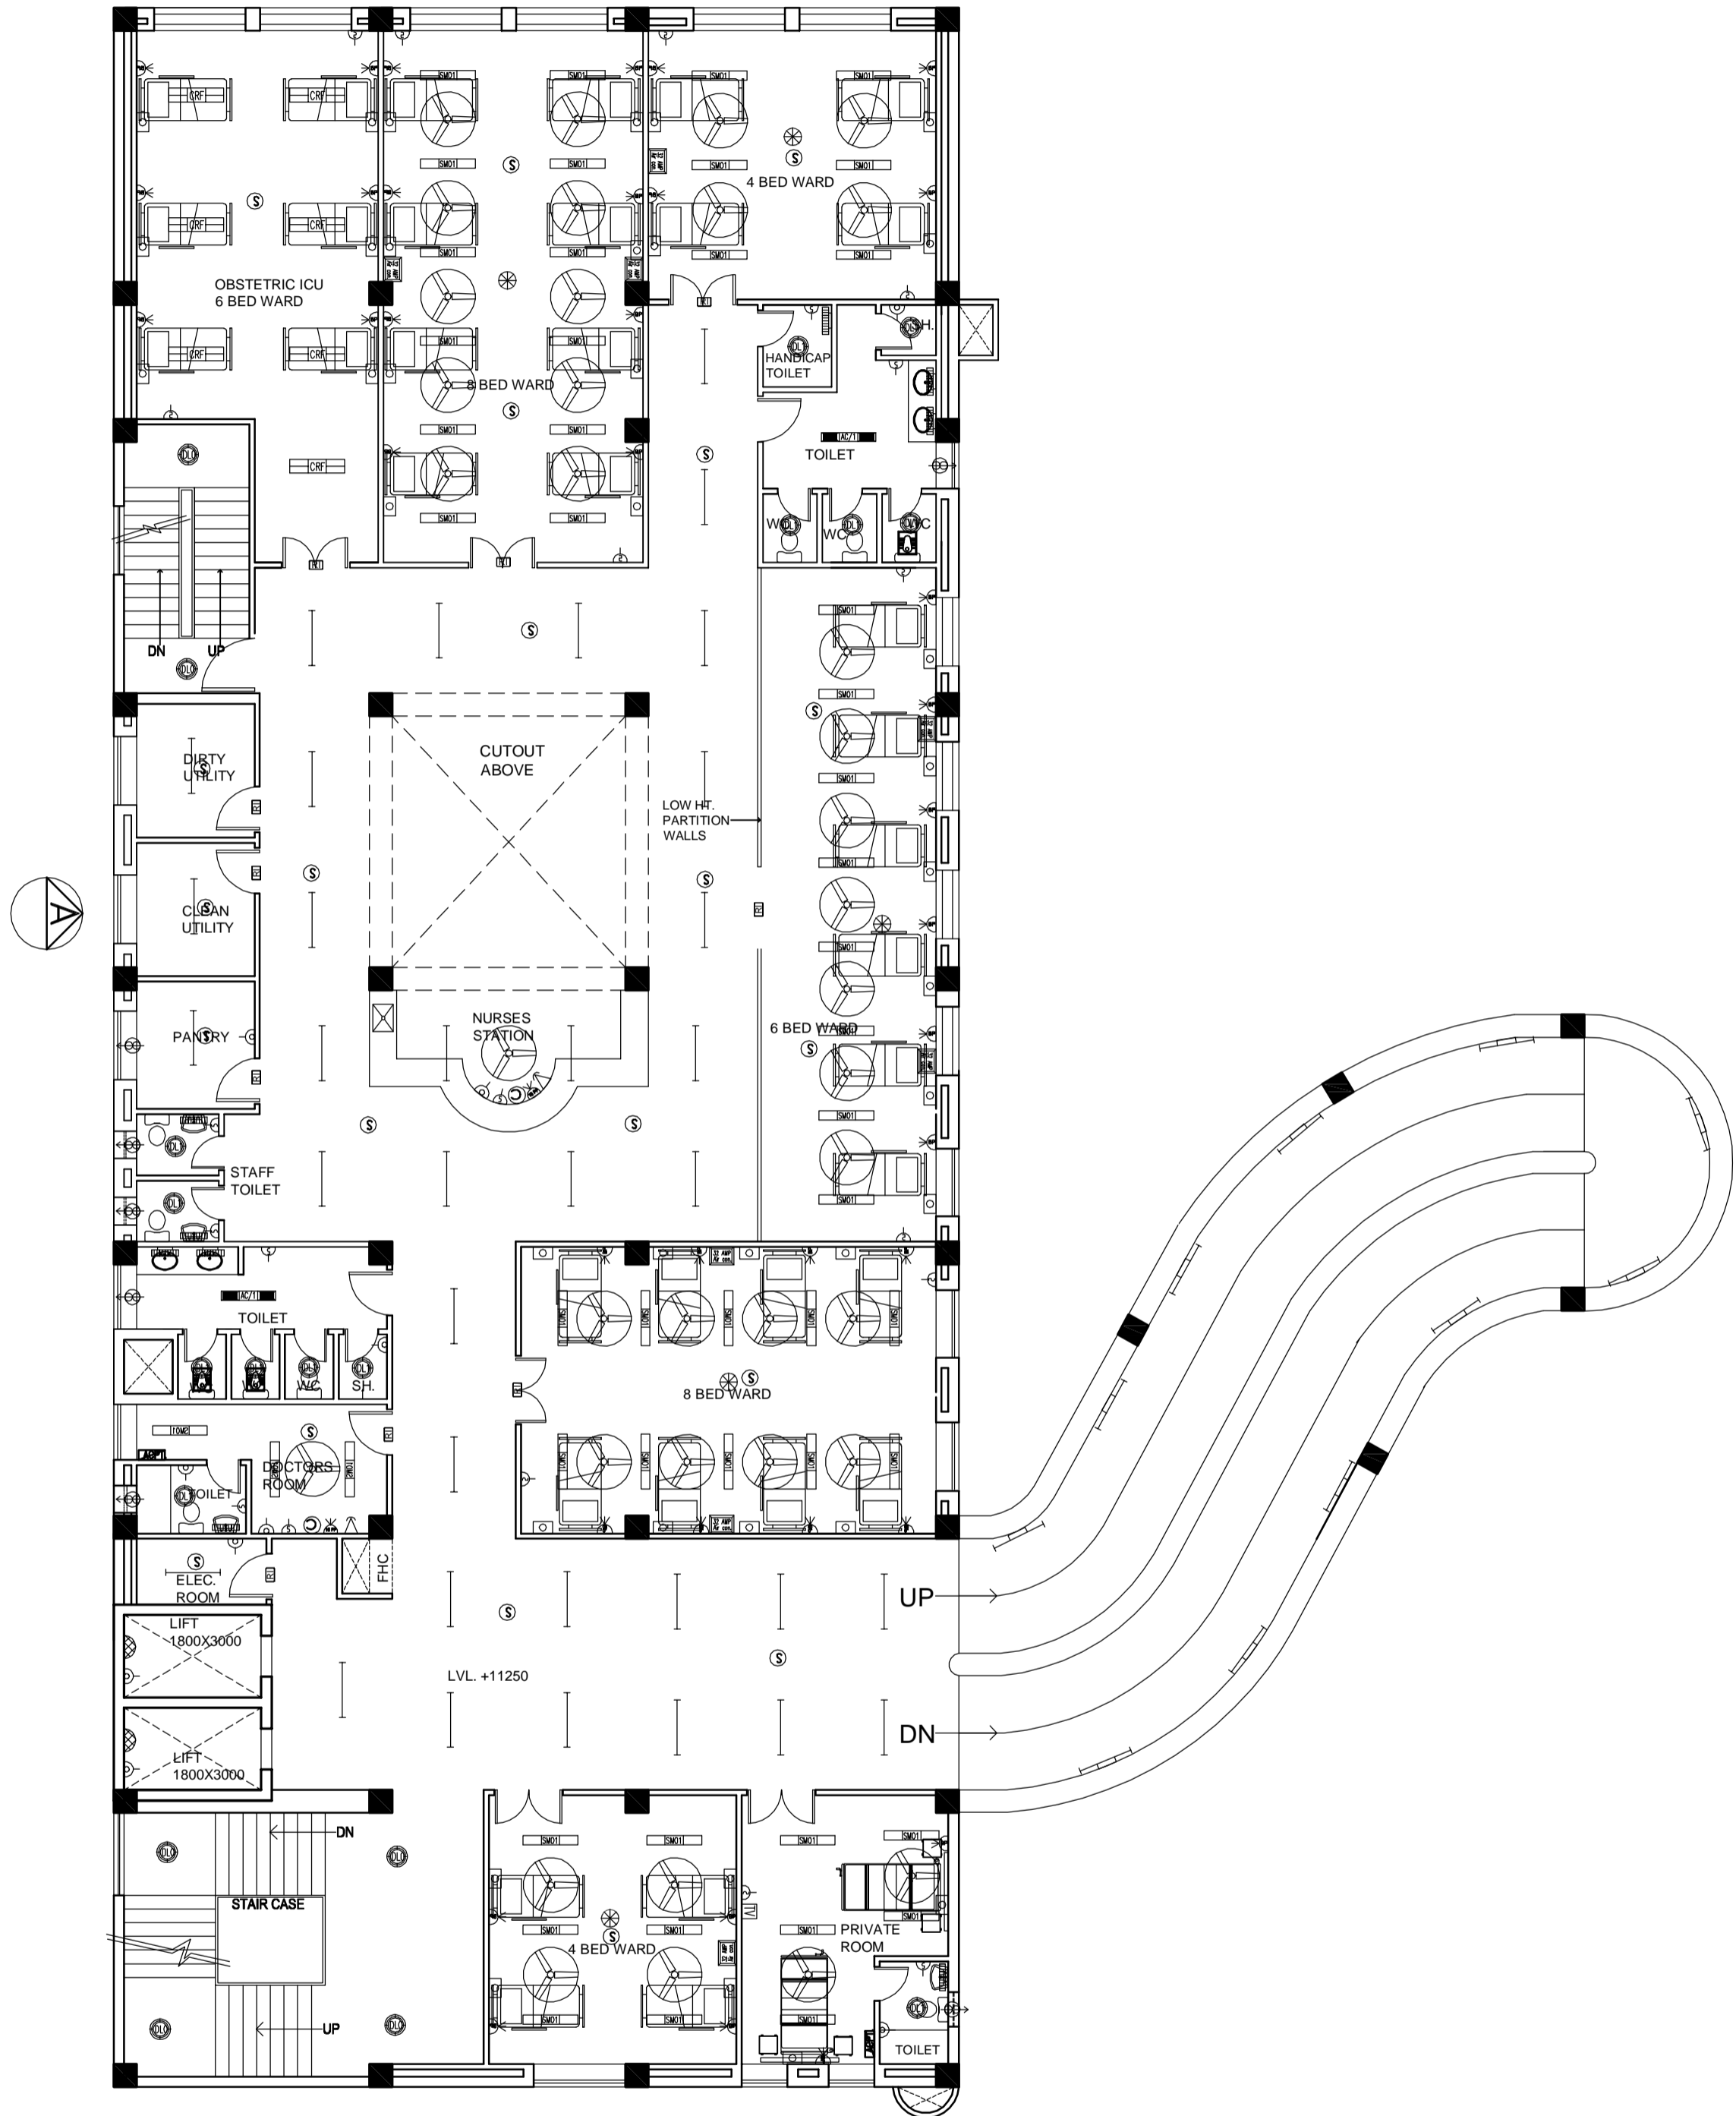

3RD FLOOR - ANTE NATAL CARE
WARD BEDS - 30 NO.
OBSTETRIC ICU - 6 BEDS
PRIVATE ROOM - 2 BEDS

REVISION - 01
 REVISED AS PER THE GUIDELINES OF VETTING COMMITTEE

PROJECT
 PROPOSED
 100 BEDDED HOSPITAL
 PILIBHIT


TITLE
 TENDER DRAWING
 THIRD FLOOR PLAN
 AREA - 980.58 SQM

ELECTRICAL LAYOUT

HSCC/TD/PILIBHIT/EL-204
 Drawing No. Rev. - 01

Job No.	NTS Scale	Date
App by	Rev. by	Prep. by

- NOTES**
1. DRAWINGS TO BE READ NOT MEASURED
 2. PARTITION WALL IN TOILETS UP TO LINTEL HEIGHT

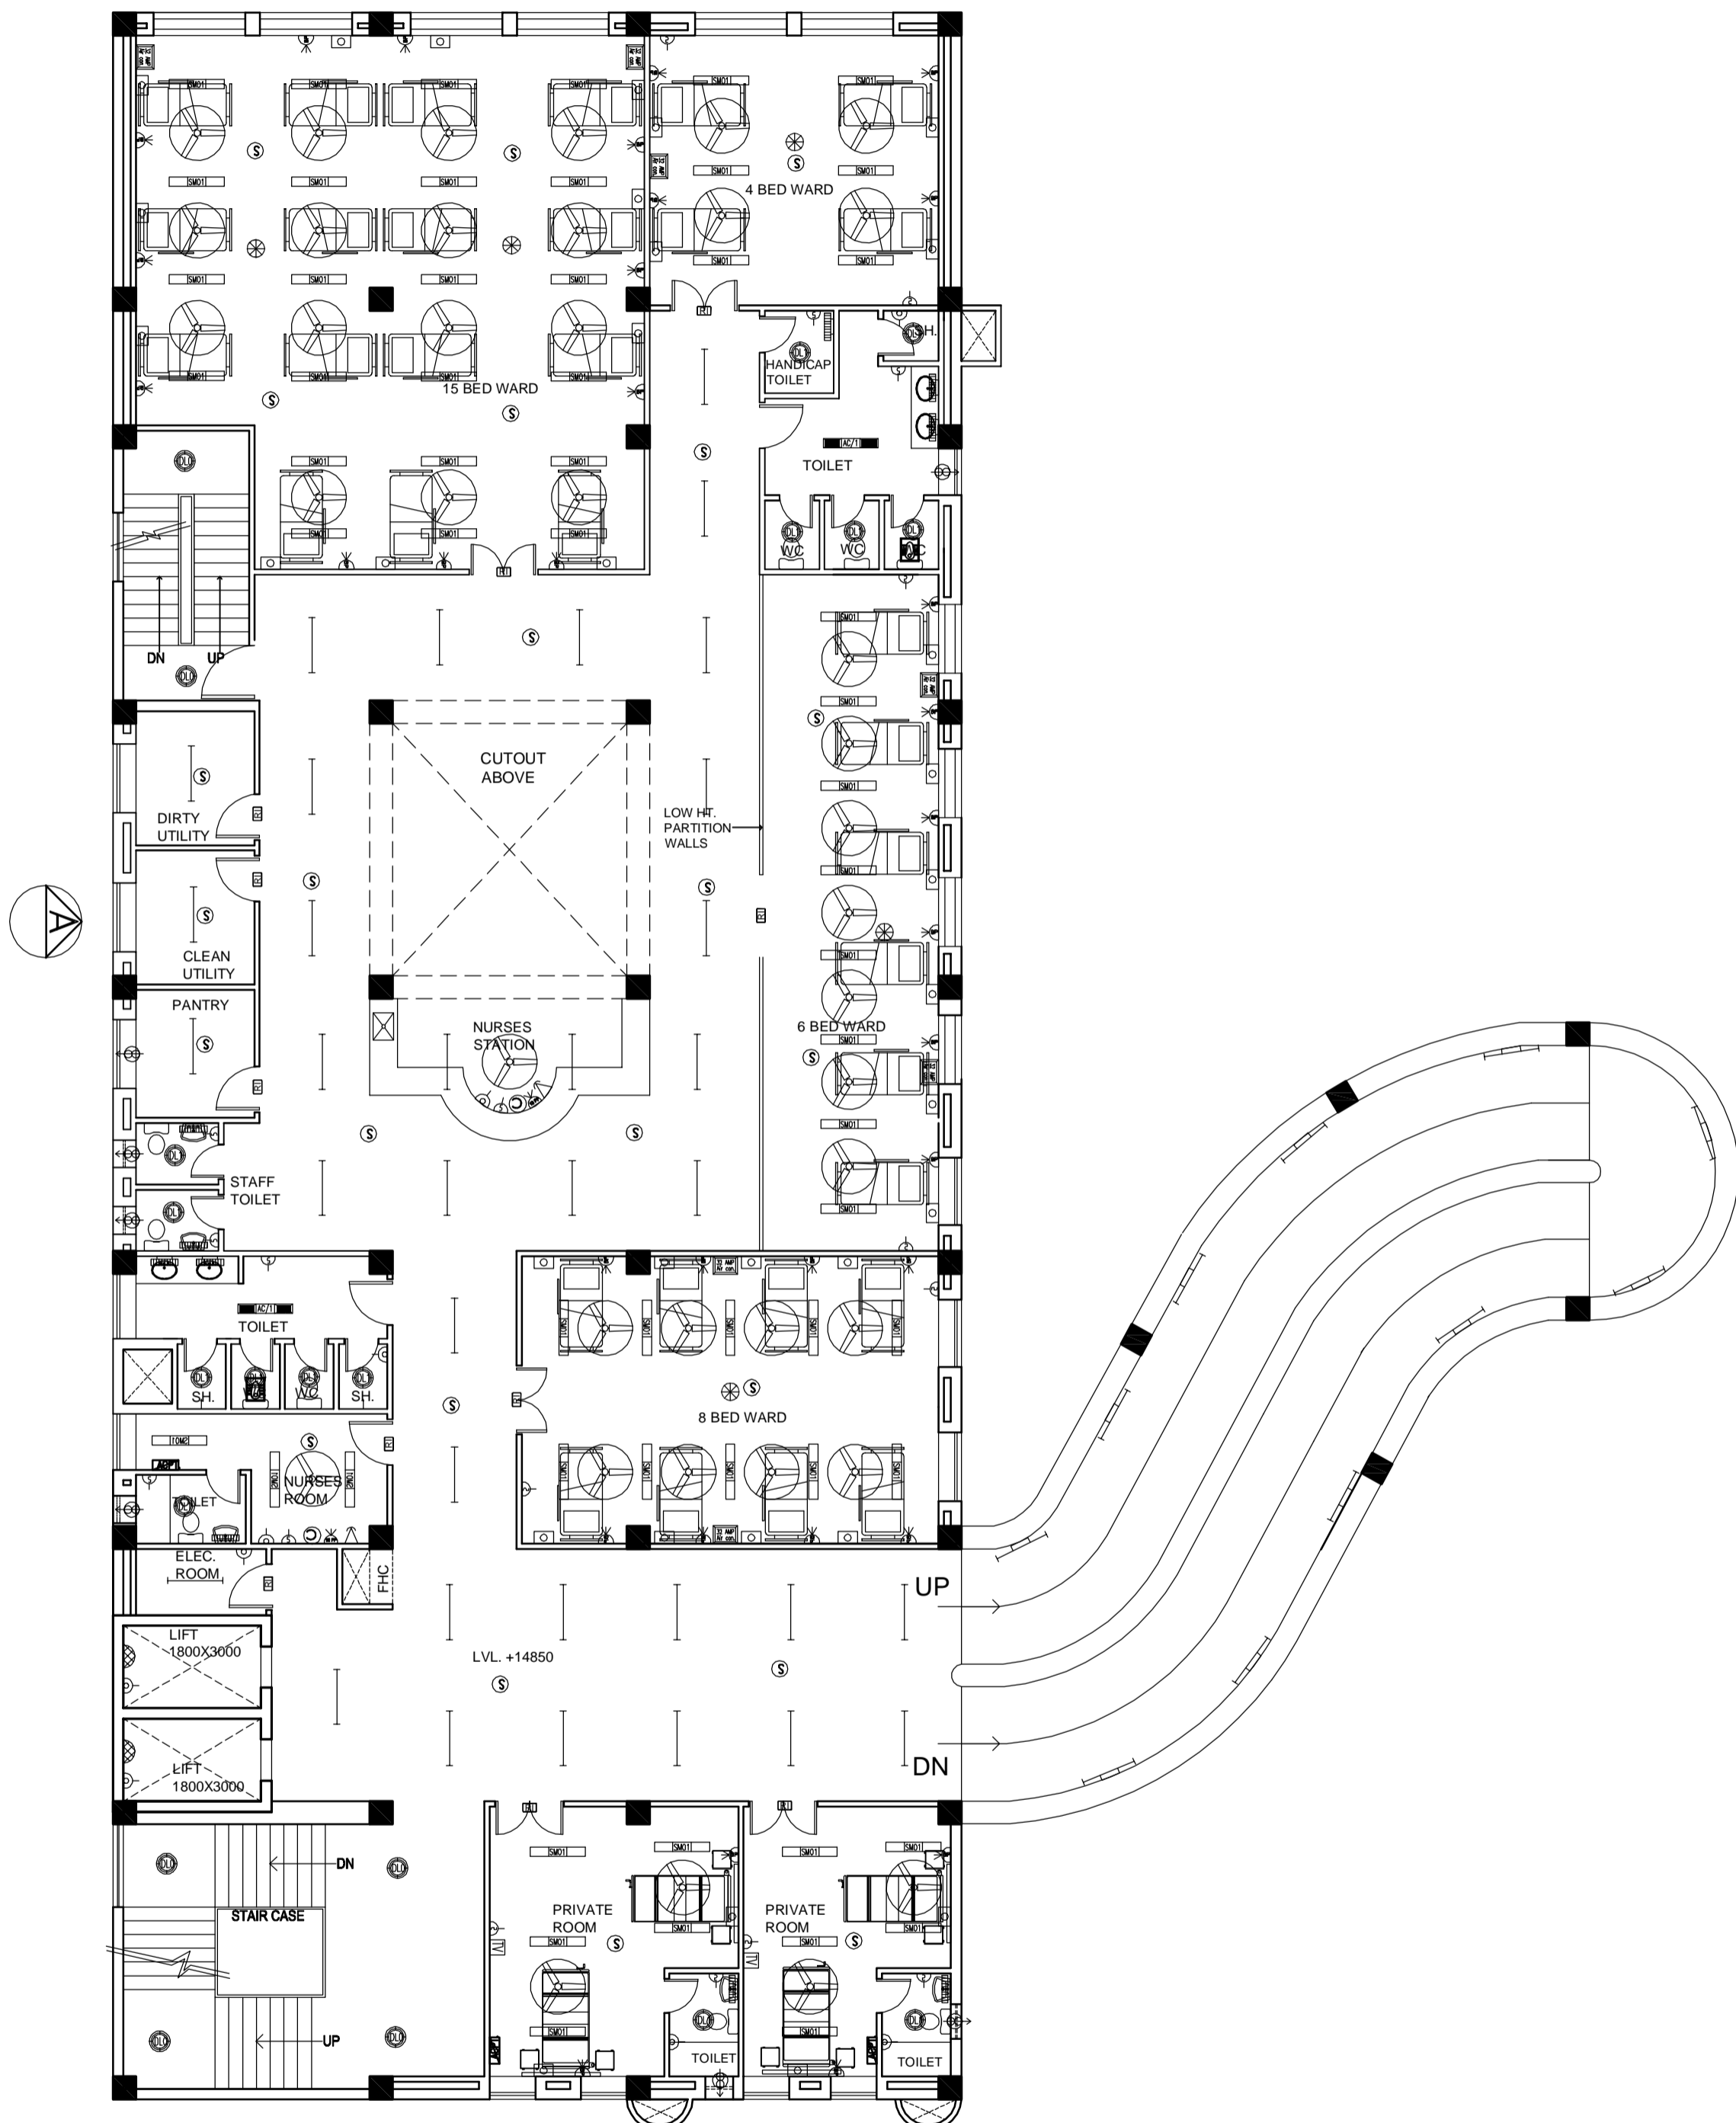

4TH FLOOR -POST NATAL CARE
WARD BEDS - 33NO.
PRIVATE ROOM - 4 BEDS

REVISION - 01
 REVISED AS PER THE GUIDELINES OF VETTING COMMITTEE

PROJECT
 PROPOSED
 100 BEDDED HOSPITAL
 PILIBHIT


TITLE
 TENDER DRAWING
 FOURTH FLOOR PLAN
 AREA - 841.75 SQM

ELECTRICAL LAYOUT

HSCC/TD/PILIBHIT/EL-205
 Drawing No. Rev. - 01

Job No.	NTS Scale	Date
App by	Rev. by	Prep. by

- NOTES**
1. DRAWINGS TO BE READ NOT MEASURED
 2. PARTITION WALL IN TOILETS UP TO LINTEL HEIGHT

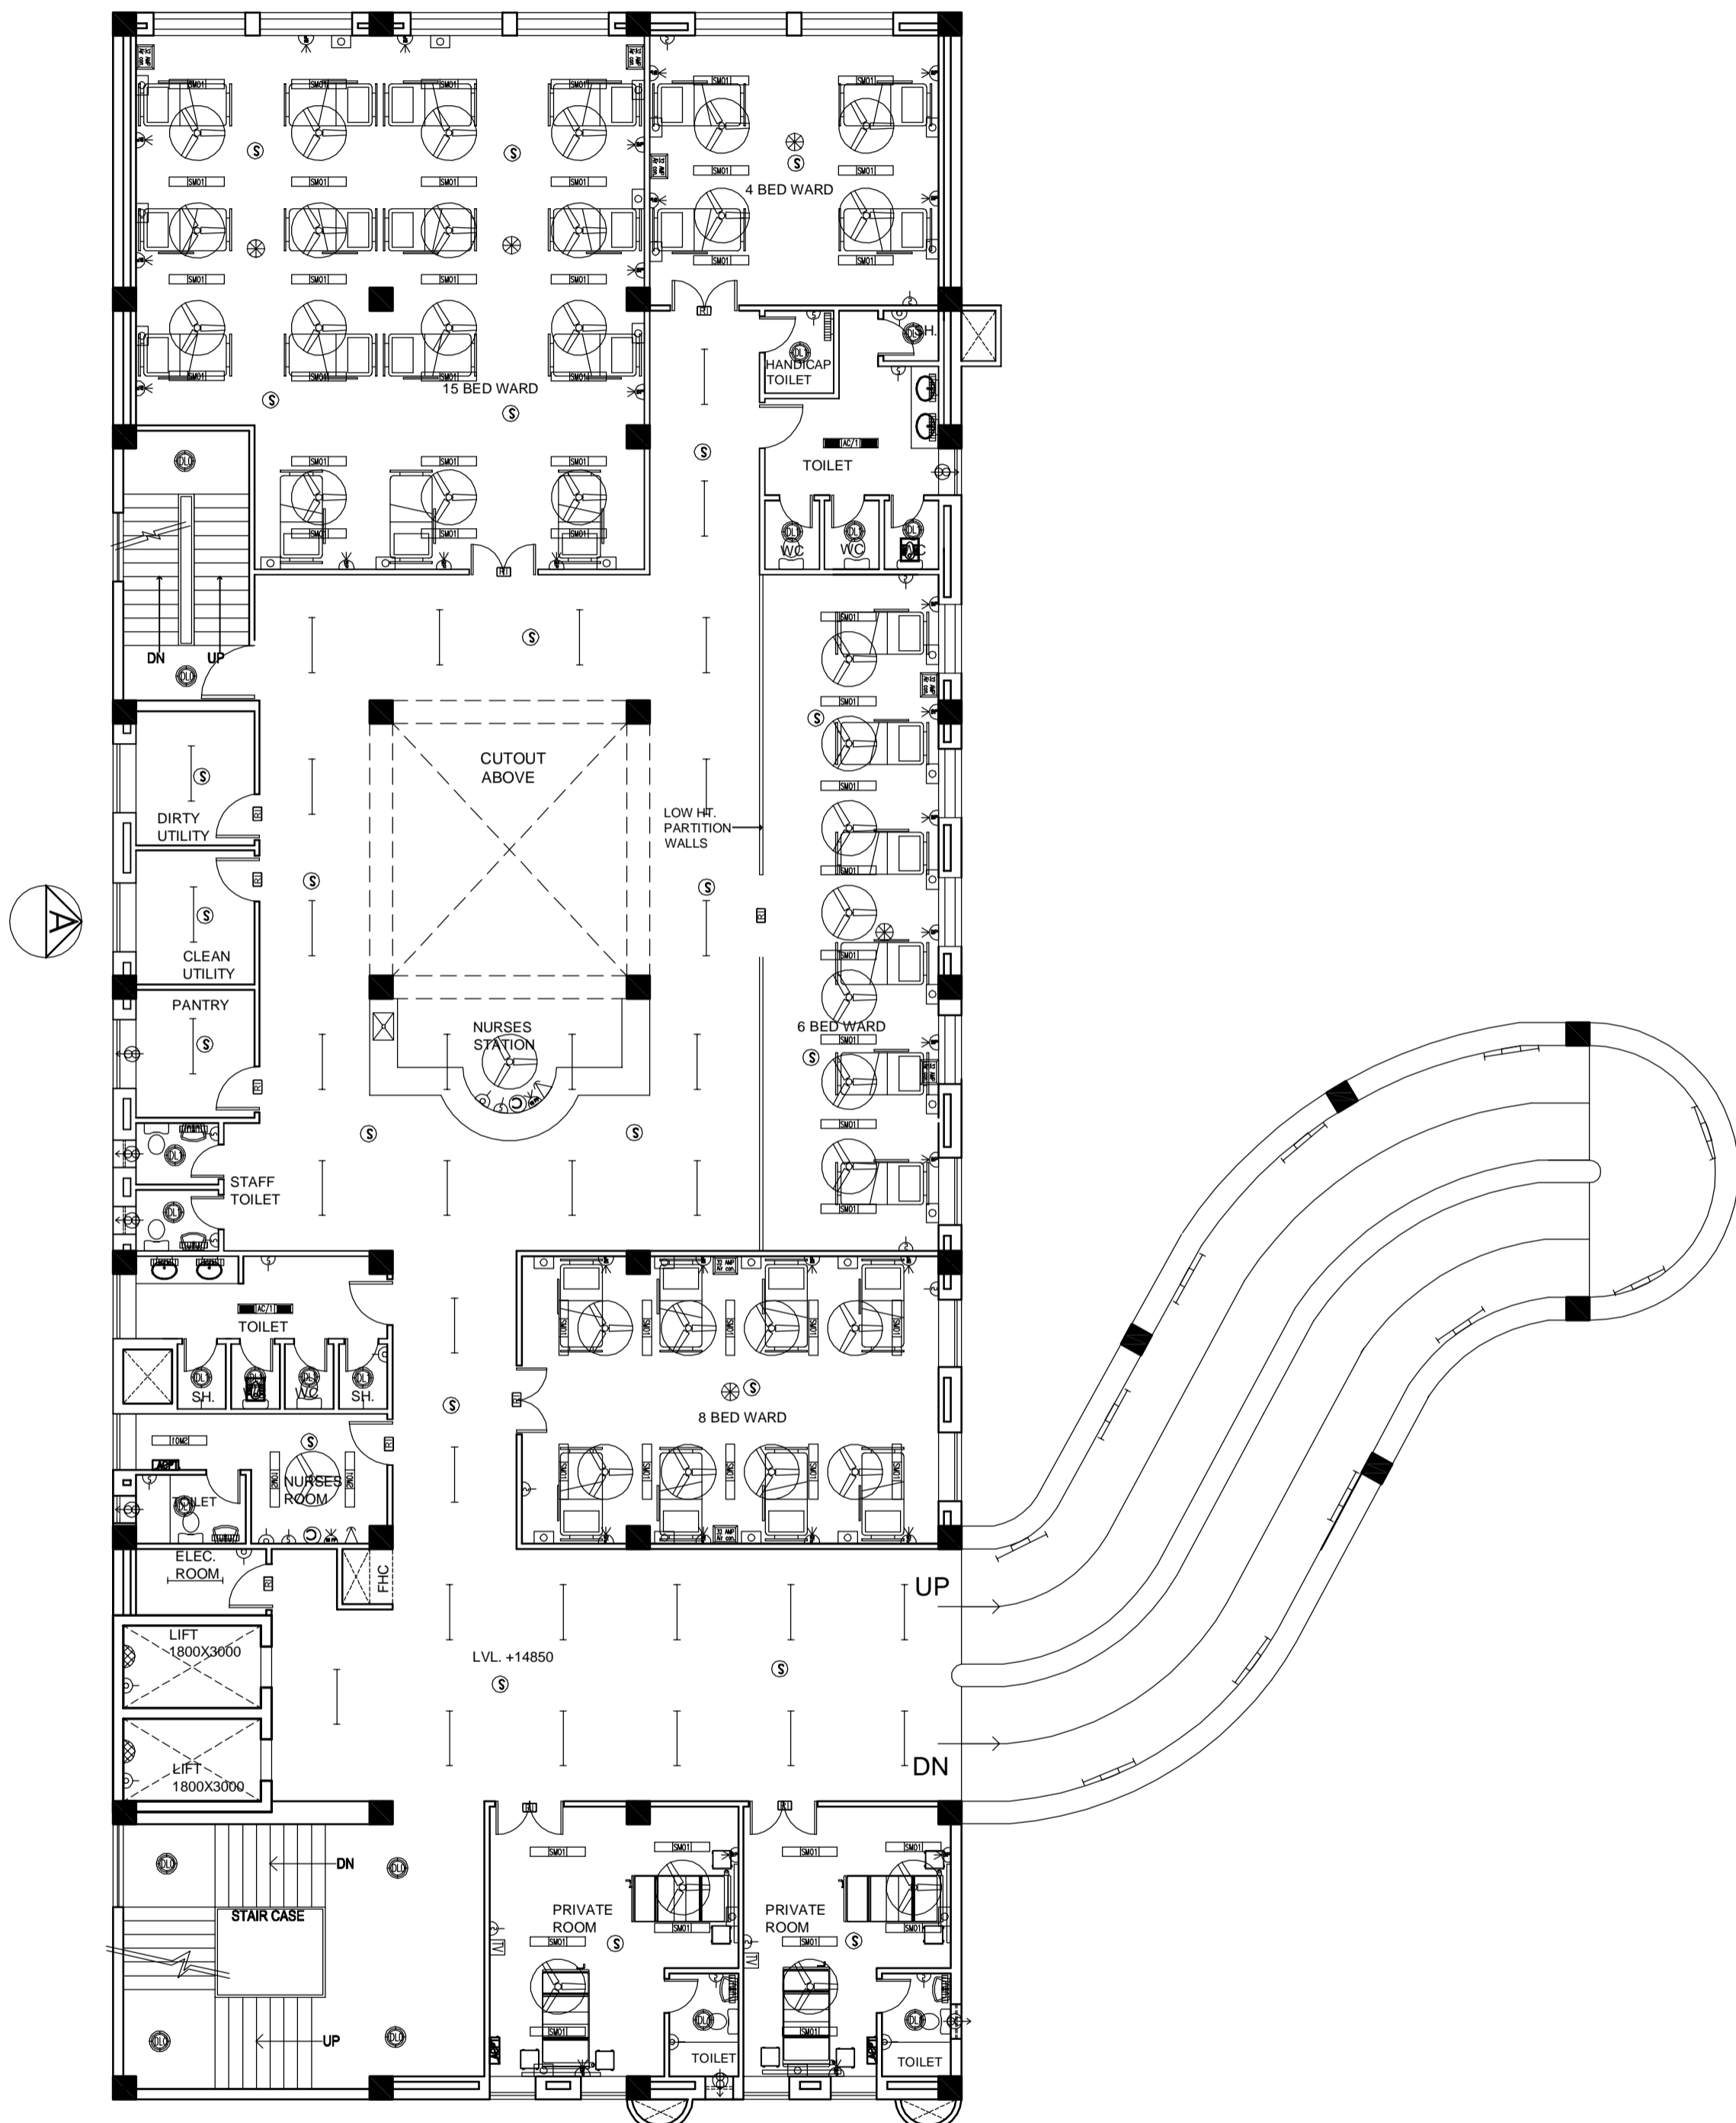

4TH FLOOR -POST NATAL CARE
WARD BEDS - 33NO.
PRIVATE ROOM - 4 BEDS

REVISION - 01
 REVISED AS PER THE GUIDELINES OF VETTING COMMITTEE

PROJECT
 PROPOSED
 100 BEDDED HOSPITAL
 PILIBHIT


TITLE
 TENDER DRAWING
 FOURTH FLOOR PLAN
 AREA - 841.75 SQM

ELECTRICAL LAYOUT

HSCC/TD/PILIBHIT/EL-205
 Drawing No. Rev. - 01

Job No.	NTS Scale	Date
App by	Rev. by	Prep. by

- NOTES**
- DRAWINGS TO BE READ NOT MEASURED
 - PARTITION WALL IN TOILETS UP TO LINTEL HEIGHT

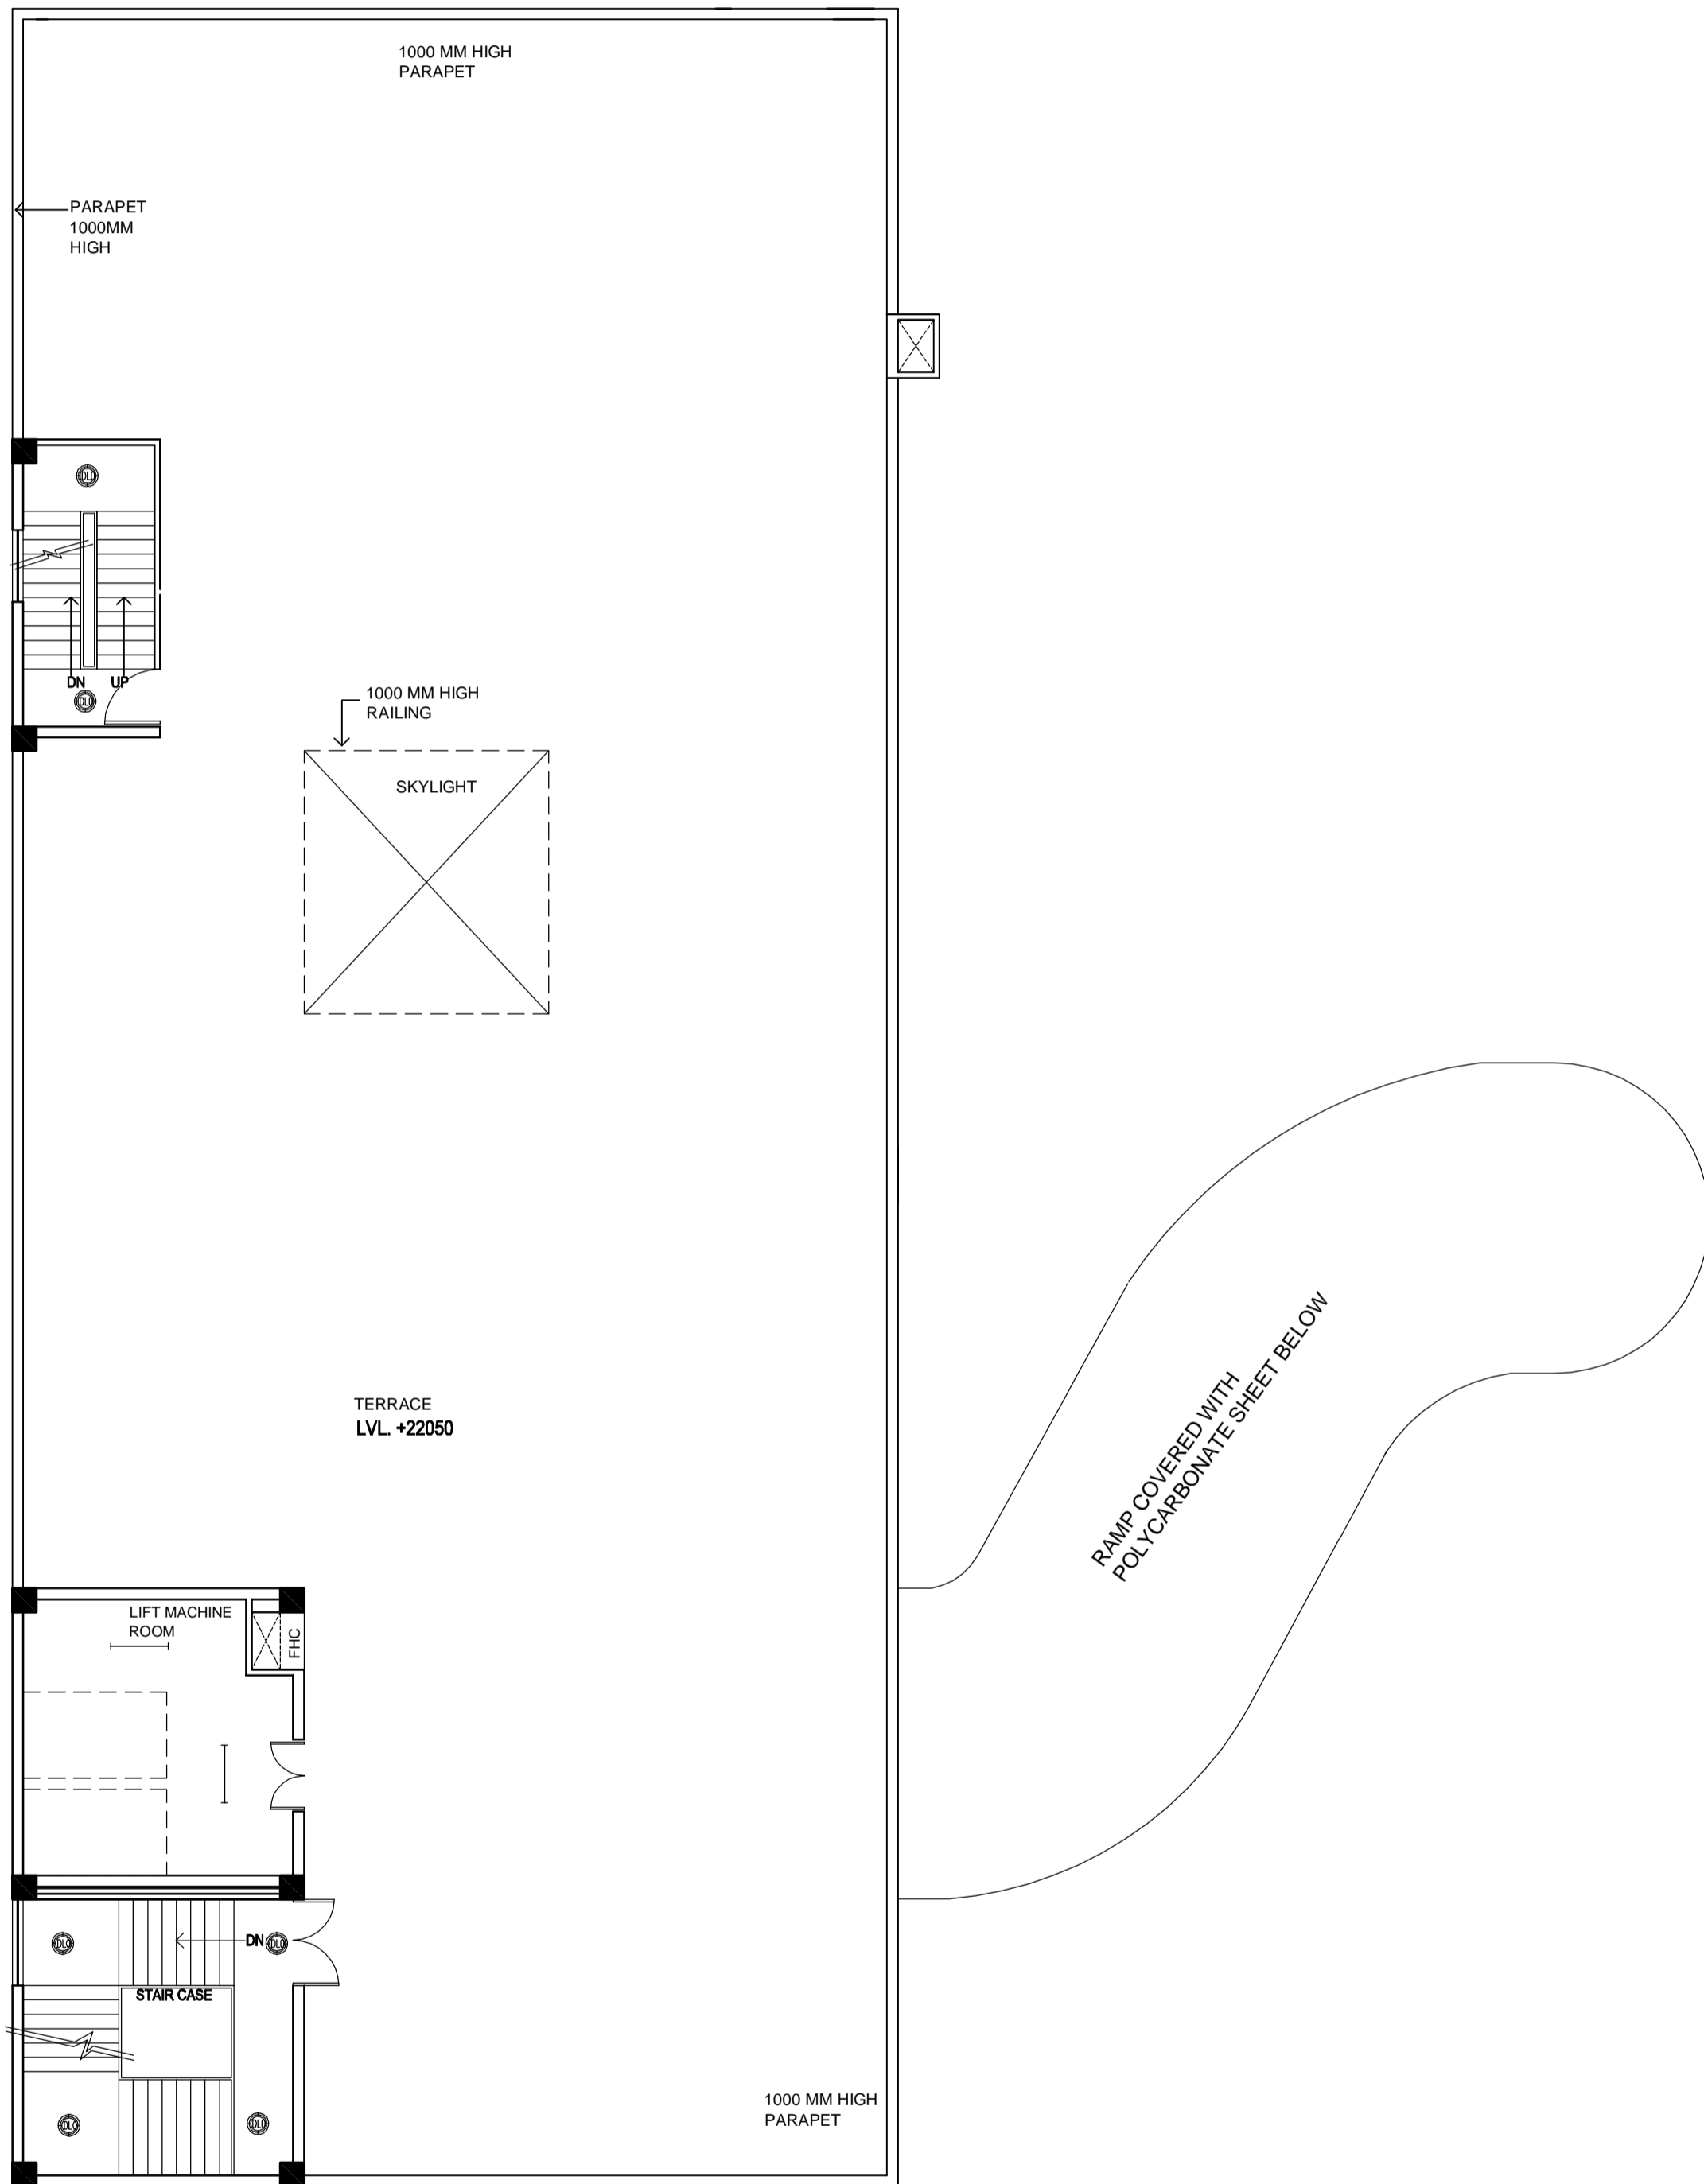

TERRACE PLAN

REVISION - 01
 REVISED AS PER THE GUIDELINES OF VETTING COMMITTEE

PROJECT
 PROPOSED
 100 BEDDED HOSPITAL
 PILIBHIT

TITLE
 TENDER DRAWING
 TERRACE PLAN

ELECTRICAL LAYOUT

HSCC/TD/PILIBHIT/EL-207
 Drawing No. Rev. - 01

Job No.	NTS Scale	Date
App by	Rev. by	Prep. by


This drawing with all its contents is the sole intellectual property of the Hospital Services Consultancy Corporation (India) Ltd. Copying of this drawing or part thereof or its use in any form whatsoever without the written permission of HSCC is prohibited.

NOTES

1. DRAWINGS TO BE READ NOT MEASURED
2. PARTITION WALL IN TOILETS UP TO LINTEL HEIGHT

DOOR / WINDOW SCHEDULE

S.NO.	TYPE	WIDTH	CILL	LINTEL
1	D	2000	—	2100
2	D1	1000	—	2100
3	D2	1500	—	2100
4	FD	1200	—	2250
5	D4	800	—	2100
6	D5	750	—	2100
7	DW1	2200	—	2900
8	W	2000	900	2600
9	W1	1800	900	2600
10	W2	1500	900	2600
11	W3	1200	900	2600
12	W4	1000	900	2600
13	W5	800	900	2600
14	W6	2400	900	2600
15	V1	900	1700	2600
16	V2	600	1700	2600
17	V3	750	1700	2600
18	GL	4500	150	2900
19	GL1	5100	150	2900

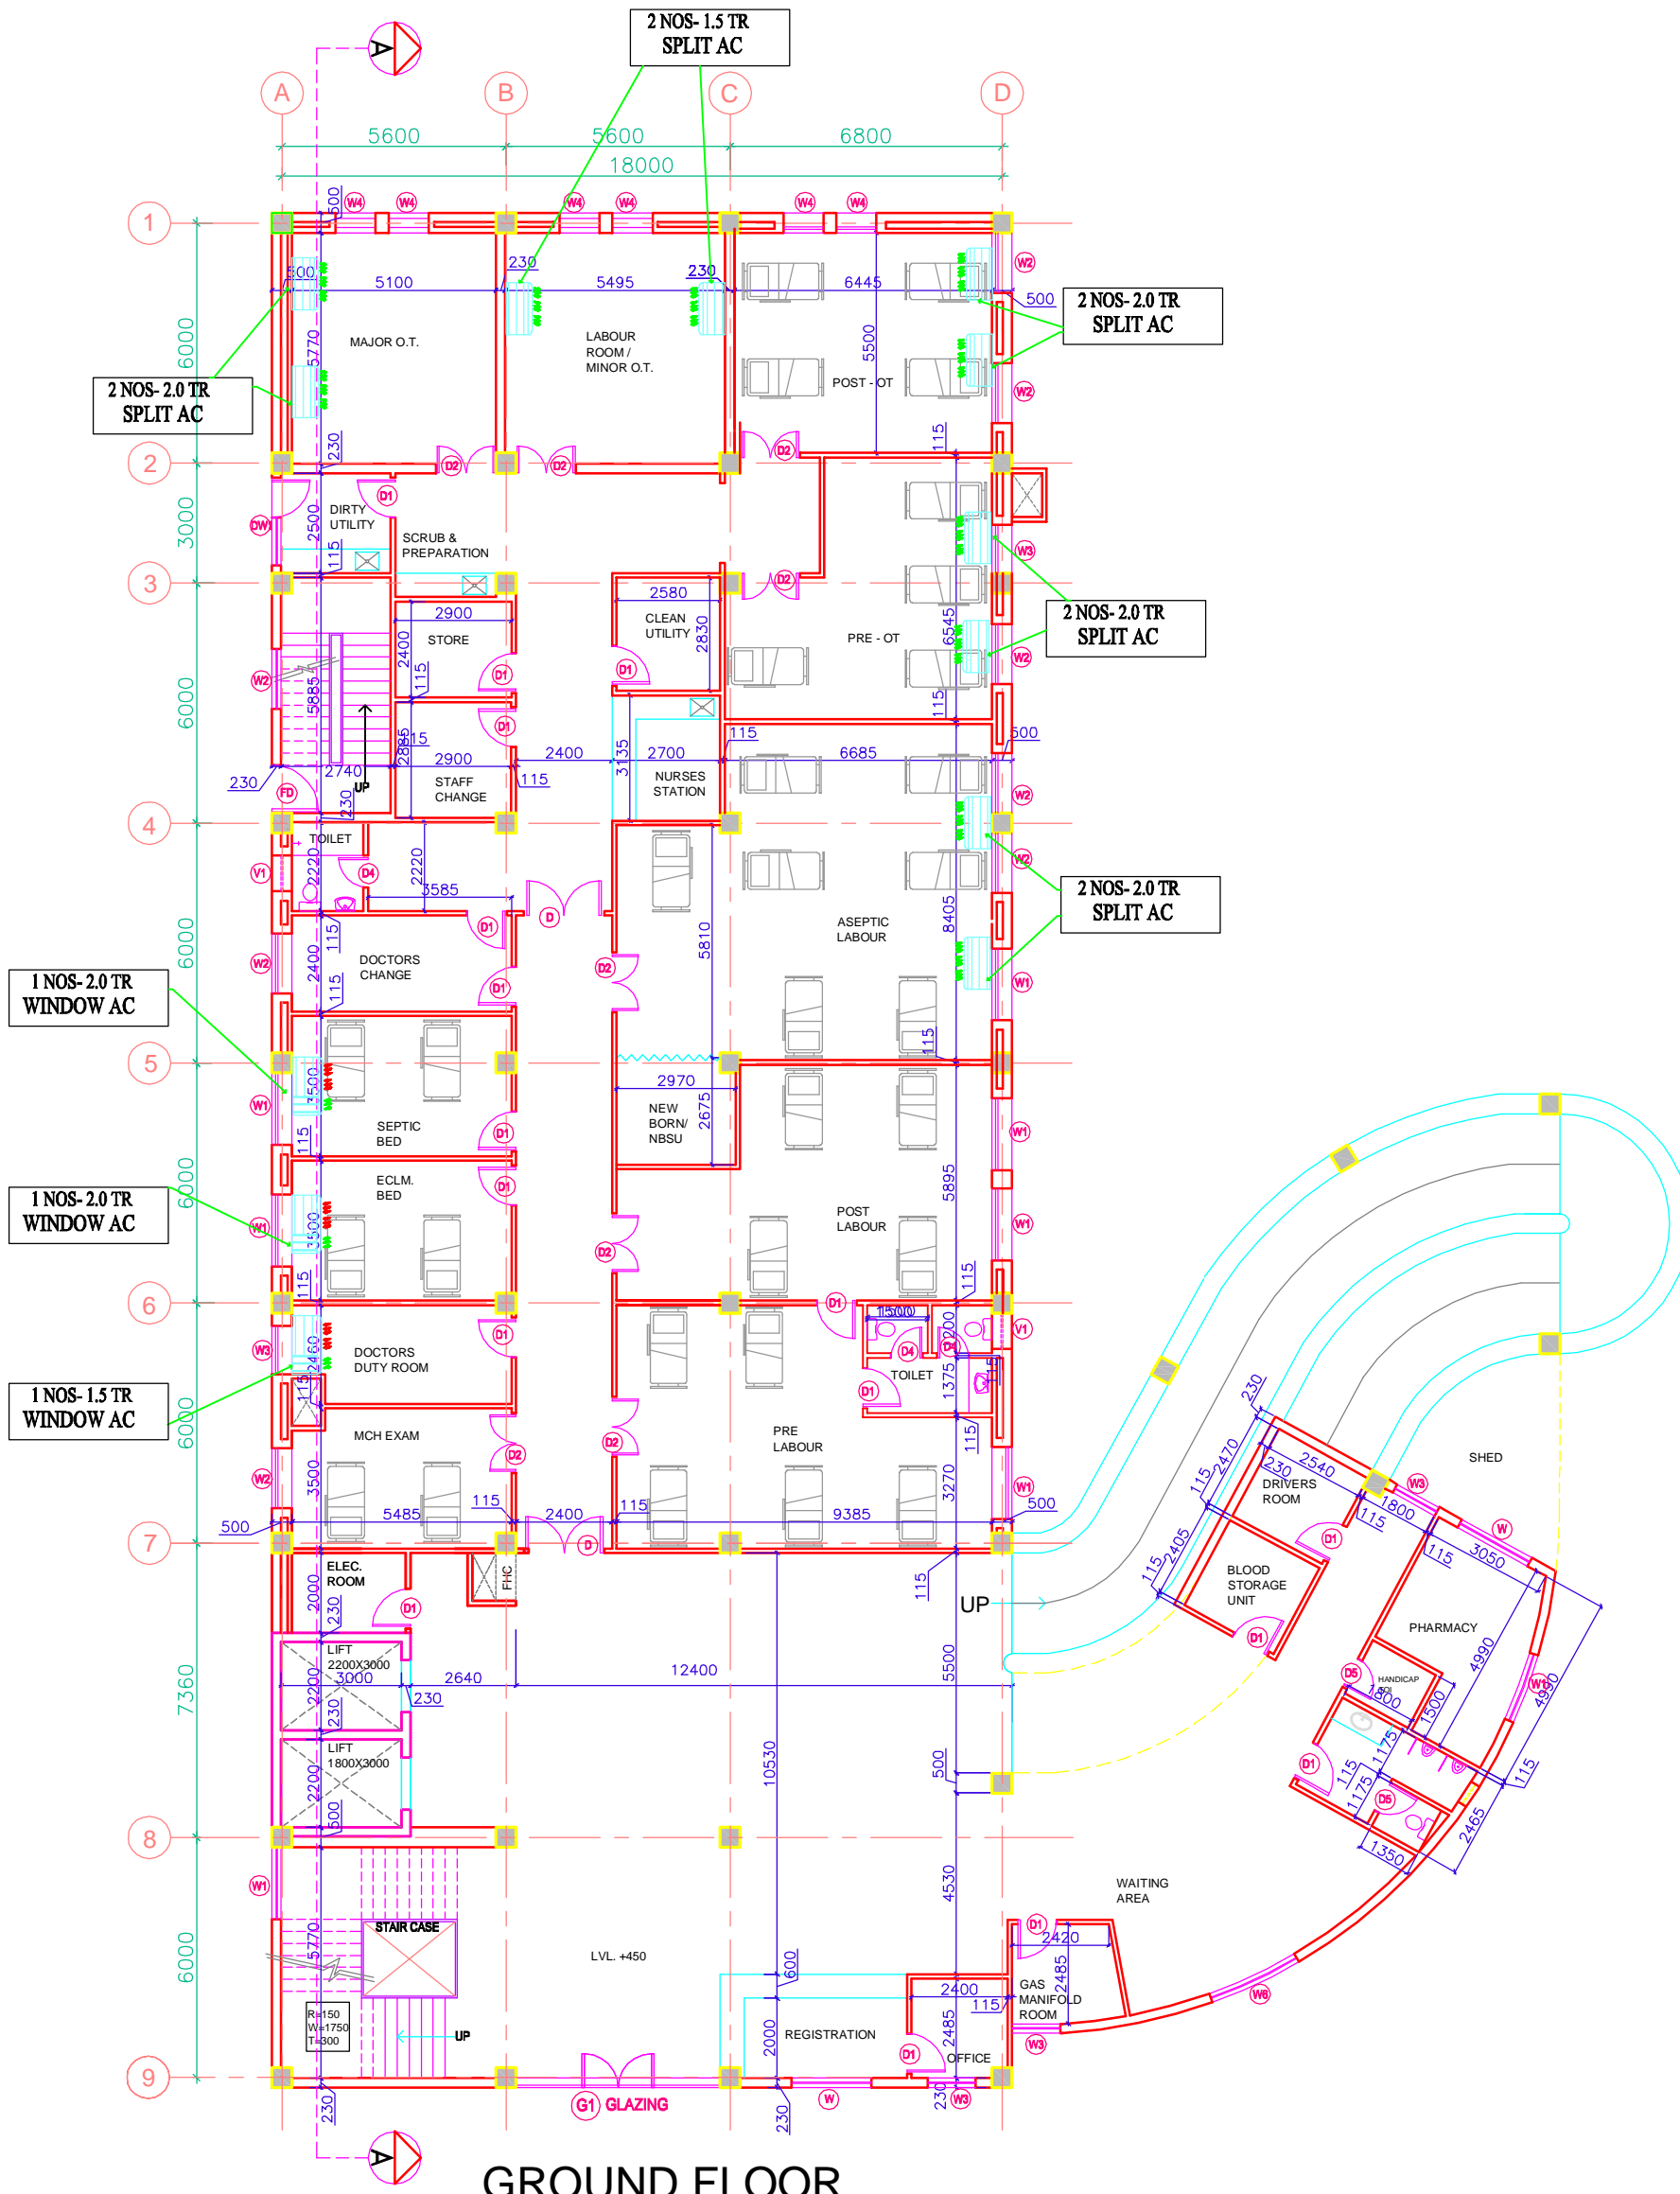

GROUND FLOOR

REVISION - 01
REVISED AS PER THE GUIDELINES OF VETTING COMMITTEE

PROJECT
PROPOSED
100 BEDDED HOSPITAL
PILIBHIT

TITLE
TENDER DRAWING
HVAC LAYOUT
GROUND FLOOR PLAN

HSCC/D&E/HVAC/UP-PILIBHIT/JAC-01
Rev. - 01

Job No.	1:175 Scale	JUN-2013 Date
App by	Rev. by	Prep. by

HSCC (INDIA) LIMITED
(A GOVERNMENT OF INDIA ENTERPRISES)
HSCC
NEW DELHI INDIA

PRODUCED BY AN AUTODESK EDUCATIONAL PRODUCT