


PHE & FIRE

DRAWINGS

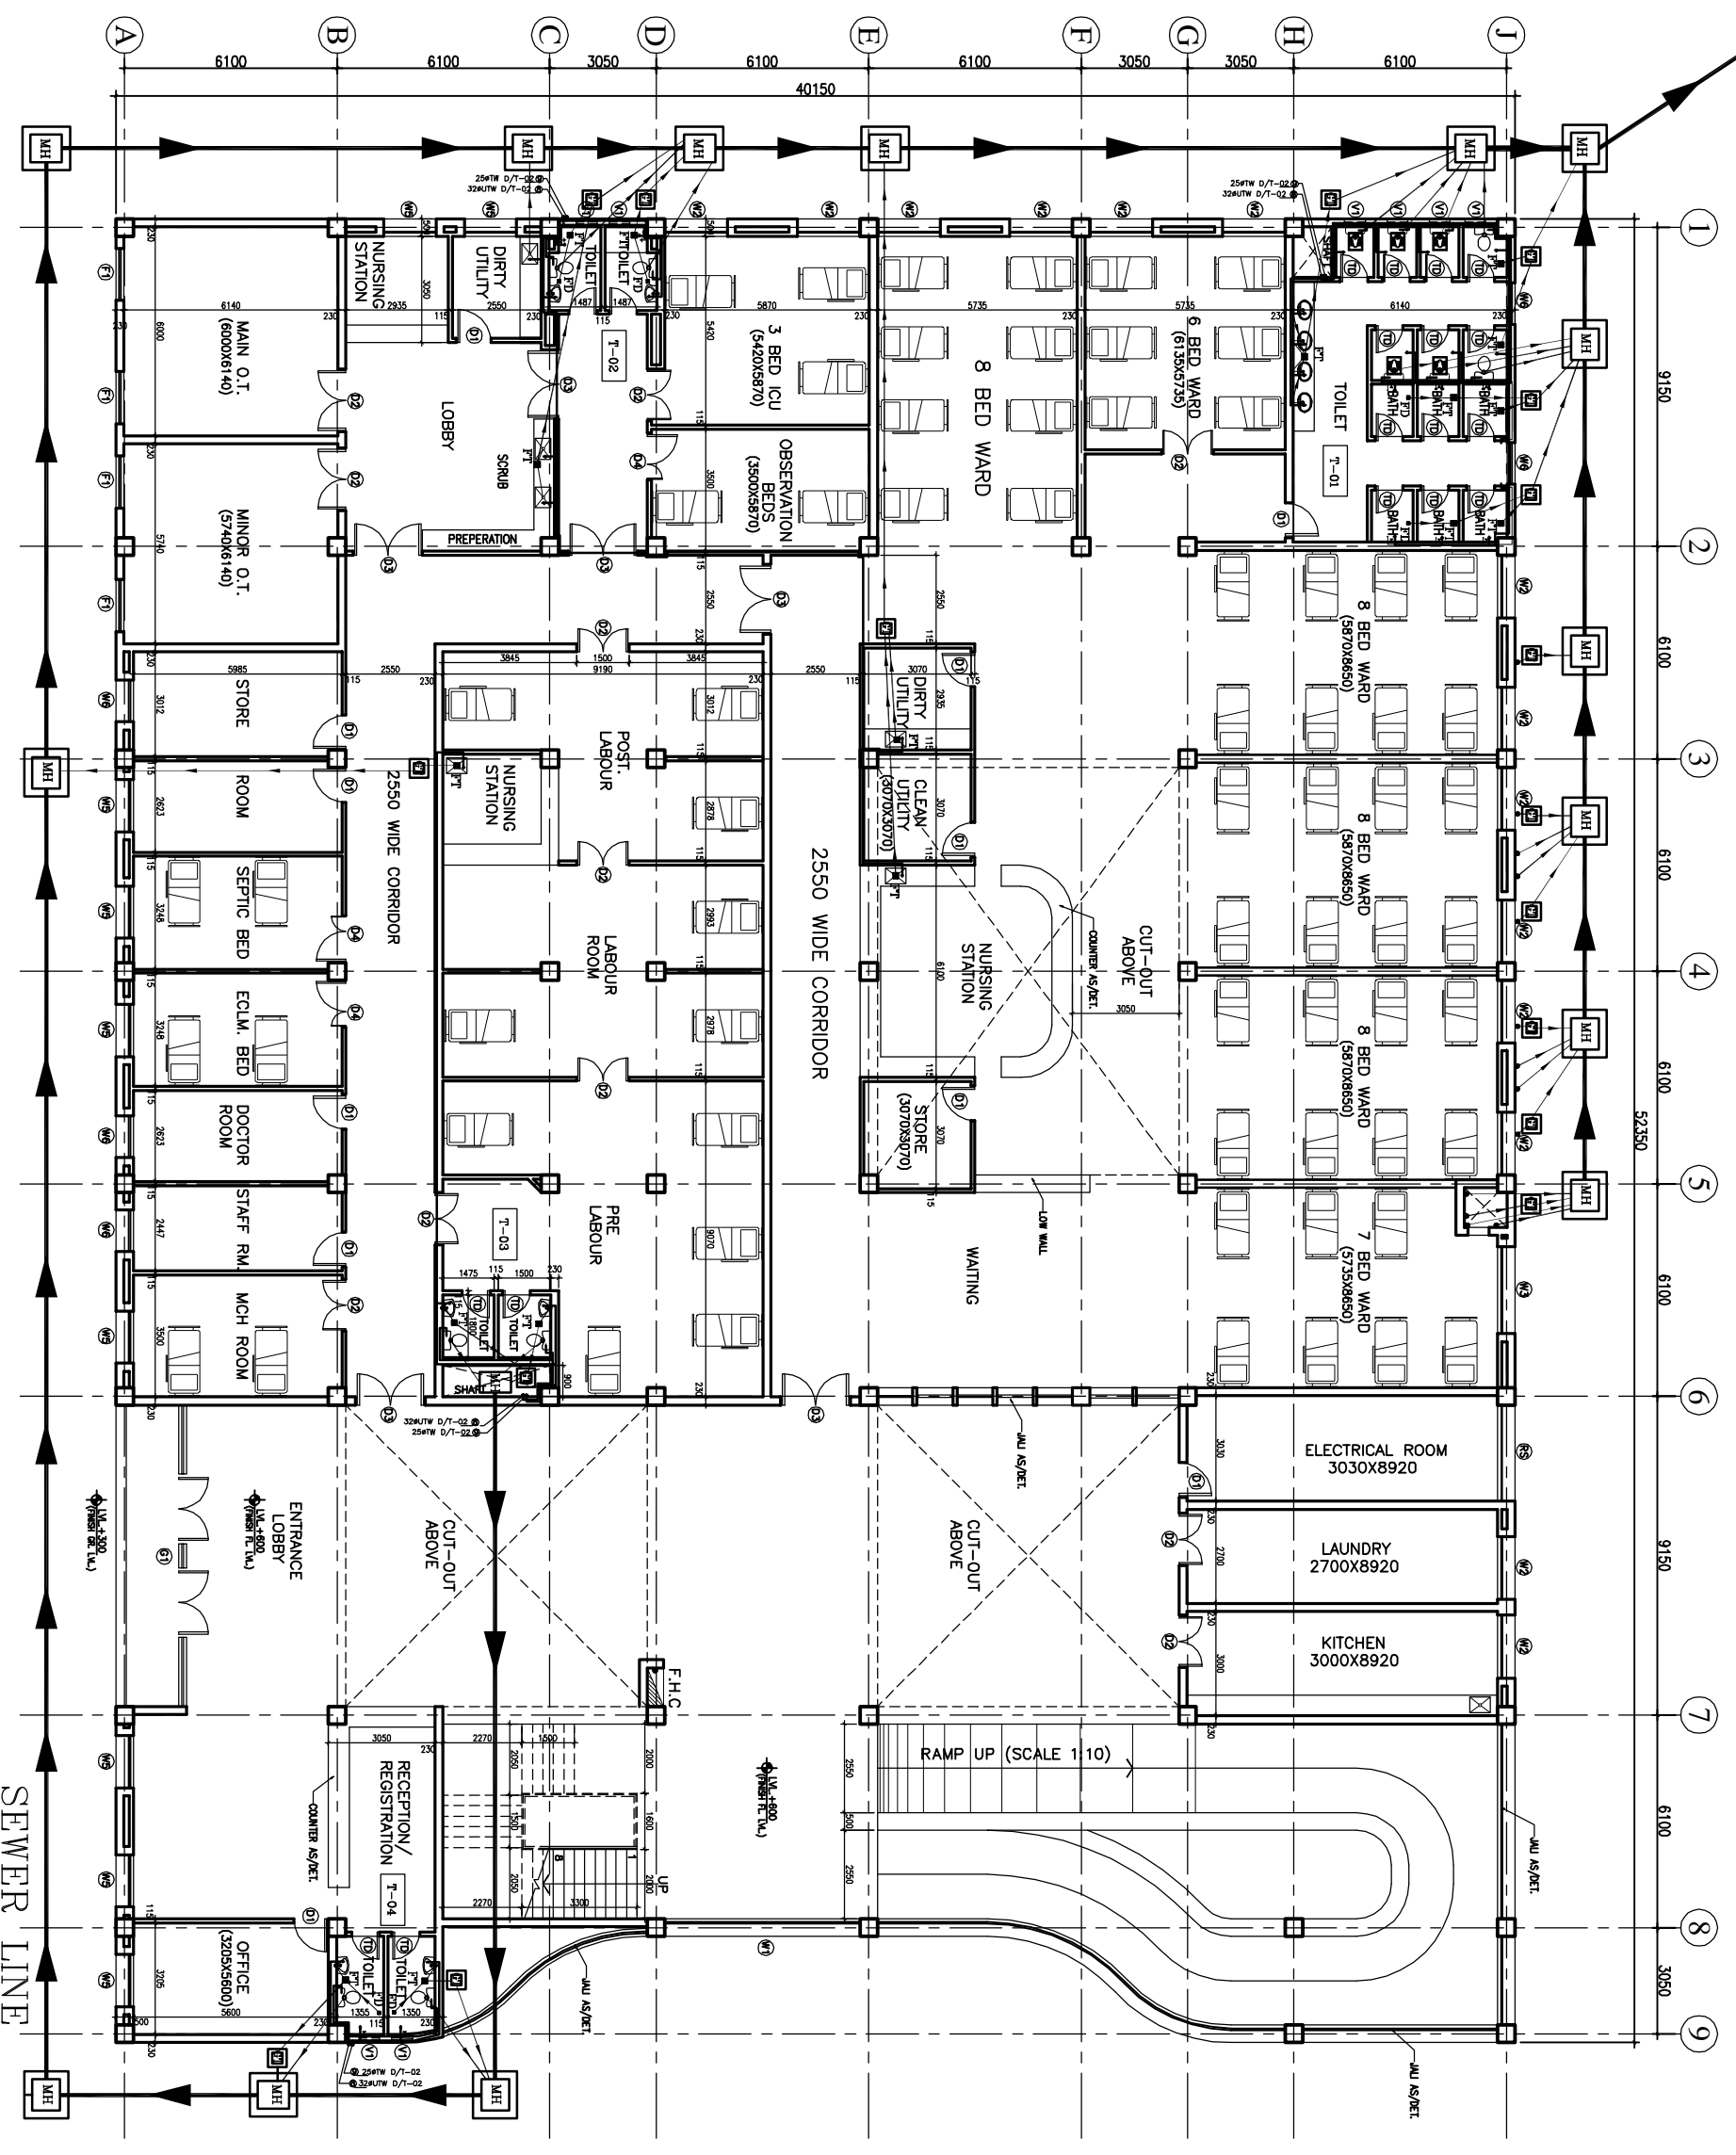

1. BASED ON THIS DRAWING EXECUTING AGENCY WILL PREPARE SHOP DRAWING AFTER INCORPORATING THE CHANGES AS PER SITE CONDITION FOR THE APPROVAL OF ENGINEER-IN-CHARGE BEFORE START OF WORK.
 2. THE NO. & LOCATION OF FIXTURES TO BE FINALIZED BEFORE EXECUTION WITH MEDICAL IN-CHARGE OF PROJECT.

This drawing with all its contents is the sole intellectual property of the Consulting Corporation (I) and its Copying of this drawing or part thereof for any purpose without the written permission of HSCC is prohibited.

LEVELING.

1	100 Ø CI SOIL & VENT PIPE
2	100Ø CI WASTE & VENT PIPE
3	100Ø CI SOIL PIPE
4	100Ø CI WASTE PIPE
5	50Ø UPVC SOIL PIPE
6	40Ø UPVC WASTE PIPE
7	32Ø UPVC WASTE PIPE
8	Ø UTW DN. TAKE
9	Ø TW DN. TAKE
10	100 Ø S.W. PIPE
F.T	FLOOR TRAP 100X100
F.D	FLOOR DRAIN 50Ø
FOO	FLOOR CLEAN OUT
COP	CLEAN OUT PLUG
×	VALVE
MH	MANHOLE (900Ø/80)mm
GT	GULLY TRAP (300X300)mm


REV. DATE	DESCRIPTION

PROJECT
 RMNCH PROJECT
 Proposed 50 Bedded Hospital (G+1) of CHATTISGARH

TITLE - PLUMBING & FIRE TENDER DRAWING

Drawing No. HSCC/D&E/BM/ET/TA/TA/TP/L-01	
Job No.	Scale
App by	Rev. by
	Prep. by

HSCC
 HSCC (INDIA) LIMITED
 (A GOVERNMENT OF INDIA ENTERPRISE)
 NEW DELHI

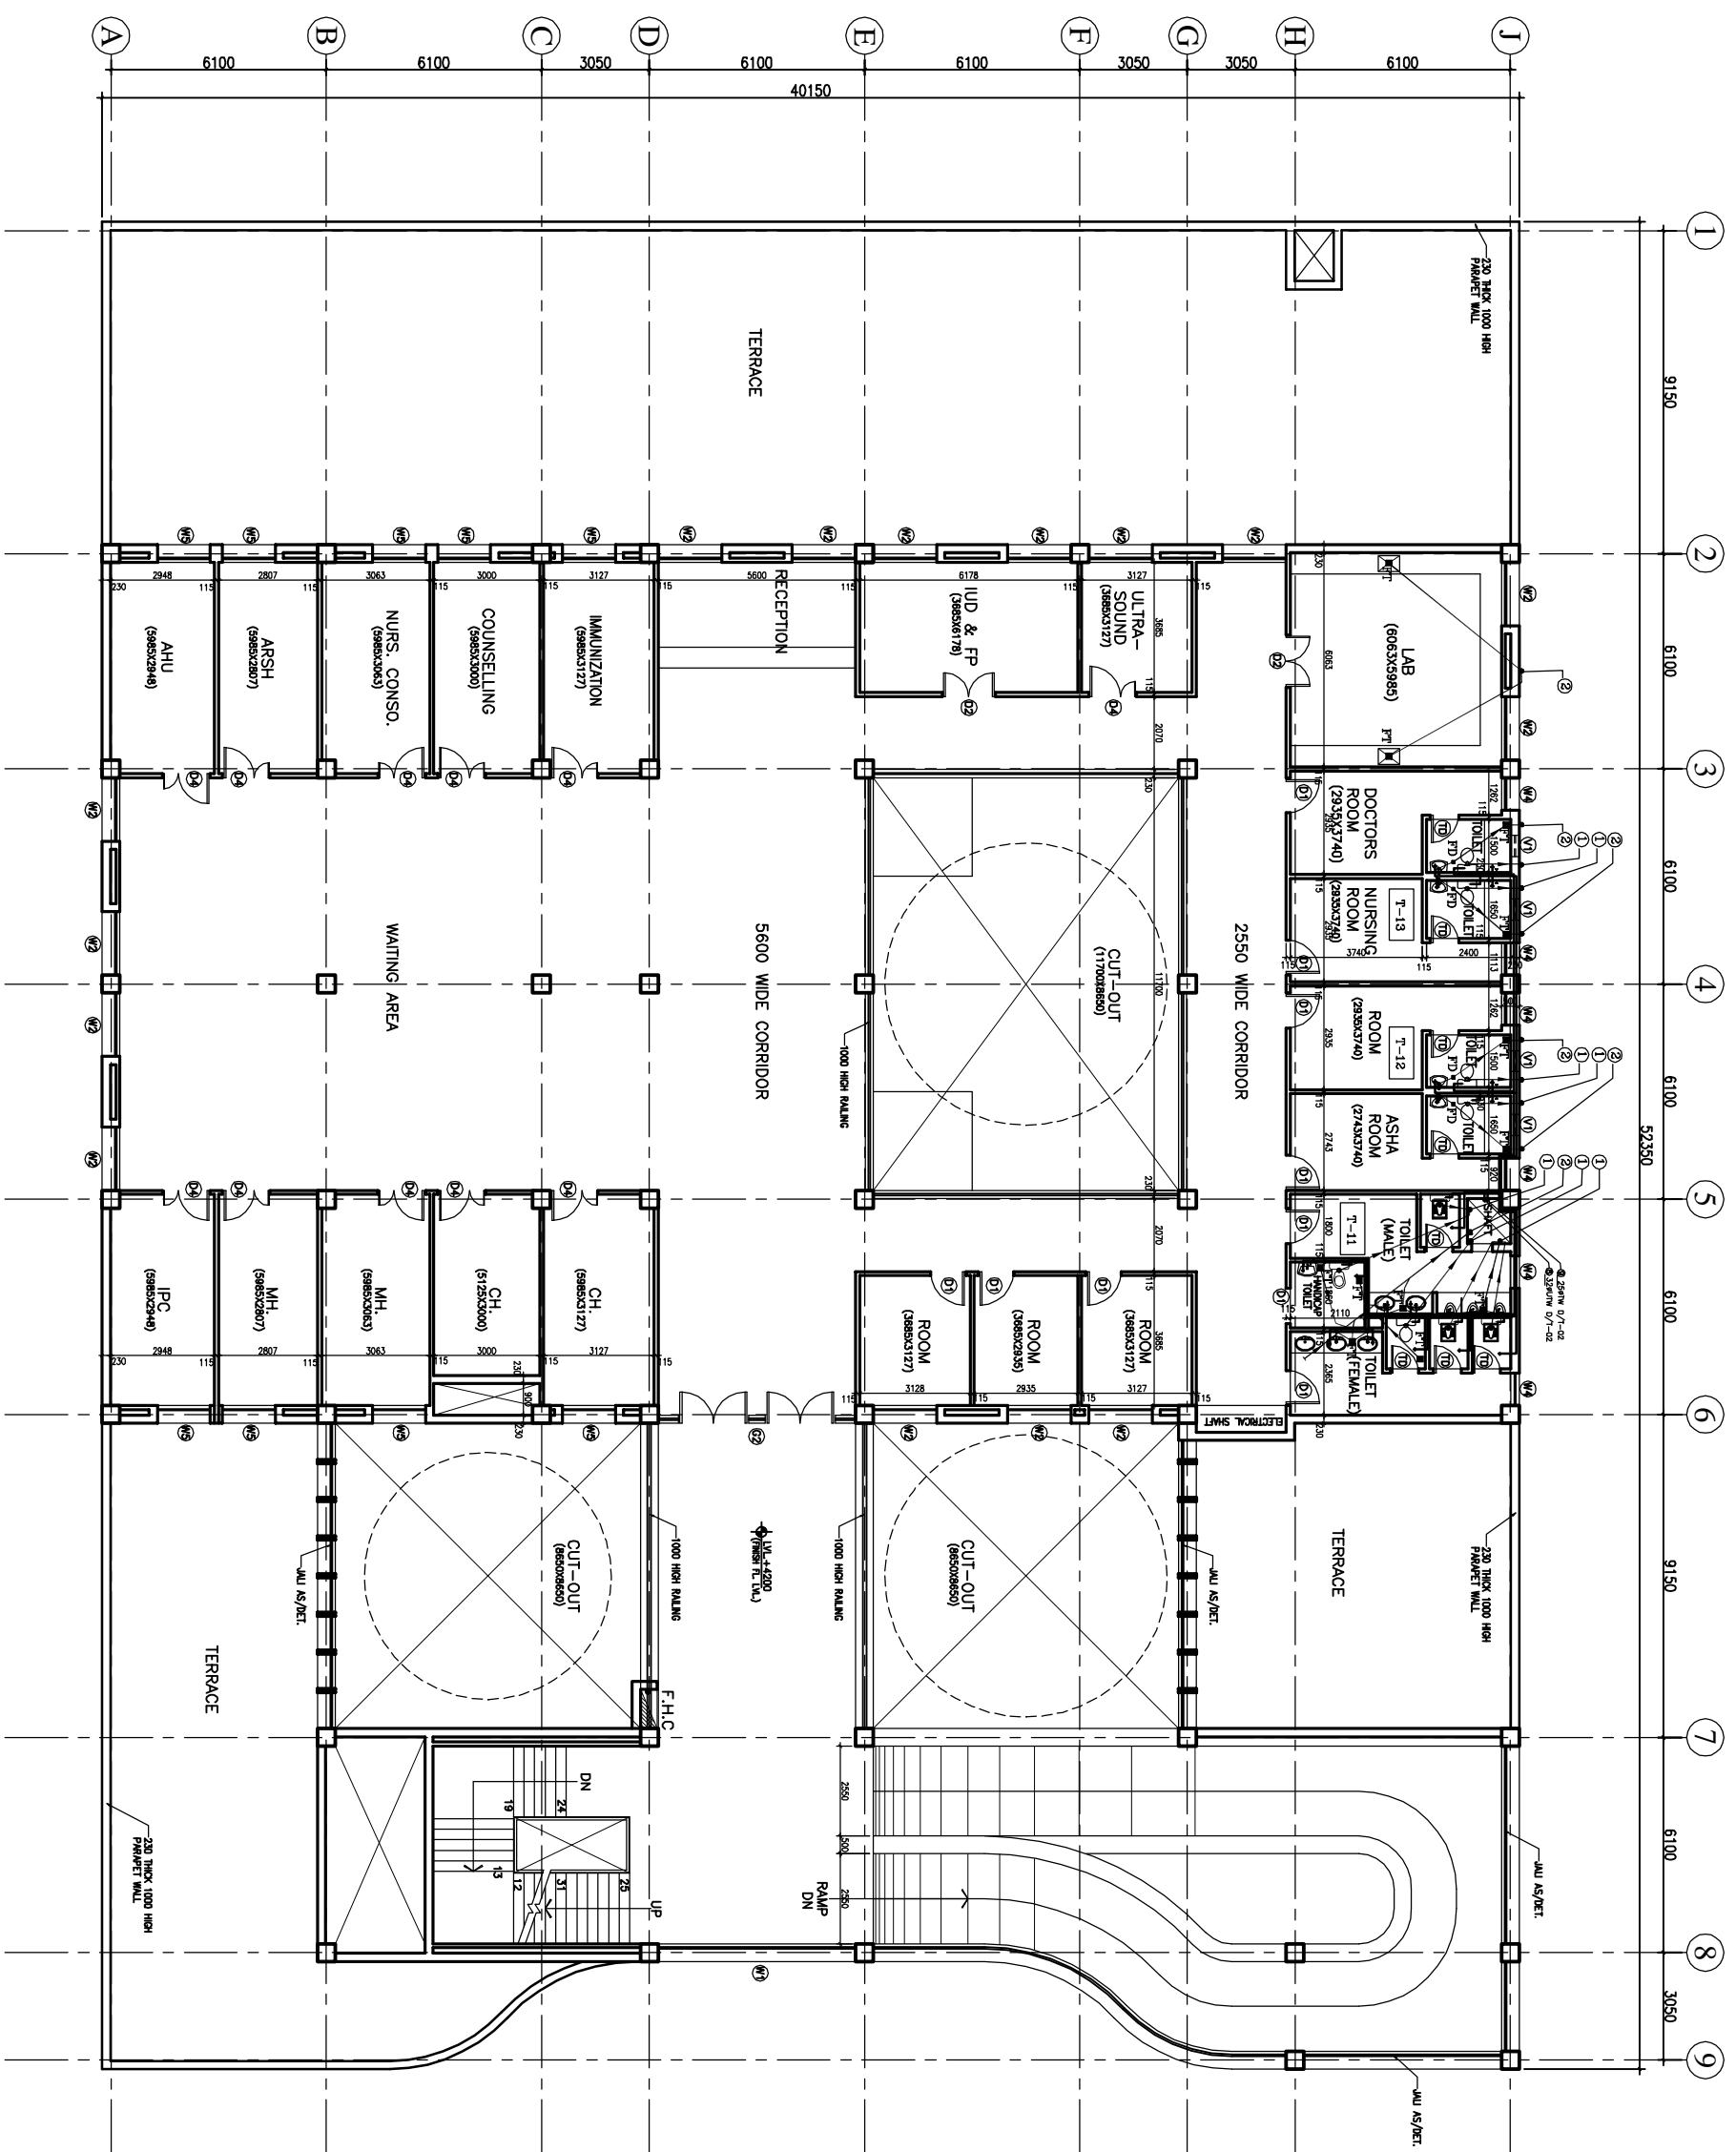

1. BASED ON THIS DRAWING EXECUTING AGENCY WILL PREPARE SHOP DRAWING AFTER INCORPORATING THE CHANGES AS PER SITE CONDITION FOR THE APPROVAL OF ENGINEER-IN-CHARGE BEFORE START OF WORK.
 2. THE NO. & LOCATION OF FIXTURES TO BE FINALIZED BEFORE EXECUTION WITH MEDICAL IN-CHARGE OF PROJECT.

This drawing with all its contents is the sole intellectual property of the Consulting Corporation (and) its Copying of this drawing or part thereof for any purpose without the written permission of HSCC is prohibited.

NOTES

LEVEL U.

1	100 Ø CI SOIL & VENT PIPE
2	100Ø CI WASTE & VENT PIPE
3	100Ø CI SOIL PIPE
4	100Ø CI WASTE PIPE
5	50Ø UPVC SOIL PIPE
6	40Ø UPVC WASTE PIPE
7	32Ø UPVC WASTE PIPE
8	Ø UTW DNTAKE
9	Ø TW DNTAKE
10	100 Ø S.W. PIPE
F.T	FLOOR TRAP 100x100
F.D	FLOOR DRAIN 50Ø
F.O	FLOOR CLEAN OUT
COF	CLEAN OUT PLUG
Ø	VALVE
MH	MANHOLE (900x800)mm
GT	GULLY TRAP (300x300)mm

REV.	DATE	DESCRIPTION


PROJECT
 RMNCH PROJECT
 Proposed 50 Bedded Hospital (G+1) of CHATTISGARH

TITLE - PLUMBING & FIRE TENDER DRAWING

First Floor Plan		
HSCC/D&E/BANM/TARA/TP-02		
Drawing No.		
Job No.	Scale	Date
App by	Rev. by	Prep. by

1. BASED ON THIS DRAWING EXECUTING AGENCY WILL PREPARE SHOP DRAWING AFTER INCORPORATING THE CHANGES AS PER SITE CONDITION FOR THE APPROVAL OF ENGINEER-IN-CHARGE BEFORE START OF WORK.
 2. THE NO. & LOCATION OF FIXTURES TO BE FINALIZED BEFORE EXECUTION WITH MEDICAL IN-CHARGE OF PROJECT.

This drawing with all its contents is the sole intellectual property of the Consulting Corporation (I) and Ltd. Copying of this drawing or part thereof for any purpose without the written permission of HSCC is prohibited.

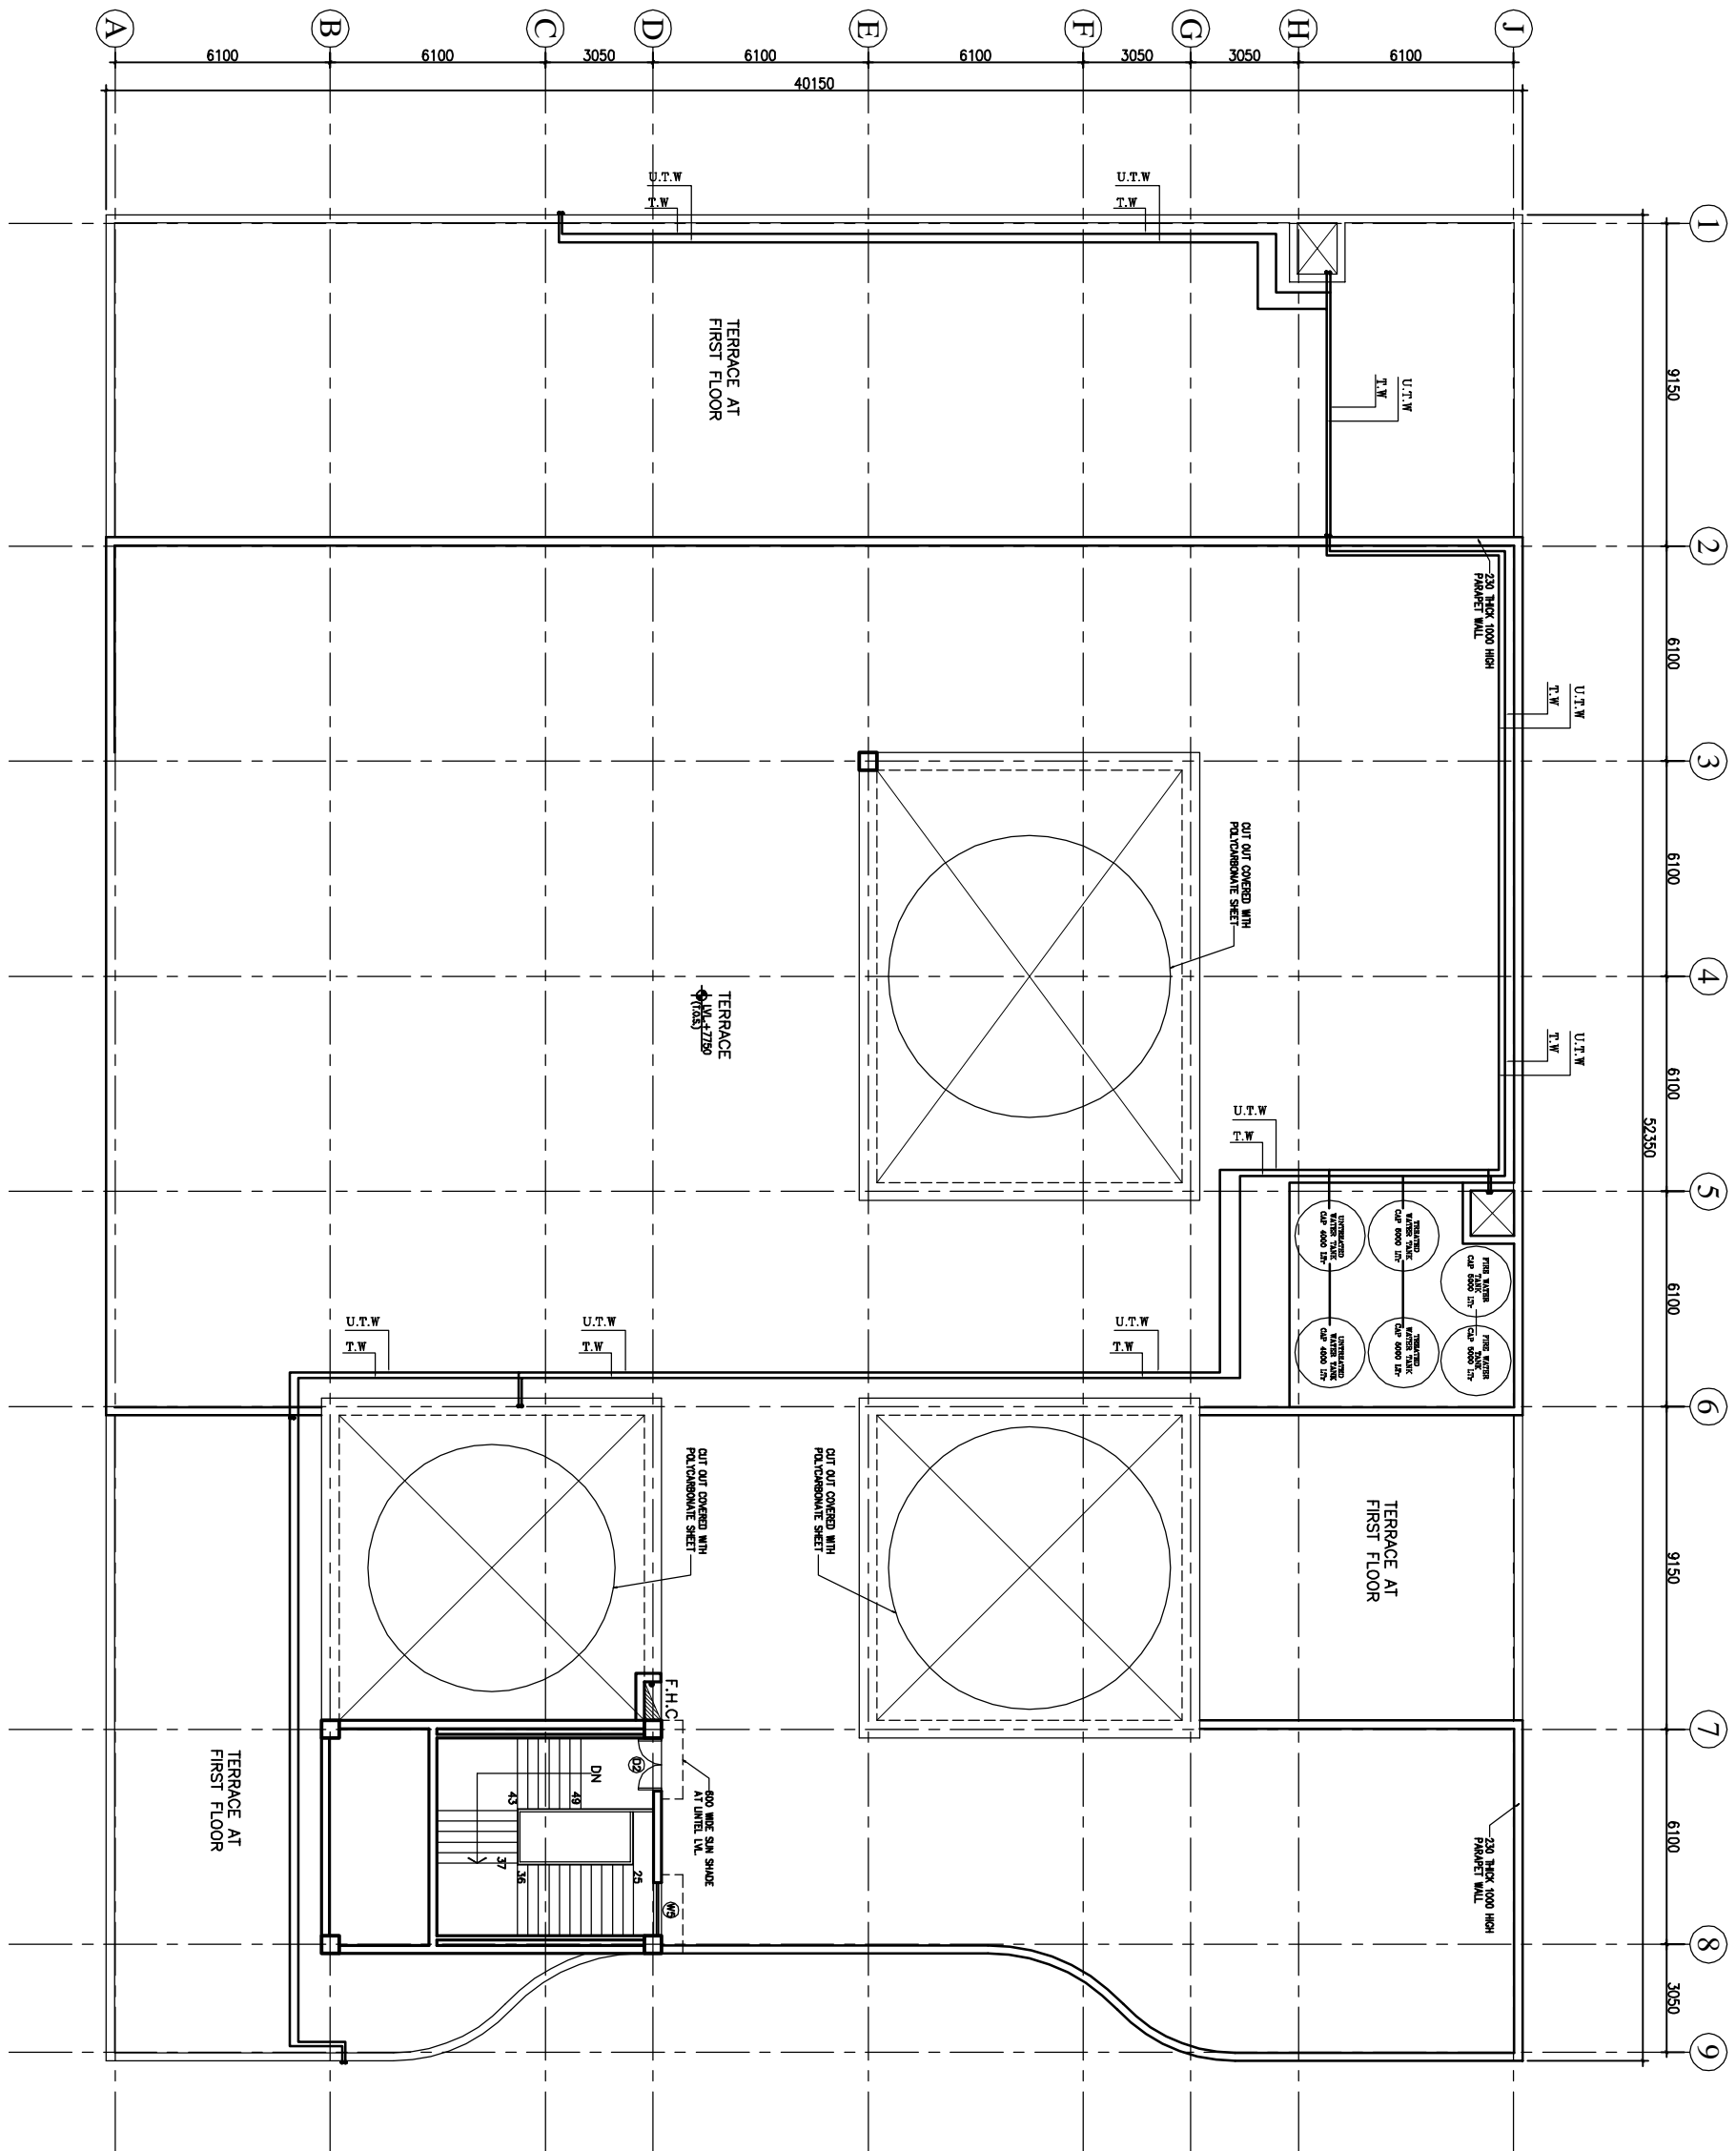

LEVEL U.

1	100 Ø CI SOIL & VENT PIPE
2	100Ø CI WASTE & VENT PIPE
3	100Ø CI SOIL PIPE
4	100Ø CI WASTE PIPE
5	50Ø UPVC SOIL PIPE
6	40Ø UPVC WASTE PIPE
7	32Ø UPVC WASTE PIPE
8	Ø UTW DN TAKE
9	Ø TW DN TAKE
10	100 Ø S.W. PIPE
F.T	FLOOR TRAP 100X100
F.D	FLOOR DRAIN 50Ø
F.O	FLOOR CLEAN OUT
COP	CLEAN OUT PLUG
×	VALVE
MH	MANHOLE (900x600)mm
GT	GULLY TRAP (300X300)mm

REV	DATE	DESCRIPTION

PROJECT
 RMNCH PROJECT
 Proposed 50 Bedded
 Hospital (G+1) of
 CHATTISGARH

**TITLE - PLUMBING & FIRE
 TENDER DRAWING**

Terrace
 Plcn

HSCC/D&E/BNA/ET/BA/TD/PL-03
 Drawing No.


Job No.	Scale	Date
App by	Rev. by	Prep. by

ELECTRICAL

DRAWINGS

A B C D E F G H J

1 2 3 4 5 6 7 8 9

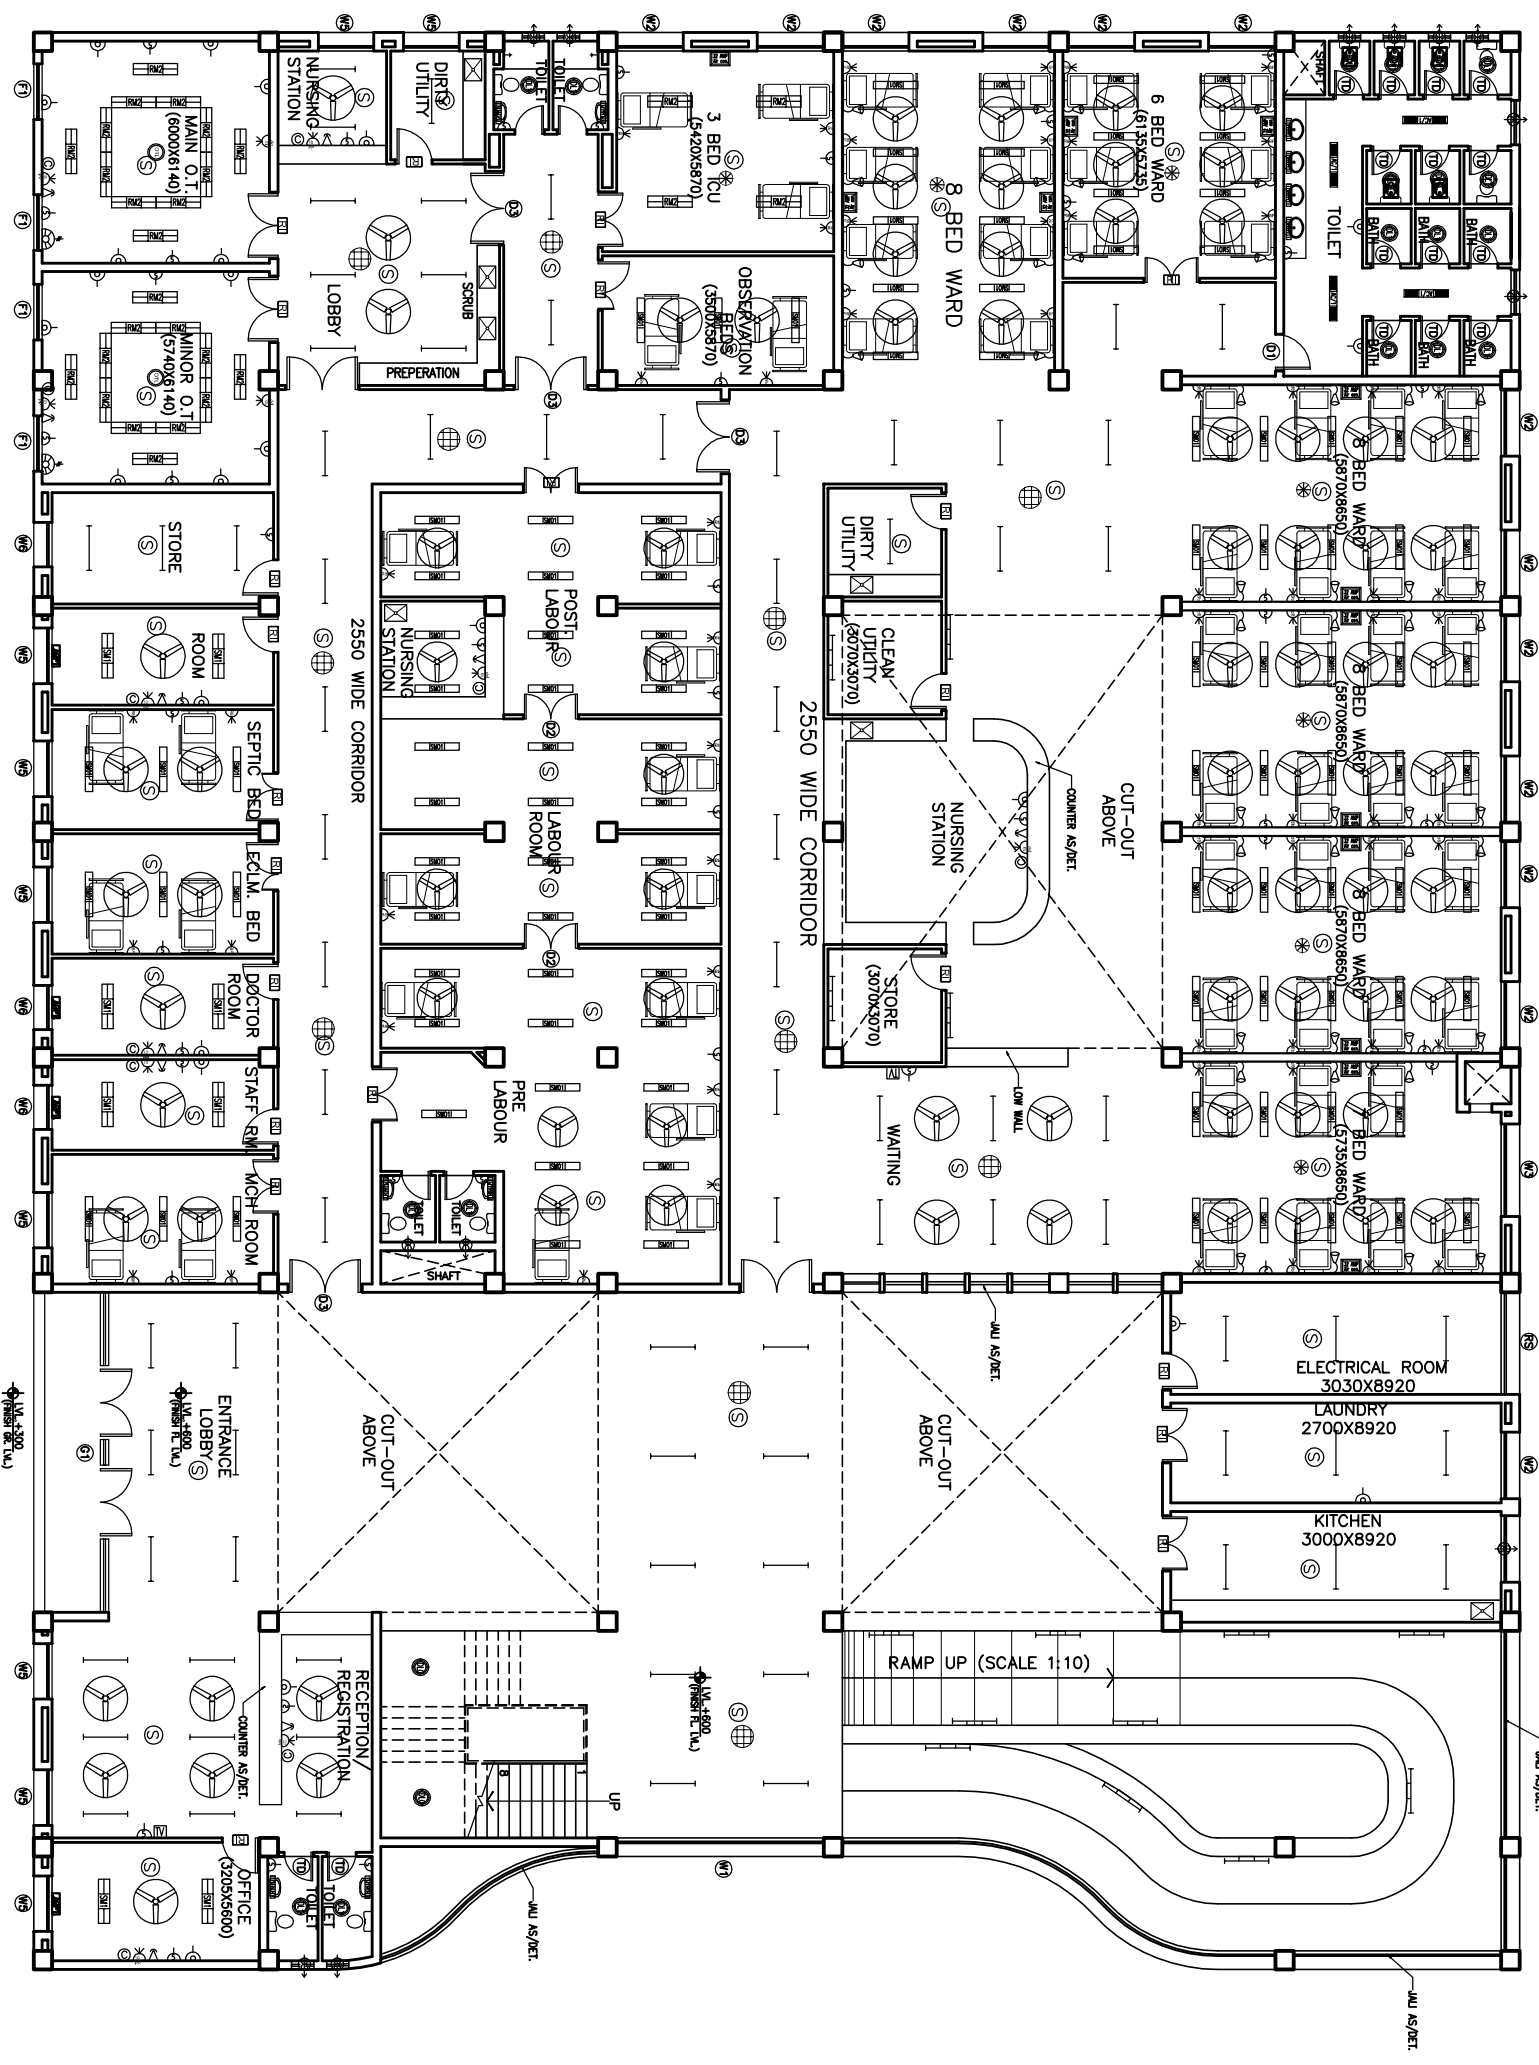

GROUND FLOOR PLAN


NOTES

The drawing with all its contents is the property of the Hospital Services Corporation (HSCC) Ltd. Copying of this drawing for any other use without the written permission of HSCC is prohibited.

PROJECT	RMNCH PROJECT
PROPOSED	Proposed 50 Bedded Hospital of CHATTISGARH
TITLE	MODEL PLANS (G+1) TENDER DRAWING Ground Floor Plan ELECTRICAL LAYOUT (COVERED AREA=2050 SQ. MT.)
Drawing No.	HSCC/D&E/CHATTISGARH/DEL-01 R-0
Scale	1:50
Date	
App. by	Rev. by
Prep. by	

1 2 3 4 5 6 7 8 9

A B C D E F G H J

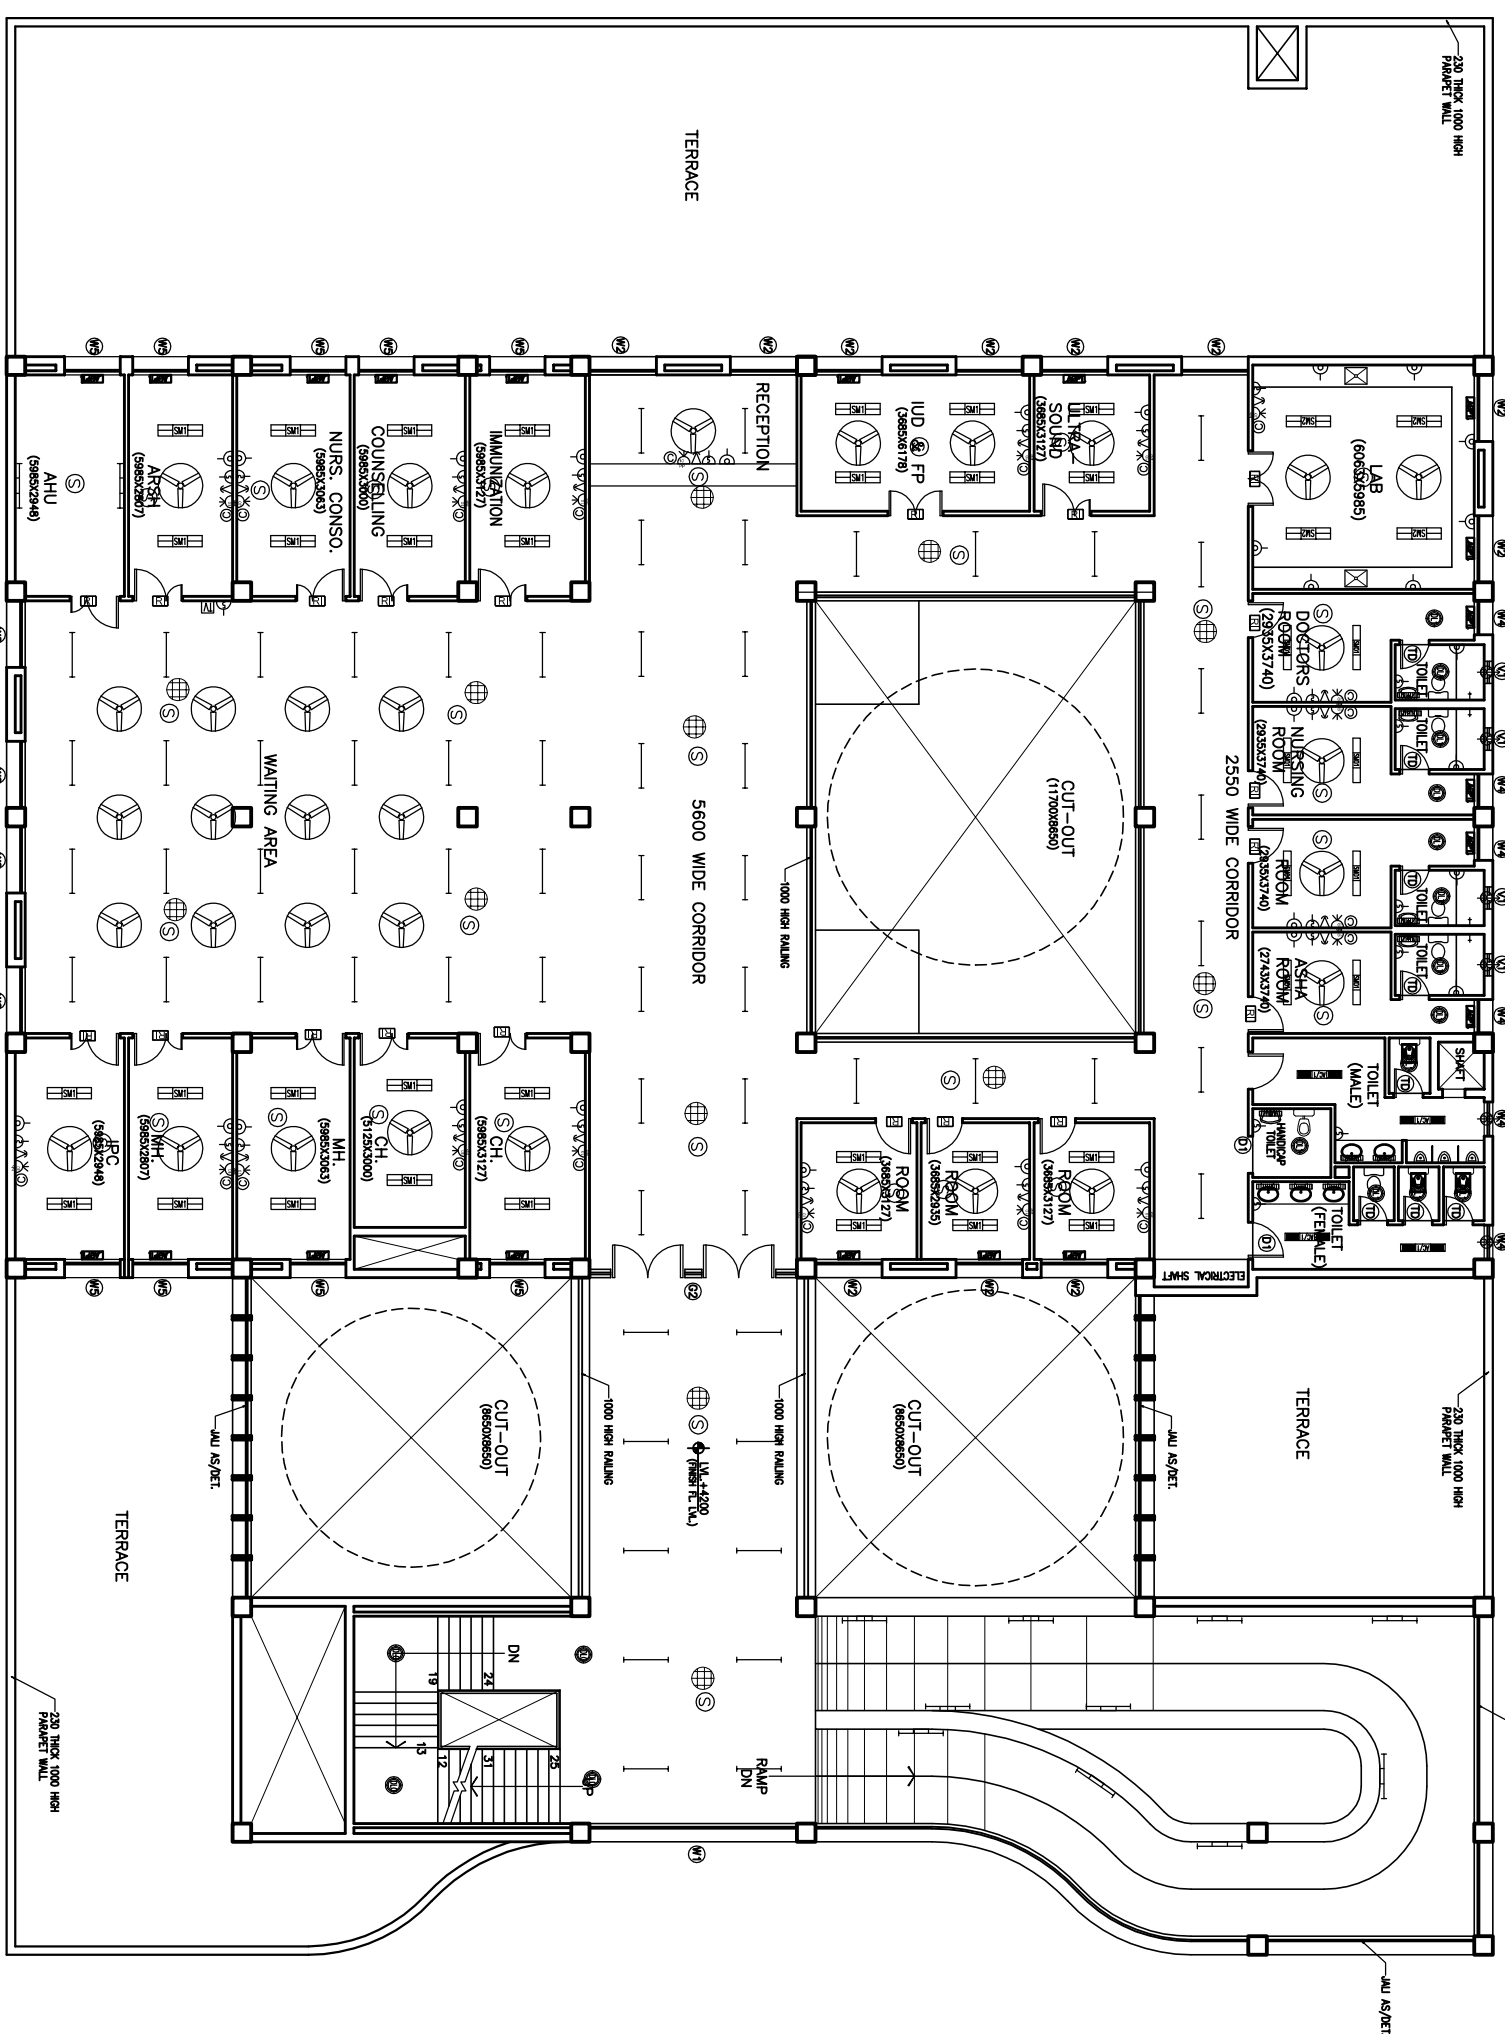


FIRST FLOOR PLAN

NOTES

The drawing with all its contents and any other information is the property of the Consultant. No part of this drawing may be copied, reproduced, or used in any form without the written permission of HSCC. If prohibited.

PROJECT			
RMNCH PROJECT			
Proposed 50 Bedded Hospital of CHATTISGARH			
TITLE			
MODEL PLANS (G+1) TENDER DRAWING First Floor Plan ELECTRICAL LAYOUT (COVERED AREA=1035 SQ. MT.)			
HSCC/D&E/CHATTISGARH/TD/EL-02 R-0			
Drawing No.			
HSCC/Scale		Date	
App by		Rev by	
Prep. by			

- 1 2 3 4 5 6 7 8 9

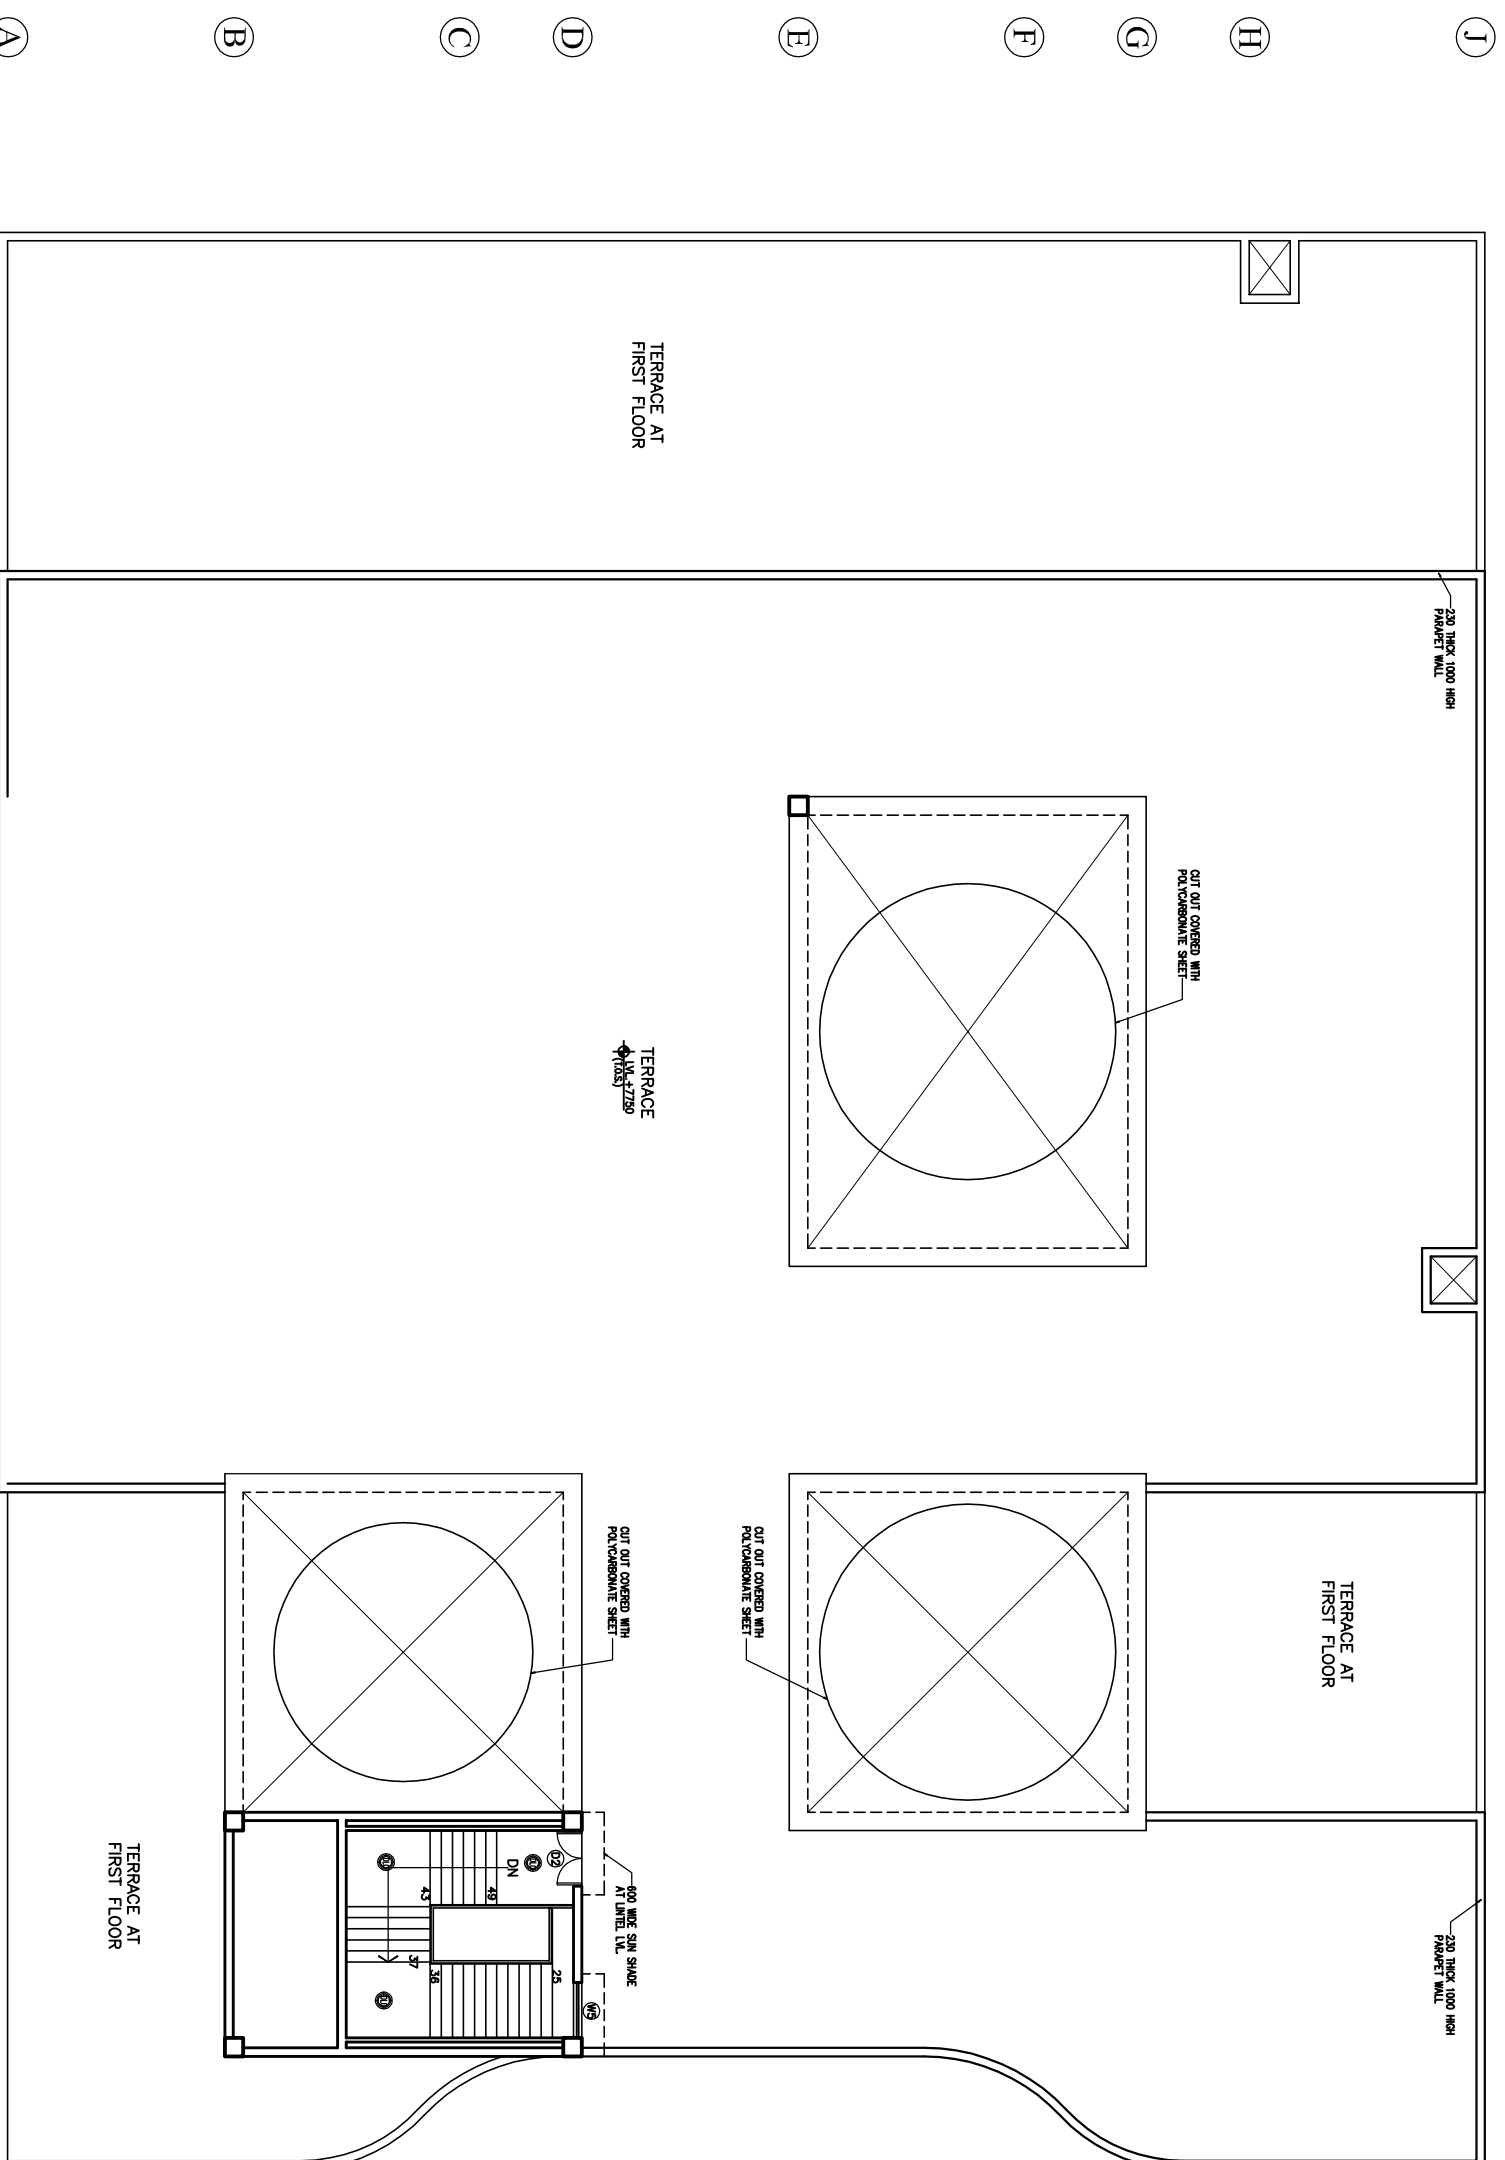

TERRACE PLAN

The drawing with all its contents is the sole property of the Hospital Services Authority of the Government of India. Copying or reproduction in any form without the written permission of HSCC is prohibited.

NOTES


REV	DATE	DESCRIPTION

PROJECT
 RMNCH PROJECT
 Proposed
 50 Bedded Hospital
 of
 CHATTISGARH

TITLE
 MODEL PLANS (G+1)
 TENDER DRAWING
 Terrace Plan
 ELECTRICAL LAYOUT

HSCC/D&E/CHATTISGARH/TD/EL-03 R-0		Drawing No.	
HSCC/-		MNS	
Job No.	Scale	Date	
App. by	Rev. by	Prep. by	

HVAC
DRAWINGS

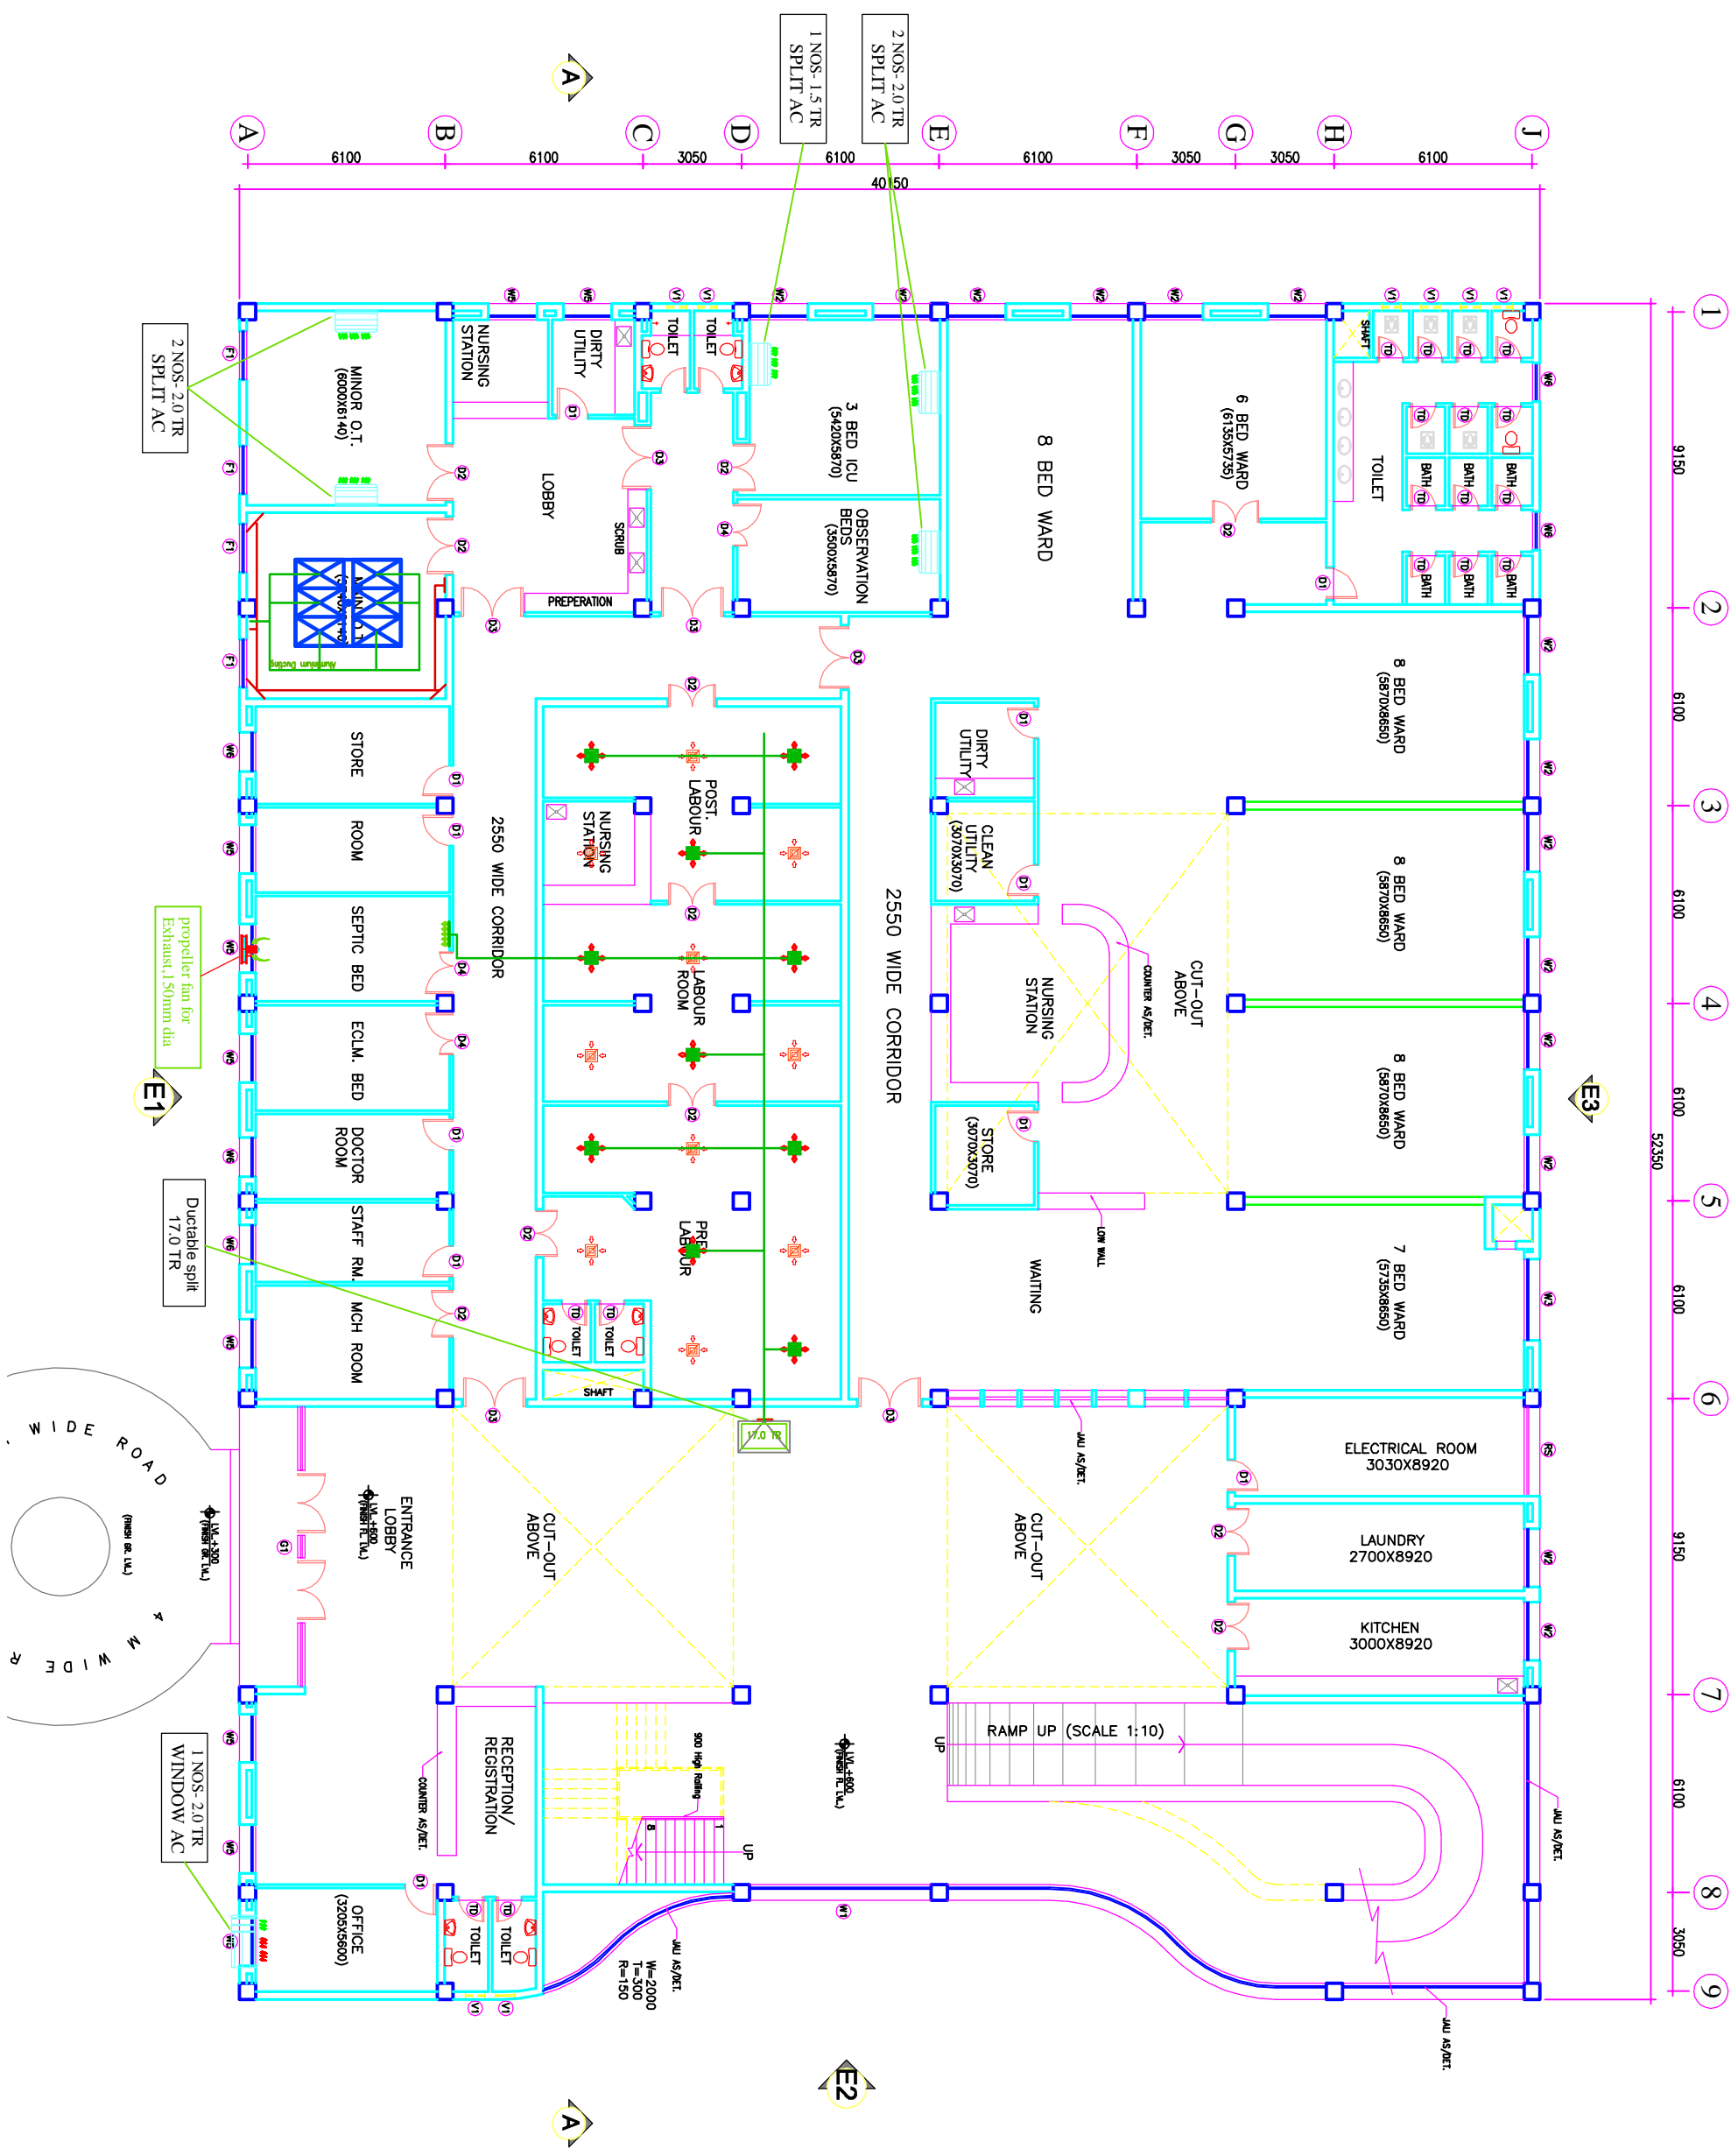

NOTES

The drawing with all its contents is the sole intellectual property of the HSCC (INDIA) LIMITED. Copying of this drawing or part thereof for any purpose without the written permission of HSCC is prohibited.

DOOR AND WINDOW SCHEDULE

SCHEDULE	SIZE	QTY	UNIT	REMARKS
D1	800X2150	000	2150	
2	1000X2150	000	2150	
3	1500X2150	000	2150	DOOR SWITCH
4	2000X2150	000	2150	DOOR SWITCH
5	1500X2150	000	2150	DOOR SWITCH
6	2700X3000	000	3000	BEAM ENTRY
7	8650X3000	0/150	3000	BEAM ENTRY
8	5600X3000	0/150	3000	BEAM ENTRY
W1	1500X2100	900	3000	BEAM ENTRY
W2	1800X2100	900	3000	
W3	2500X2100	900	3000	
W4	920X2100	900	3000	
W5	1500X2100	900	3000	
W6	1500X2100	900	3000	
F1	1500X2150	900	3000	
V1	600X900	1550	2150	

PROJECT
RMNCH PROJECT
Proposed
50 Bedded Hospital
of
CHHATTISGARH

TENDER DRAWING


HSCC/02/BE/RY/AC/NERM/CS-58/AC-01 Rev. R-0
Drawing No. HSCC/02/BE/RY/AC/NERM/CS-58/AC-01 Rev. R-0
Scale 1:100
Date 01-04-2018

App by: _____ Rev. by: _____ Prep. by: _____

TITLE
HVAC LAYOUT
GROUND FLOOR PLAN
(COVERED AREA=2050 SQ. MT.)

REVISION

REV	DATE	DESCRIPTION

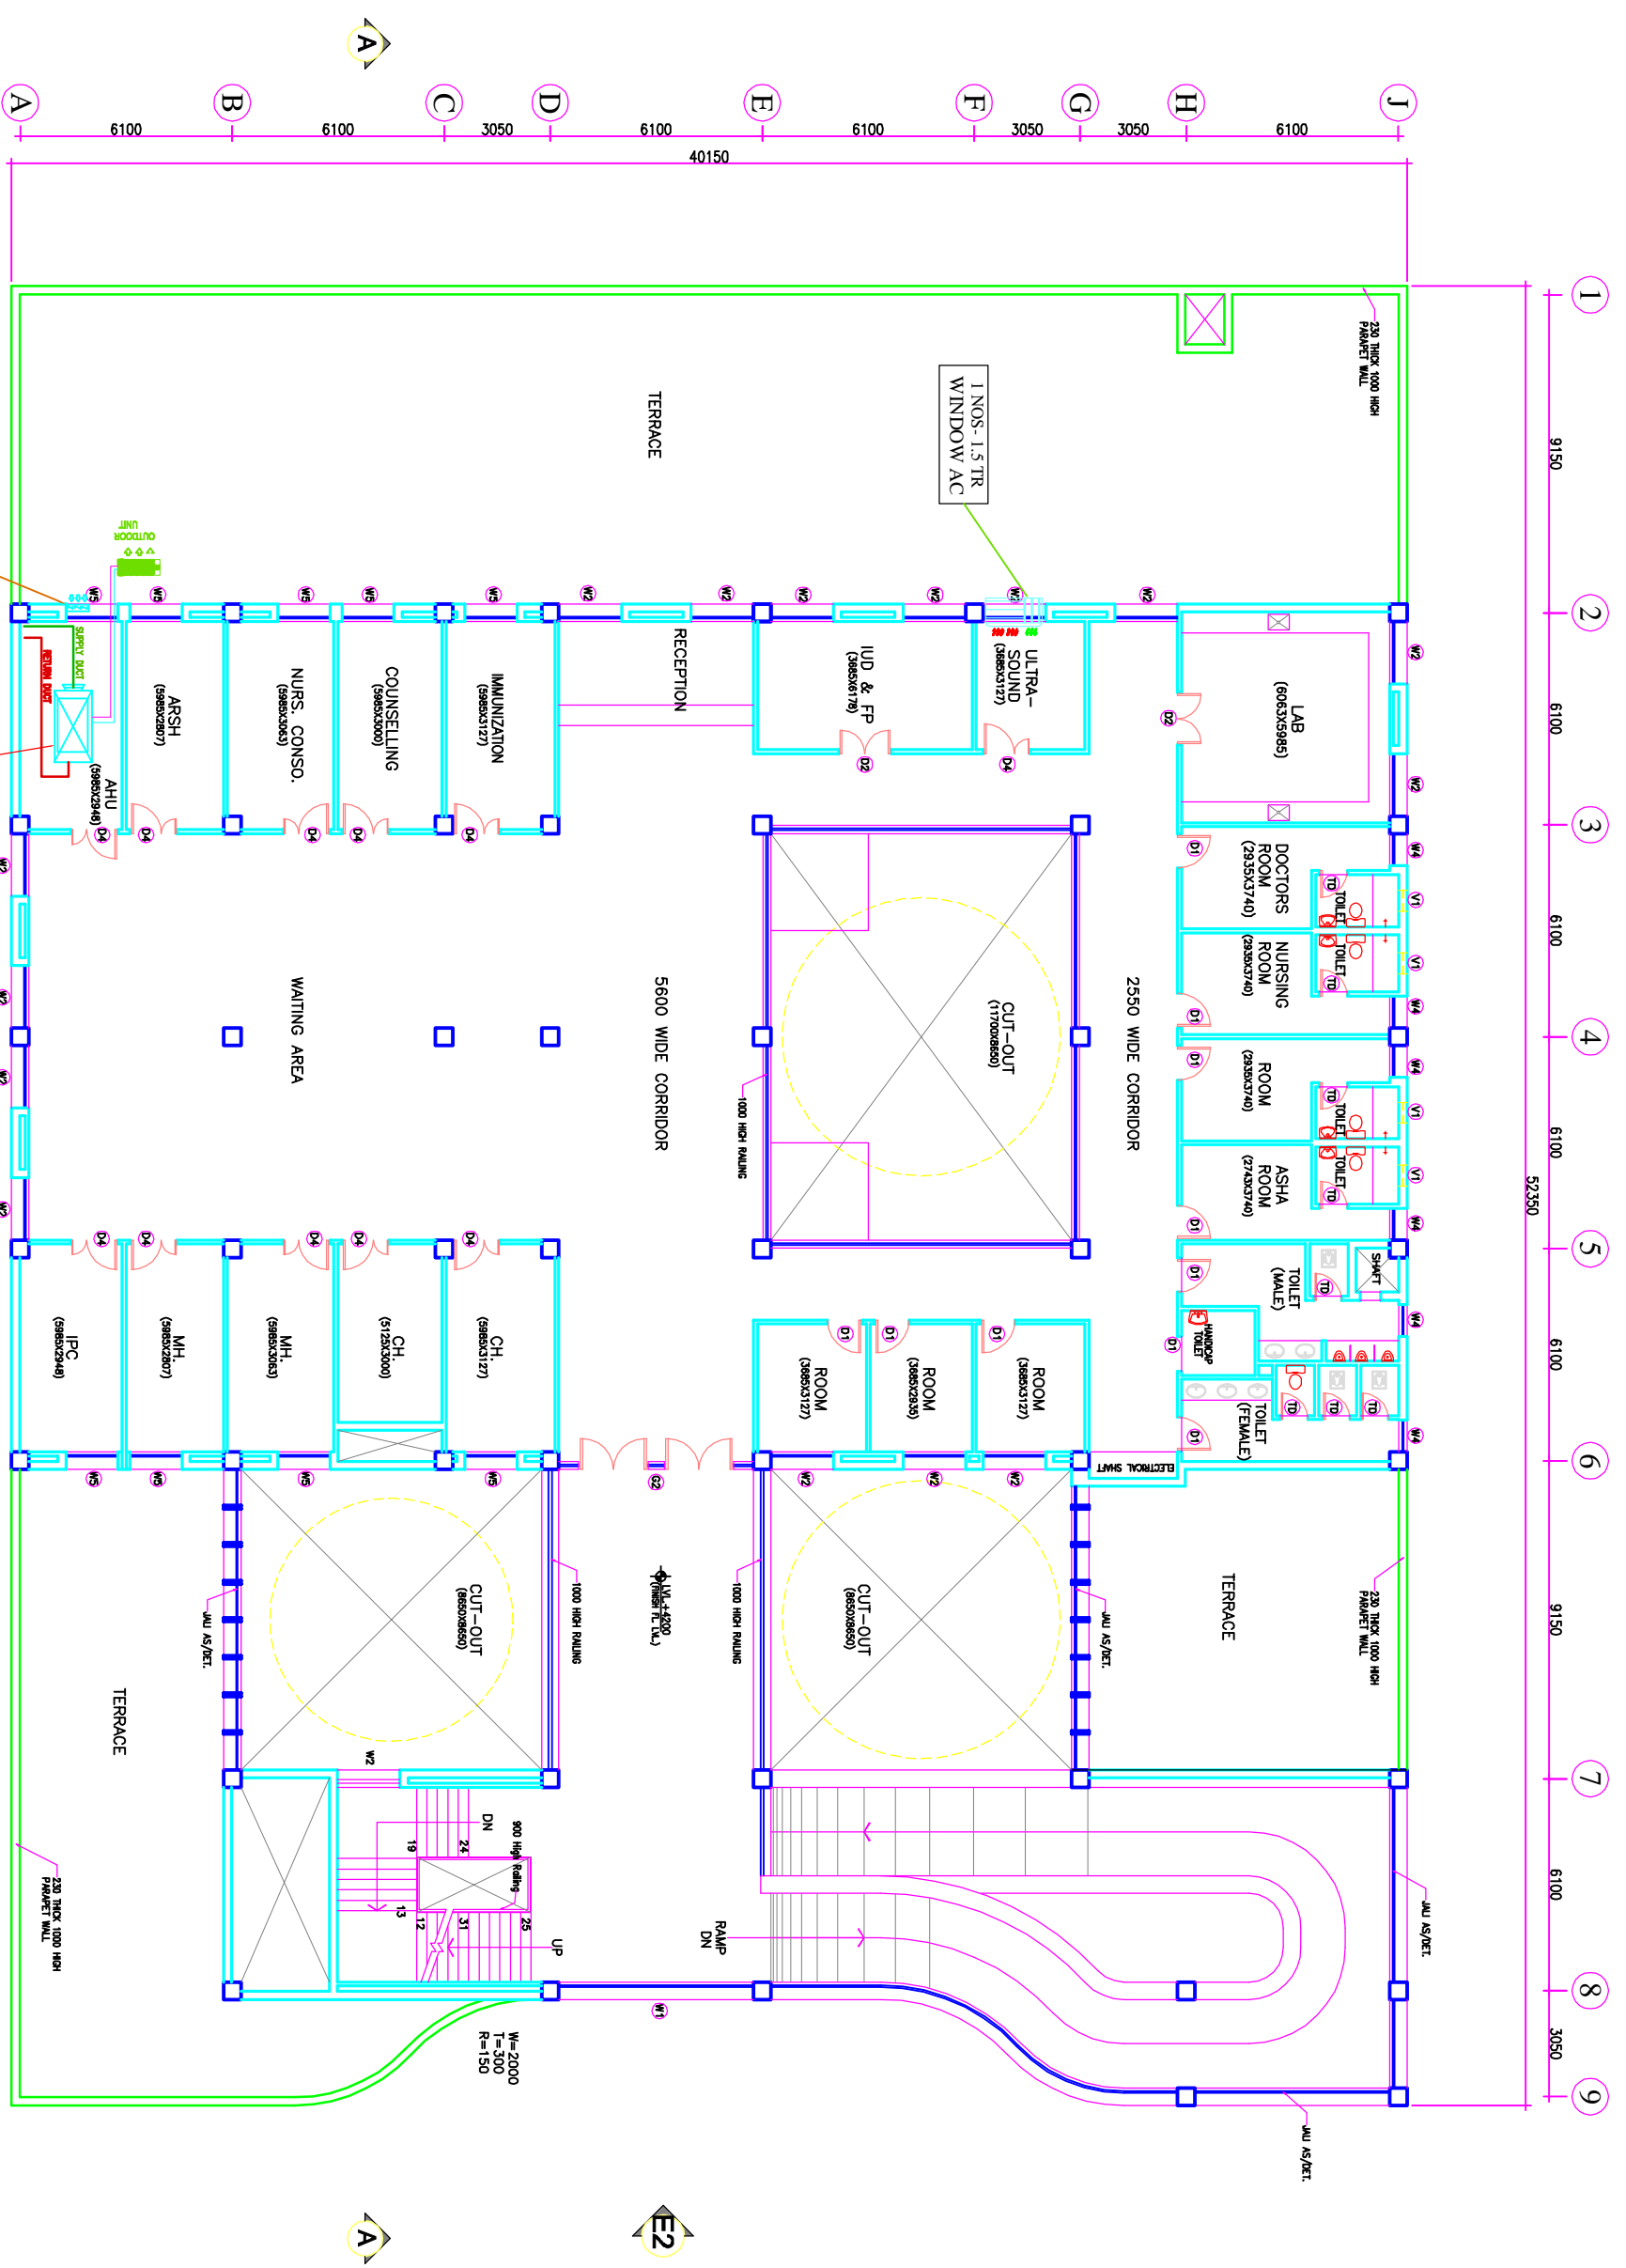

The drawing with all its contents is the sole intellectual property of the Institute of Health Services Consultants & Engineers (India) Ltd. Copying of this drawing or part thereof in any form or by any means without the written permission of IHSCE is prohibited.

NOTES

DOOR AND WINDOW SCHEDULE

SCHEDULE	SIZE	TYPE	UNIT	REMARKS
D1	1000x2150	000	2150	
2	1000x2150	000	2150	DOOR SWITER
3	1500x2150	000	2150	DOOR SWITER
4	2000x2150	000	2150	DOOR SWITER
5	1350x2150	000	2150	DOOR SWITER
6	2750x3000	000	3000	REAR ENTRY
01	8500x3500	0/150	3000	REAR ENTRY
02	5600x3500	0/150	3000	REAR ENTRY
W1	1500x2100	900	3000	REAR ENTRY
W2	1500x2100	900	3000	
W3	2500x2100	900	3000	
W4	9200x2100	900	3000	
W5	1500x2100	900	3000	
W6	1500x2100	900	3000	
F1	1500x2100	900	3000	
V1	600x900	1550	2150	

REV	DATE	DESCRIPTION

PROJECT
RMNCH PROJECT
 Proposed
 50 Bedded Hospital
 of
CHHATTISGARH

TENDER DRAWING
 HSCC (INDIA) LIMITED
 FIRST FLOOR PLAN
 (COVERED AREA=1035 SQ. MT.)

HSCC
 HSCC (INDIA) LIMITED
 (A GOVERNMENT OF INDIA ENTERPRISE)
 NEW DELHI
 INDIA

App by: _____ Rev. by: _____ Prep. by: _____

Scale: 1:100 Date: 01-04-2013