

FIFTH FLOOR
ACADAMIC SECTION
PRIVATE ROOM - 4 BEDS

App by	Rev. by	Prep. by
Job No.	Scale	Date
Drawing No.		
HSCC/D&E/JPH/HS/PL-06		


FIFTH FLOOR PLAN
TENDER DRAWING

PROJECT
PROPOSED
100 BEDED
HOSPITAL
JAUNPUR
(UP)

NORTH

This drawing with all its contents is the sole intellectual property of the Hospital Services Consultancy Corporation (India) Ltd. Copying of this drawing or part thereof for use in any form whatsoever without the written permission of HSCC is prohibited.

HSCC (INDIA) LIMITED
(A GOVERNMENT OF INDIA ENTERPRISE)
NEW DELHI
INDIA

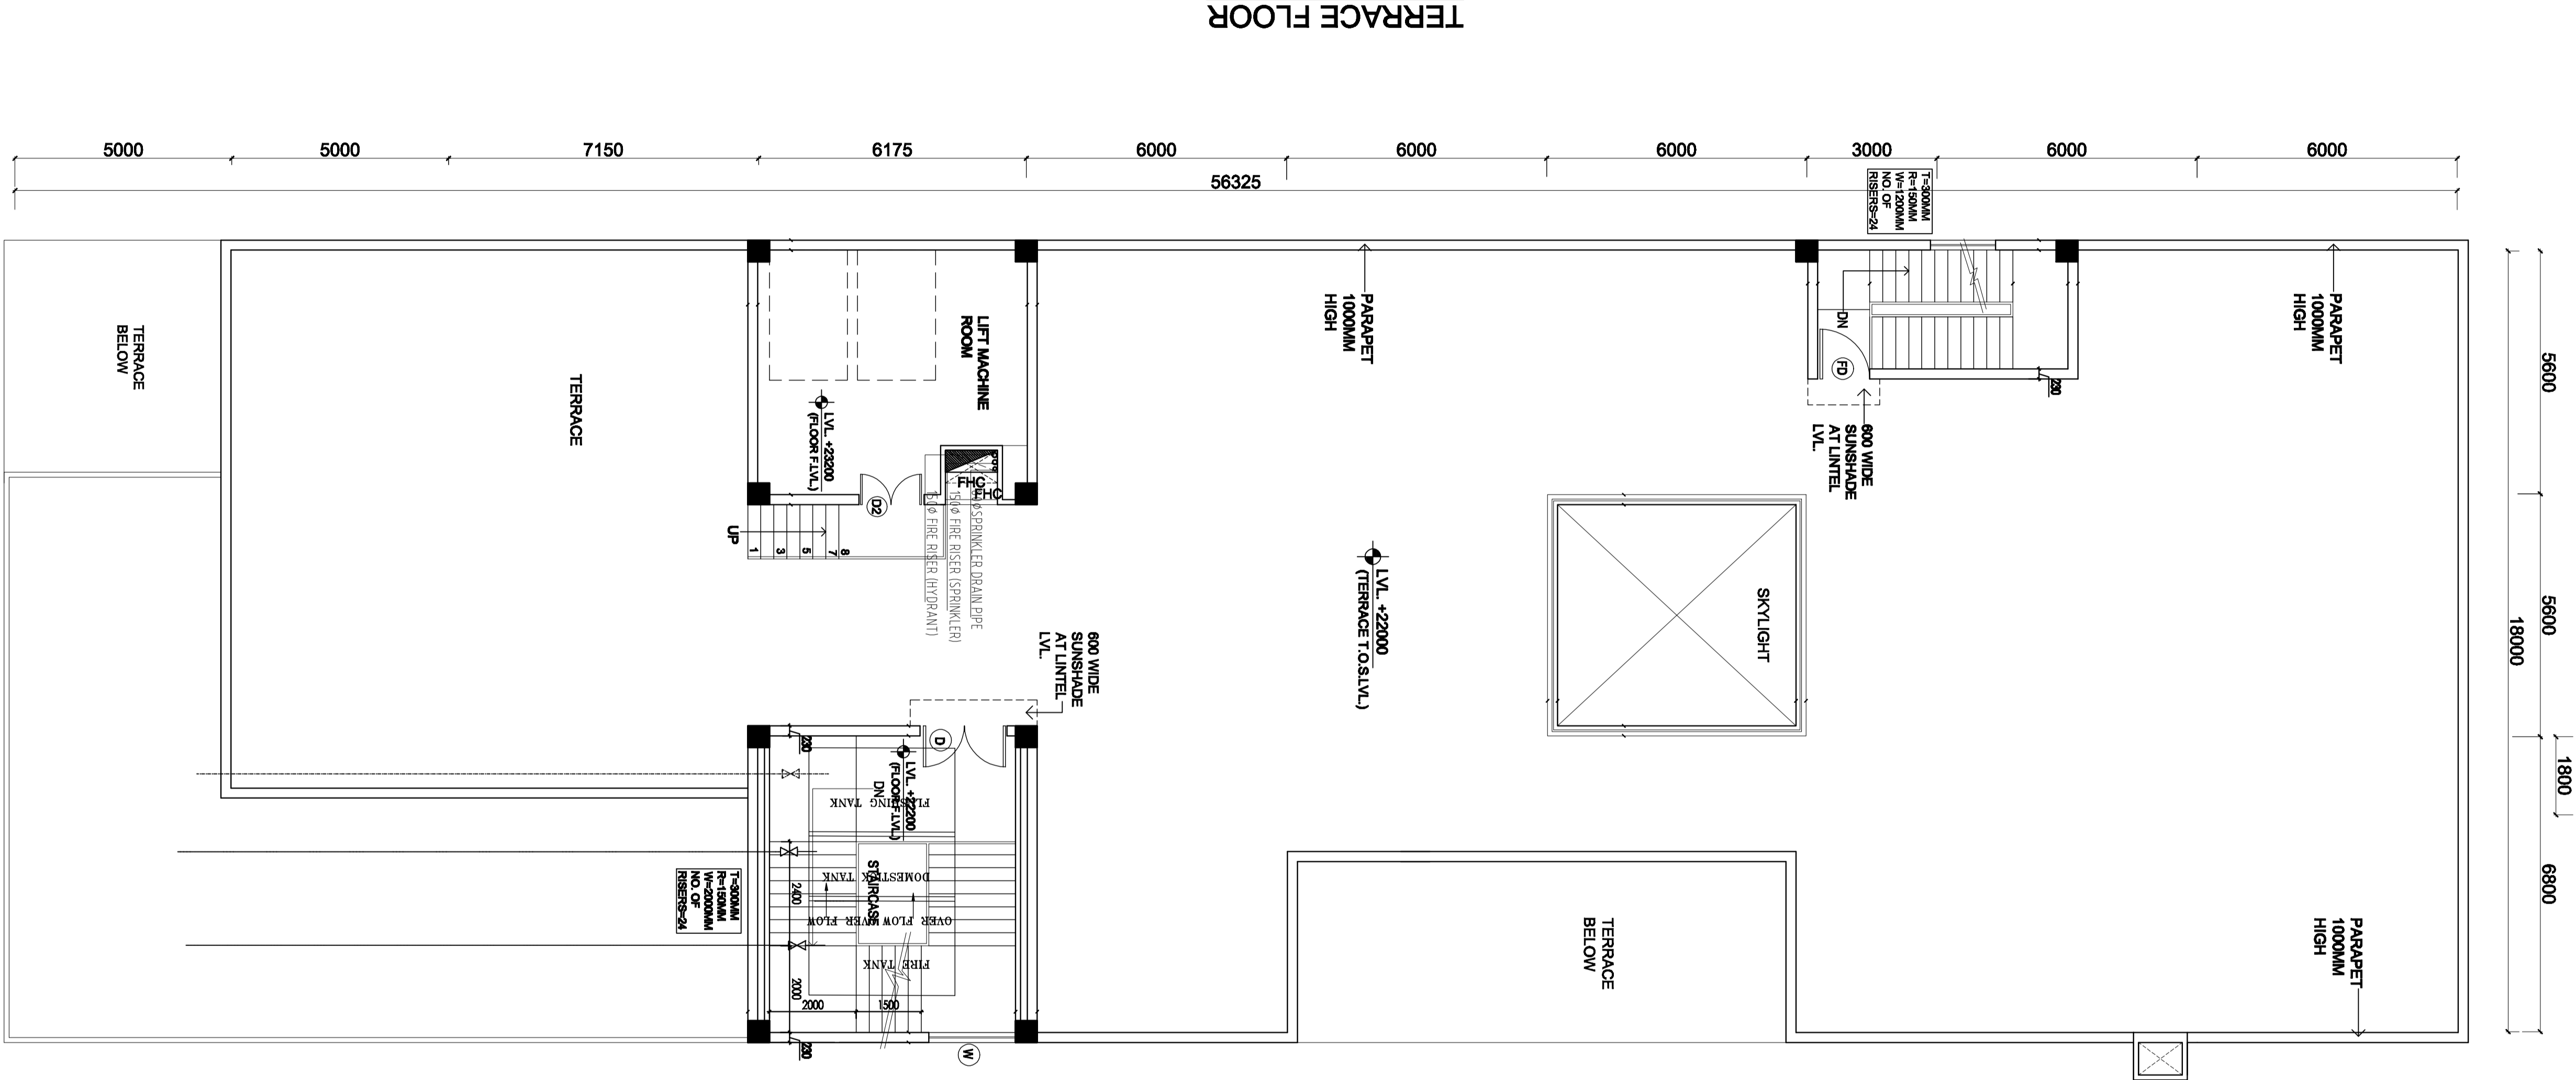

TERRACE FLOOR

TERRACE FLOOR

HSCC (INDIA) LIMITED
 (GOVERNMENT OF INDIA ENTERPRISES)
HSCC
 NEW DELHI
 INDIA

App by	Rev. by	Prep. by
Job No.	Scale	Date
Drawing No.		

TERRACE FLOOR PLAN

TENDER DRAWING

PROJECT
**PROPOSED
 100 BEDED
 HOSPITAL
 JAUNPUR
 (UP)**

NORTH

This drawing with all its contents is the sole intellectual property of the Hospital Services Consultancy Corporation (India) Ltd. Copying of this drawing or part thereof for use in any form whatsoever without the written permission of HSCC is prohibited.