


App by	Rev. by	Prep. by
Job No.	Scale	Date
Drawing No.		
HSCC/D&E/JPHS/PL-01		

GROUND FLOOR PLAN

TENDER DRAWING

PROPOSED  
100 BEDED  
HOSPITAL  
JAUNPUR  
(UP)

PROJECT

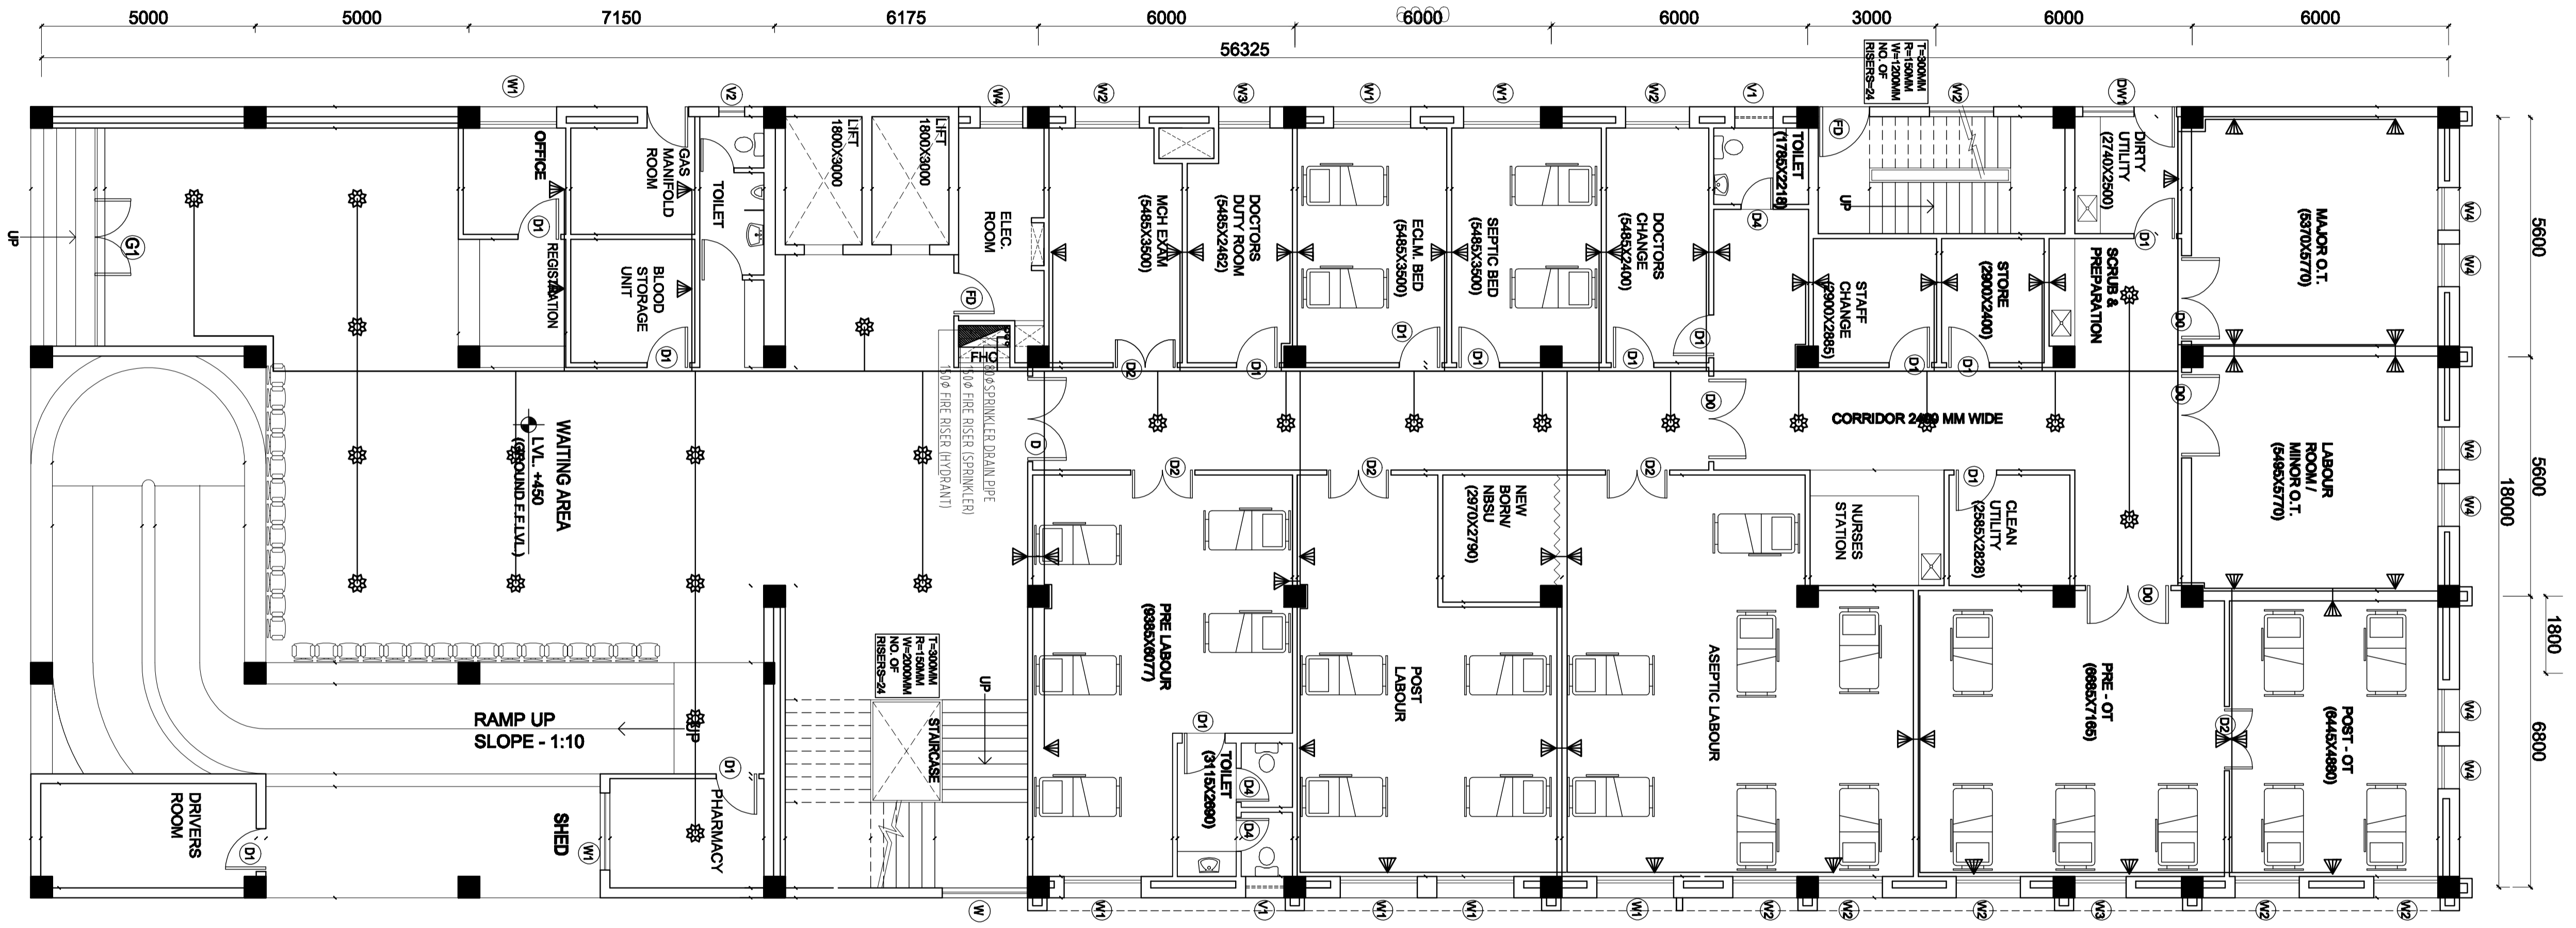

GROUND FLOOR

NORTH

This drawing with all its contents is the sole intellectual property of the Hospital Services Consultancy Corporation (India) Ltd. Copying of this drawing or part thereof for use in any form whatsoever without the written permission of HSCC is prohibited.