

ALL INDIA INSTITUTE OF MEDICAL SCIENCES (AIIMS), ANSARI NAGAR, NEW DELHI

Tender

For

Renovation of CCU at CN Centre at AIIMS, Ansari Nagar, New Delhi

Volume-VI

TENDER DRAWINGS

AUGUST' 2012



HSCC (INDIA) LTD.
(CONSULTANTS & ENGINEERS FOR MEGA HOSPITALS & LABORATORIES)
E-6(A), sector-1, NOIDA(U.P) 201301 (India)

Phone : 0120-2542436-40

Fax : 0120-2542447


Tender No. HSCC/ AIIMS/ CCU/2012

TENDER DRAWING


ARCHITECTURAL

This drawing with all its intellectual property of the Hospital Services Consulting Corporation (HSCC) shall remain the property of HSCC. This drawing or part thereof or its use in any form without the prior written permission of HSCC is prohibited.


NOTES

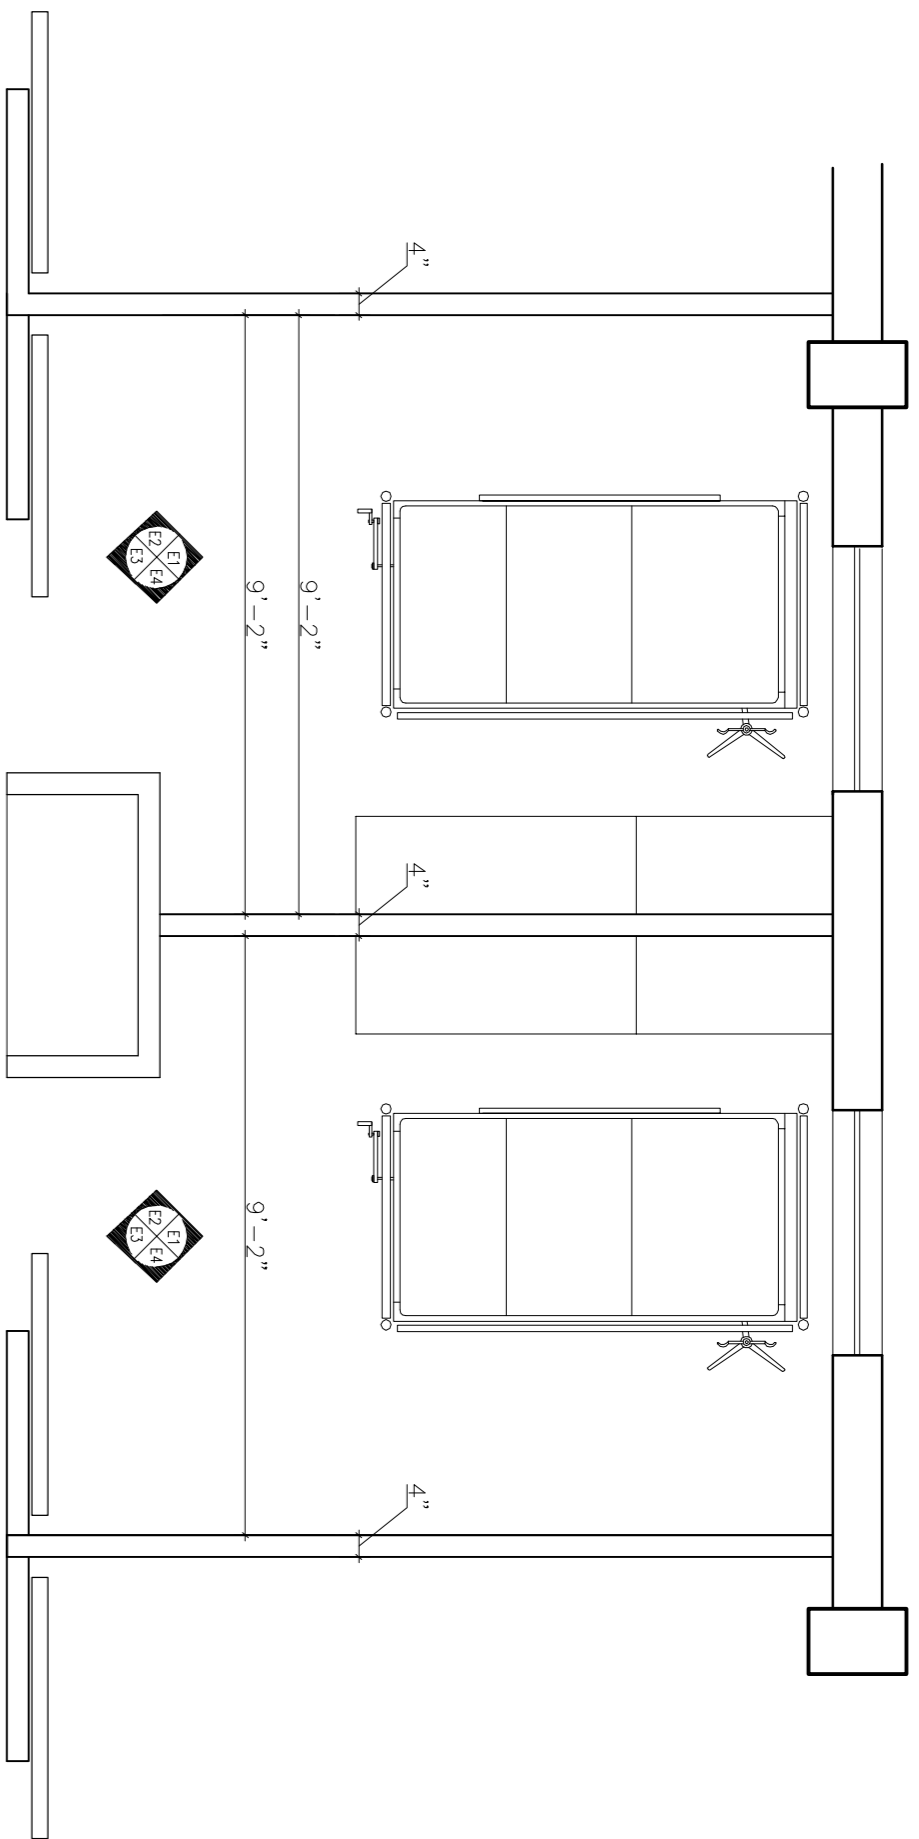


Typical CCU Cabin

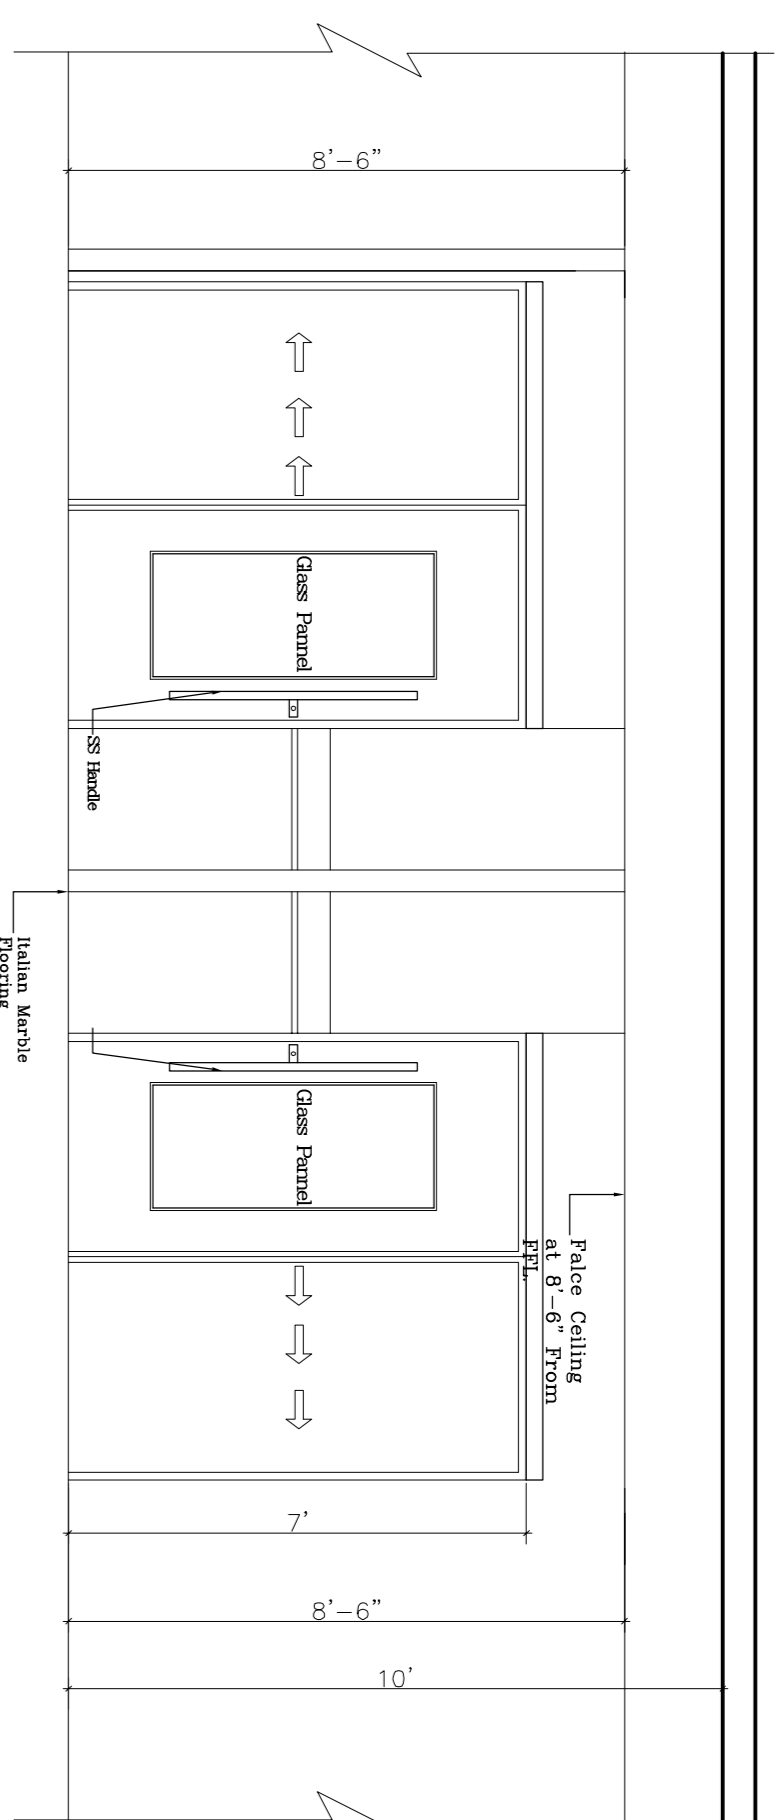


ELEVATION E3

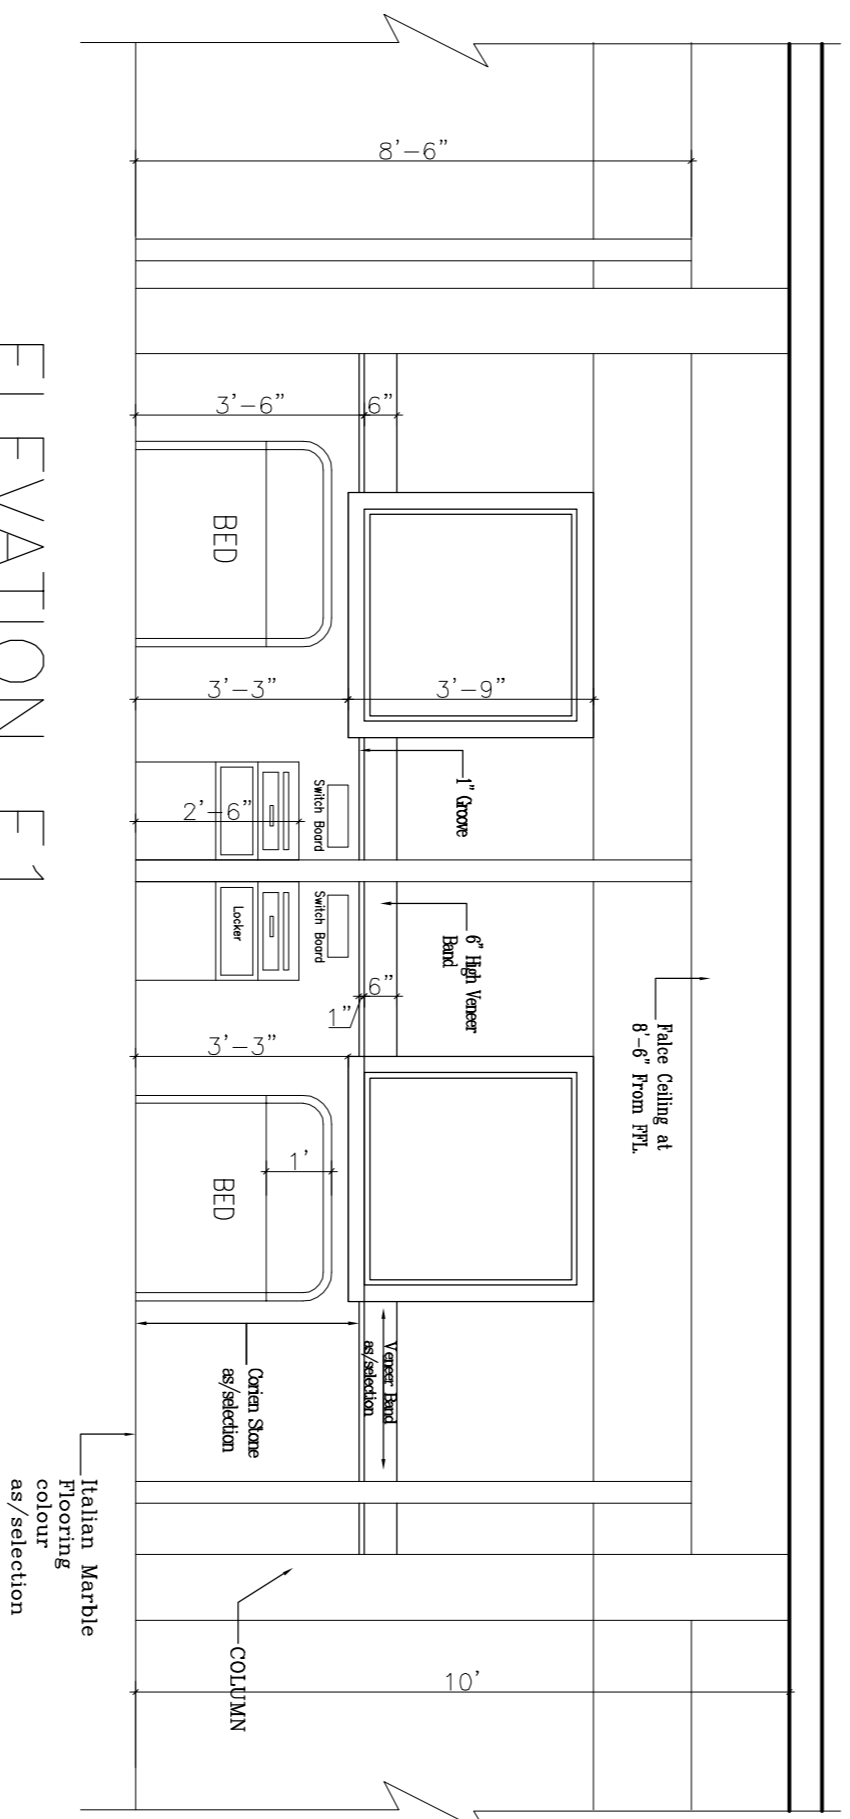

ELEVATION E1

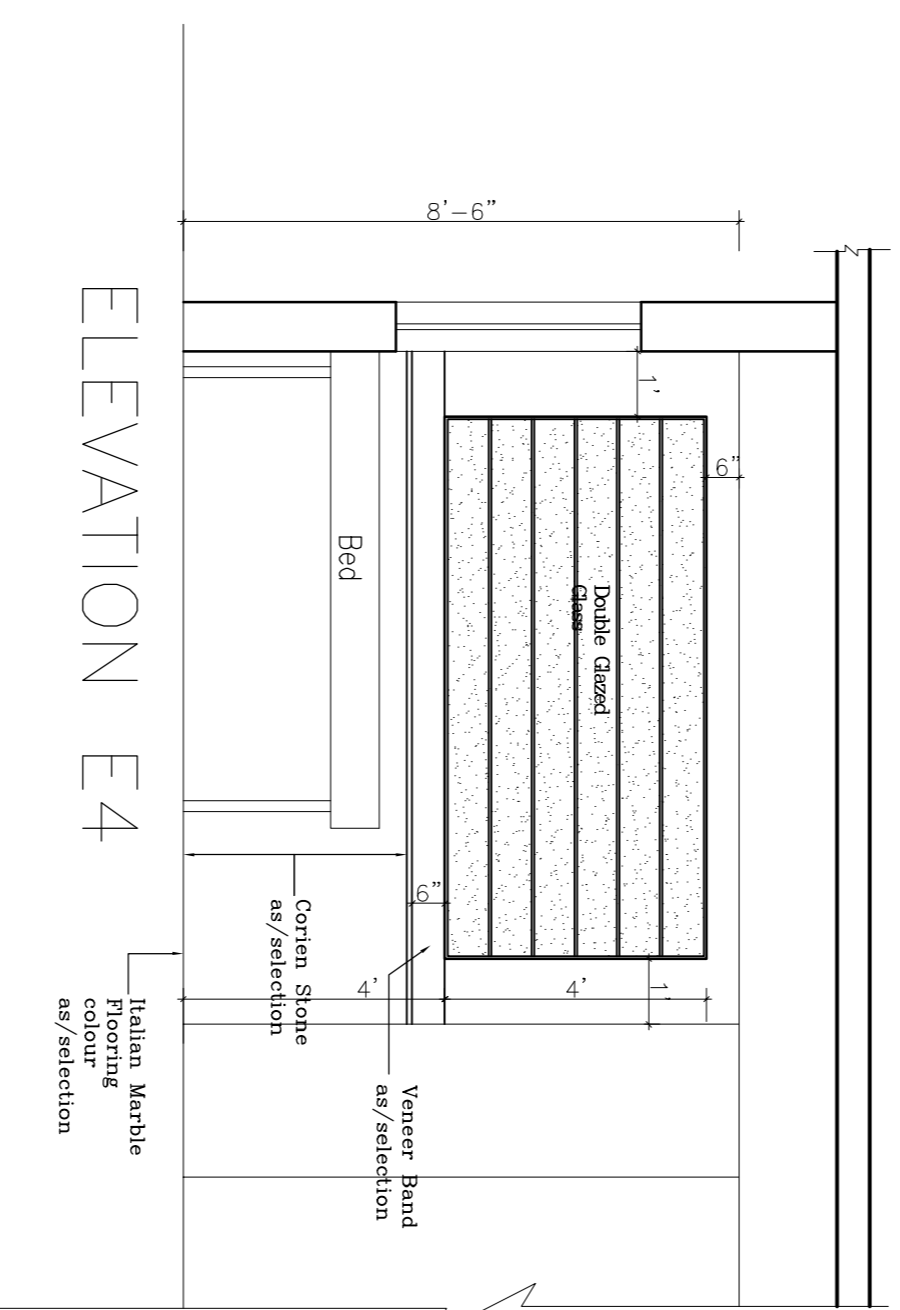

ELEVATION E4

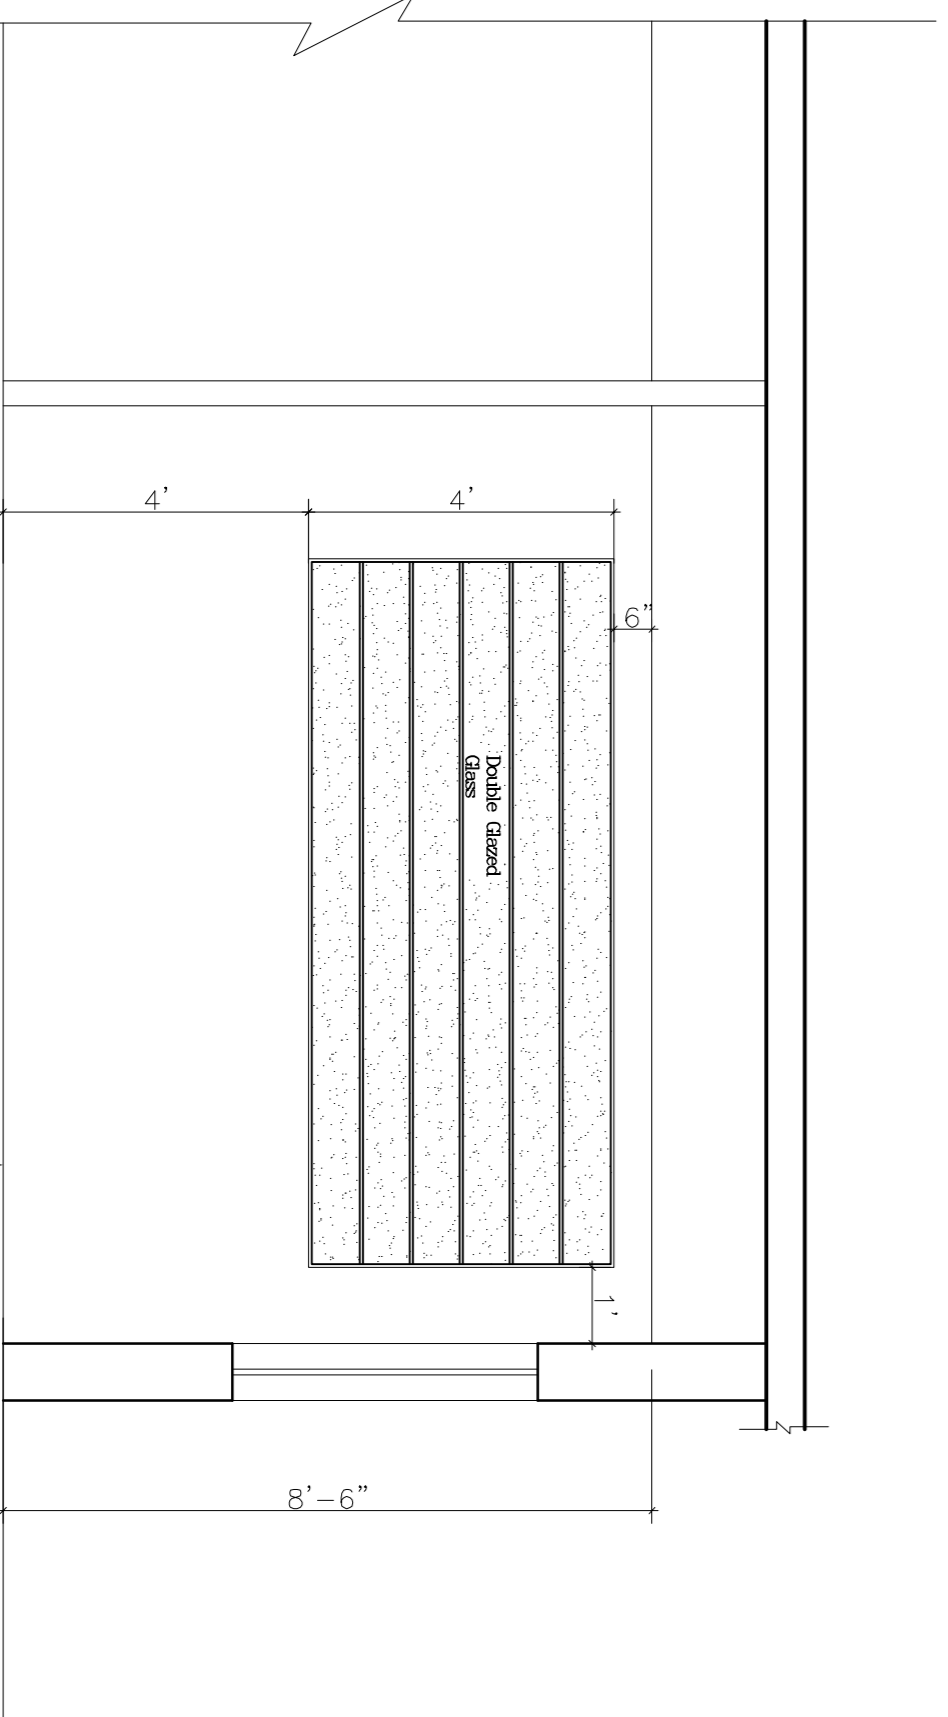

ELEVATION E2

PROJECT
All India Institute of Medical Science
New-Delhi

TITLE
CCU

CCU Room Detail

HSCC/AIIMS		DRAWING NO.	
JOB NO.	SCALE	DATE	10-03-2011
Job. No.	Scale	Date:	
App by	Rev. by	Prep. by	



PLAN

NOTES

All India Institute of
Medical Science
New-Delhi

CCU


CCU Room Detail

HSCC/AIIMS

Drawing No.	
Job No.	Scale
Date:	
App. By:	Rev. By
	Prep. By

TENDER DRAWING

ELECTRICAL

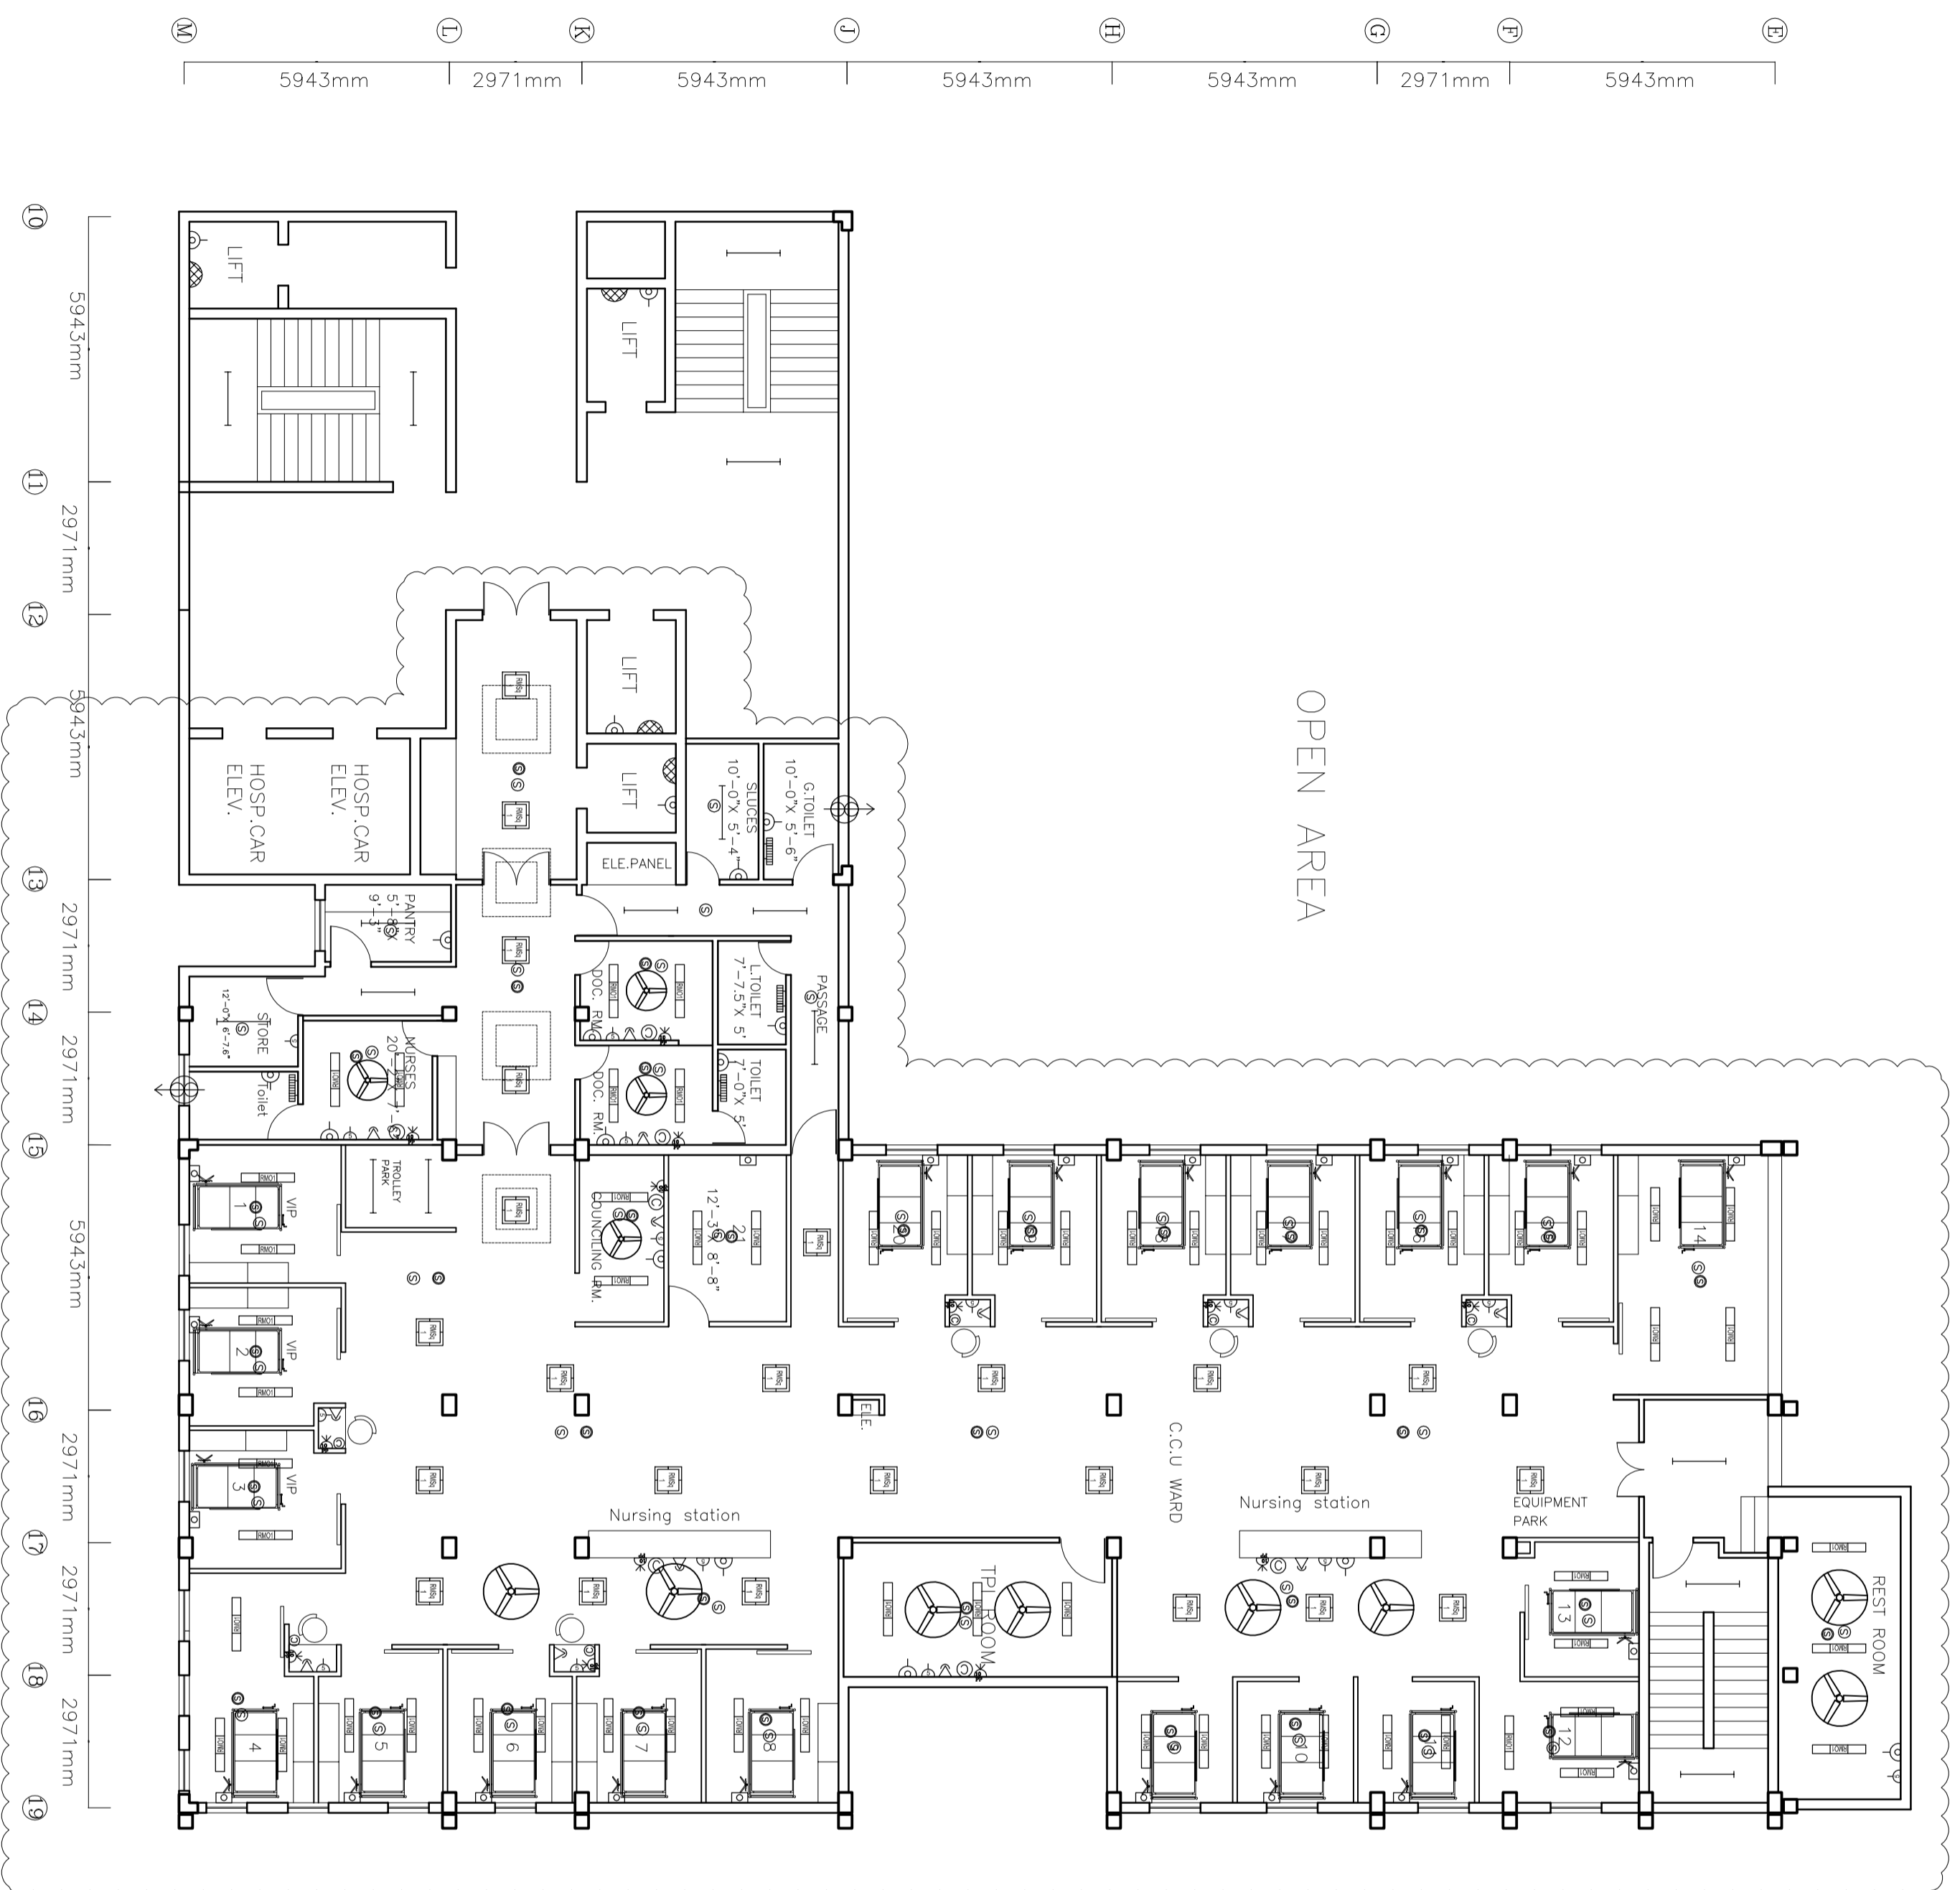

NOTES

PROJECT

**All India Institute of
Medical Science
New - Delhi**

TITLE


CCU

Electrical Layout

HSCC/D&E /AIMS/CCU/EL-01			
Drawing No.			
Job No.	NTS	Scale	Date:
App. By:	Rev. By:	Prep. By:	

TENDER DRAWING

HVAC

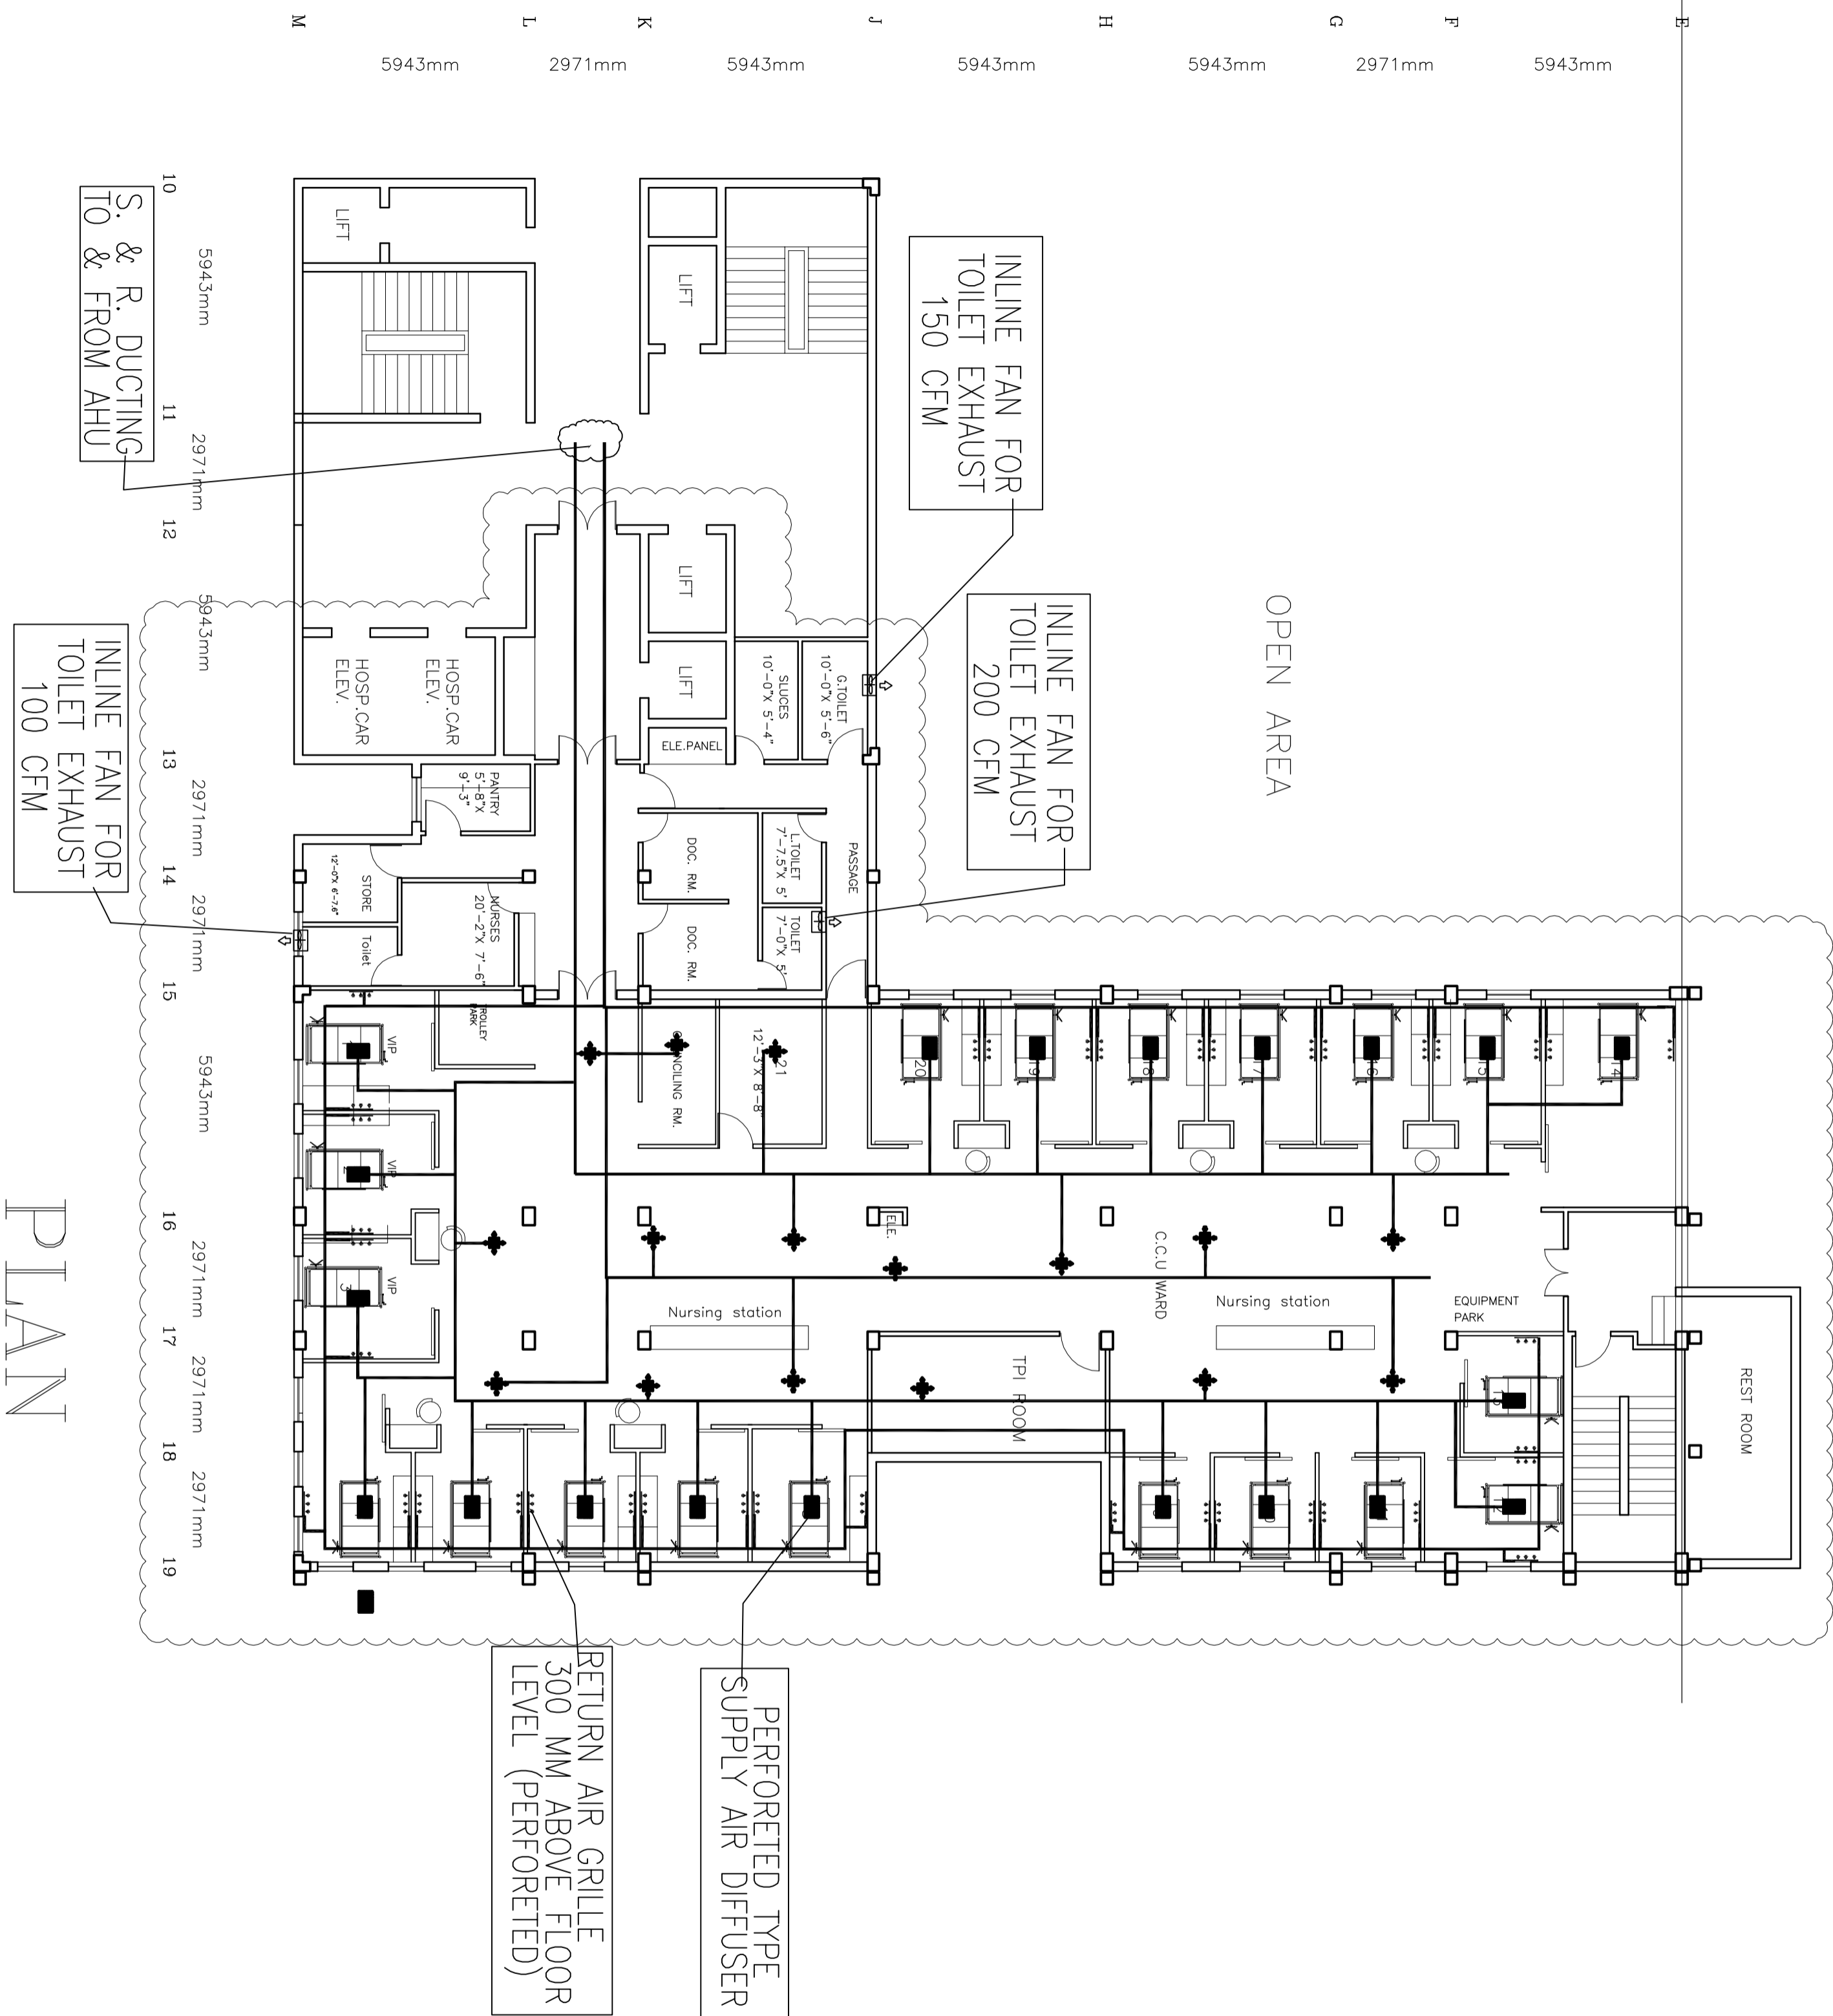

PLAN

NOTES	
-------	--

<p>All India Institute of Medical Science New-Delhi</p>			
<p>TENDER DRAWING</p>			
<p>CCU-RENOVATION HVAC LAYOUT Scheme purpose only</p>			
<p>HSCC/D&E/CCU-AIIMS/HVAC</p>			
Drawing No.		Date:	
Job No.	Scale	Date:	
App. By:	Rev. By:	Prep. By:	



**END OF
VOLUME - VI**