

This drawing with all its contents is the sole intellectual property of the Hospital Services Consulting Corporation (HSCC) and shall not be used for any drawing or part thereof for its use in any form whatsoever without the written permission of HSCC is prohibited.

NORTH

LEGEND:

1	100 Ø CI SOIL & VENT PIPE
2	100Ø CLWASTE & VENT PIPE
3	100Ø CI SOIL PIPE
4	100Ø CI WASTE PIPE
5	50Ø uPVC SOIL PIPE
6	40Ø uPVC WASTE PIPE
7	32Ø uPVC WASTE PIPE
8	TW DN / TAKE
9	UTW DN / TAKE
F.1	150 Ø S.W. PIPE
F.D	FLOOR TRAP 100X100
FD	FLOOR DRAIN 50Ø
FCO	FLOOR CLEAN OUT
X	VALVE
MH	MANHOLE (900X800)mm
GT	GULLY TRAP(300X300)mm

PROJECT

**PROPOSED
100 BEDDED
HOSPITAL
PLIBHIT
(UP)**


**TITLE PLUMBING
TENDER DRAWING**

FIRST FLOOR PLAN

HSCC/DAE/PR/HS/TP/PL-02
Drawing No.

Job No.	Scale	Date
App by	Rev. by	Prep. by

HSCC (INDIA) LIMITED
(A GOVERNMENT OF INDIA ENTERPRISE)
HSCC
NEW DELHI INDIA

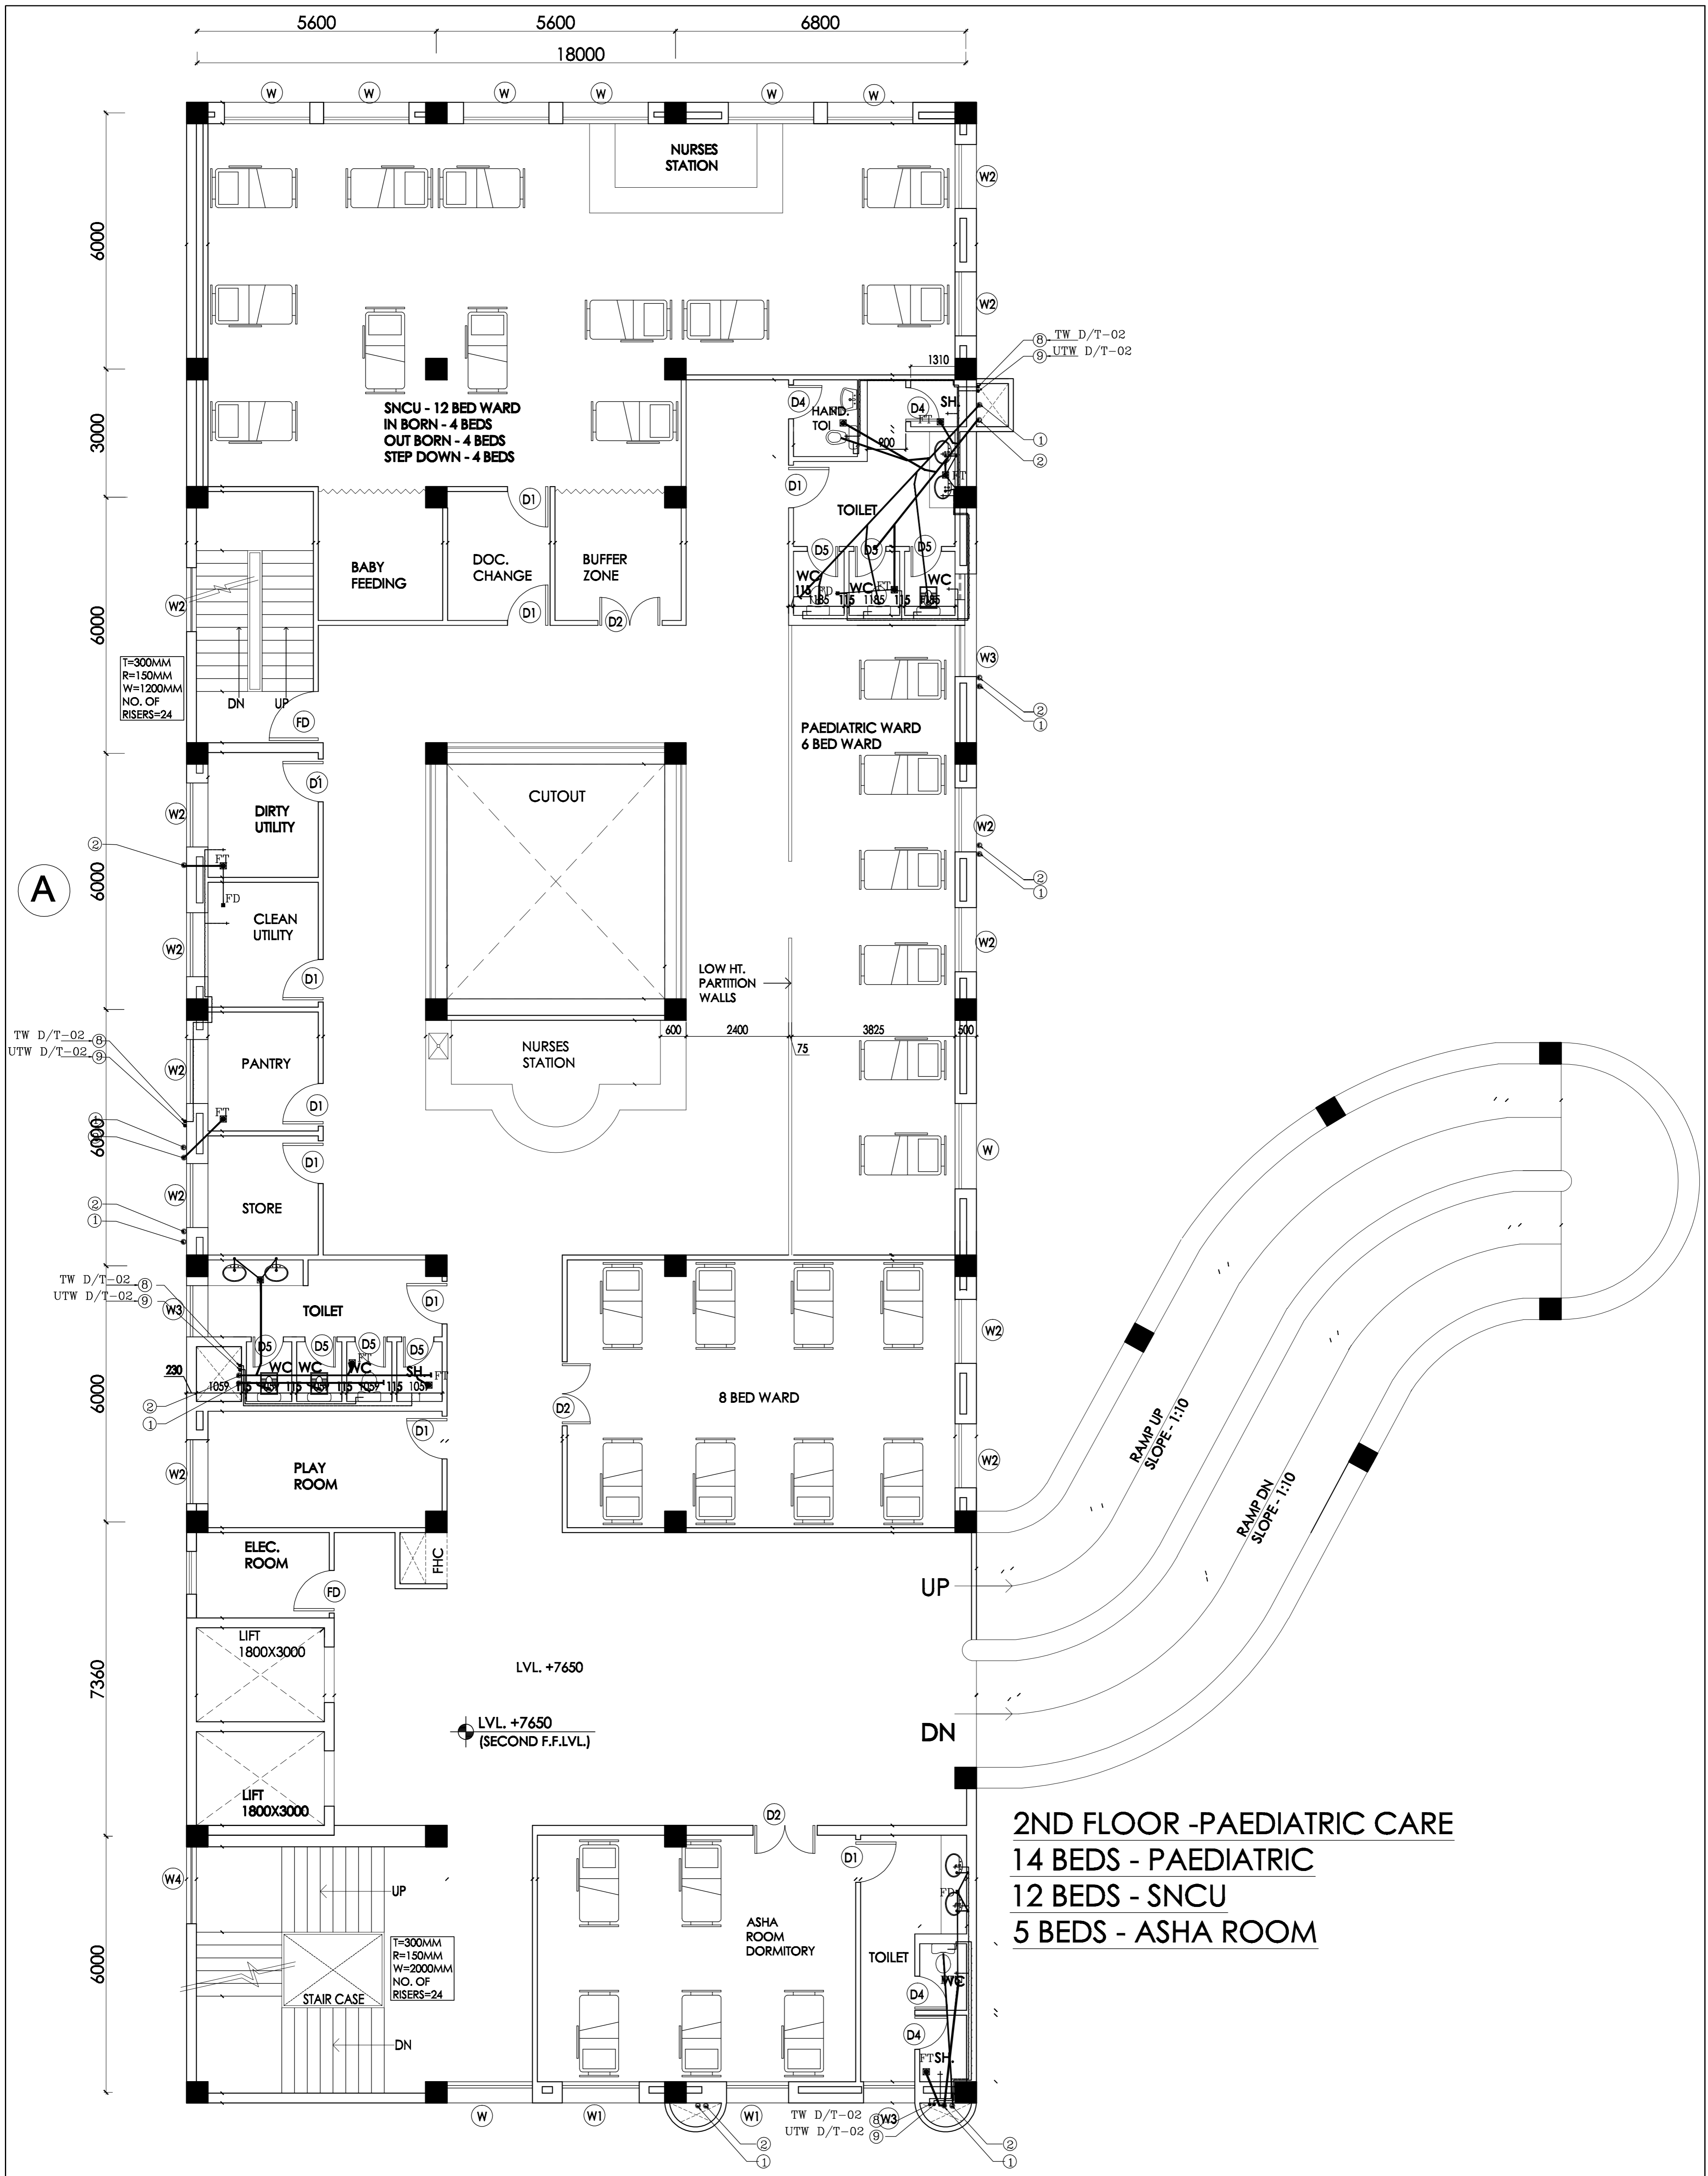

2ND FLOOR - PAEDIATRIC CARE
14 BEDS - PAEDIATRIC
12 BEDS - SNCU
5 BEDS - ASHA ROOM

NORTH

This drawing with all its contents is the sole intellectual property of the Hospital Services (India) Pvt. Ltd. Any reproduction or use of this drawing or part thereof for its own or any other purpose without the written permission of HSCC is prohibited.

LEGEND:

1	100 Ø CI SOIL & VENT PIPE
2	100Ø CLWASTE & VENT PIPE
3	100Ø CI SOIL PIPE
4	100Ø CI WASTE PIPE
5	50Ø UPVC SOIL PIPE
6	40Ø UPVC WASTE PIPE
7	32Ø UPVC WASTE PIPE
8	TW DN / TAKE
9	UTW DN / TAKE
F.T	FLOOR TRAP 100X100
F.D	FLOOR DRAIN 50Ø
FCO	FLOOR CLEAN OUT
X	VALVE
MH	MANHOLE (900X800)mm
GT	GULLY TRAP(300X300)mm

PROJECT

**PROPOSED
 100 BEDED
 HOSPITAL
 PLIBHIT
 (UP)**

**TITLE PLUMBING
 TENDER DRAWING**

SECOND FLOOR PLAN

HSCC/PAE/PR/HS/TP/PL-03	
Drawing No.	
Job No.	Scale
App by	Rev. by
	Prep. by
	Date

HSCC (INDIA) LIMITED
 (A GOVERNMENT OF INDIA ENTERPRISE)
HSCC
 NEW DELHI INDIA