


PHE & FIRE

DRAWINGS

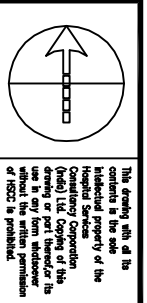

This drawing with all the contents in the same shall be the intellectual property of the HSCC (INDIA) LIMITED. Any use or reproduction of this drawing or part thereof for any purpose without the written permission of HSCC is prohibited.

- NOTES**
1. DRAWINGS TO BE READ NOT MEASURED
 2. PARTITION WALL IN TOILETS UP TO LINTEL HEIGHT

LEGEND:

| | |
|-----|--|
| 1 | 100 Ø CI SOIL & VENT PIPE |
| 2 | 100Ø CI WASTE & VENT PIPE |
| 3 | 100Ø CI SOIL PIPE |
| 4 | 100Ø CI WASTE PIPE |
| 5 | 50Ø GI/CPVC SOIL PIPE |
| 6 | 40Ø GI/CPVC WASTE PIPE for lab, Urinal |
| 7 | 32Ø GI/CPVC WASTE PIPE FOR W.B. |
| 8 | Ø CPVC UTW/DN TAKE |
| 9 | Ø CPVC TW/DN TAKE |
| 10 | 100 Ø S.W. PIPE |
| 11 | 100 Ø R.W. PIPE |
| 12 | 100 Ø HDPE/LAB WASTE PIPE |
| 13 | 50 Ø HDPE/LAB WASTE PIPE |
| FT | FLOOR TRAP-100x100 |
| FD | FLOOR DRAIN 50Ø |
| FO | FLOOR CLEAN OUT |
| COF | CLEAN OUT PLUG |
| ⊗ | VALVE |
| MH | MANHOLE (900x600)mm |
| GT | GULLY TRAP(300x300)mm |

| REVISION | DESCRIPTION |
|----------|-------------|
| | |
| | |


PROJECT
PROPOSED
100 BEDDED HOSPITAL

**RMNCH PROJECT,
CHATTISGARH**

**TITLE PLUMBING
TENDER DRAWING**

**GROUND
FLOOR PLAN**


| | |
|--------------------------|------------|
| HSCC/D&E/TD/RMNCHE/PL-01 | Rev. |
| Drawing No. | |
| Job No. | 1-300 |
| Scale | 06-04-2013 |
| App By | Date |
| RITAGI | R.SUR |
| App By | Rev. by |
| | SHAIT |
| | Prep. by |

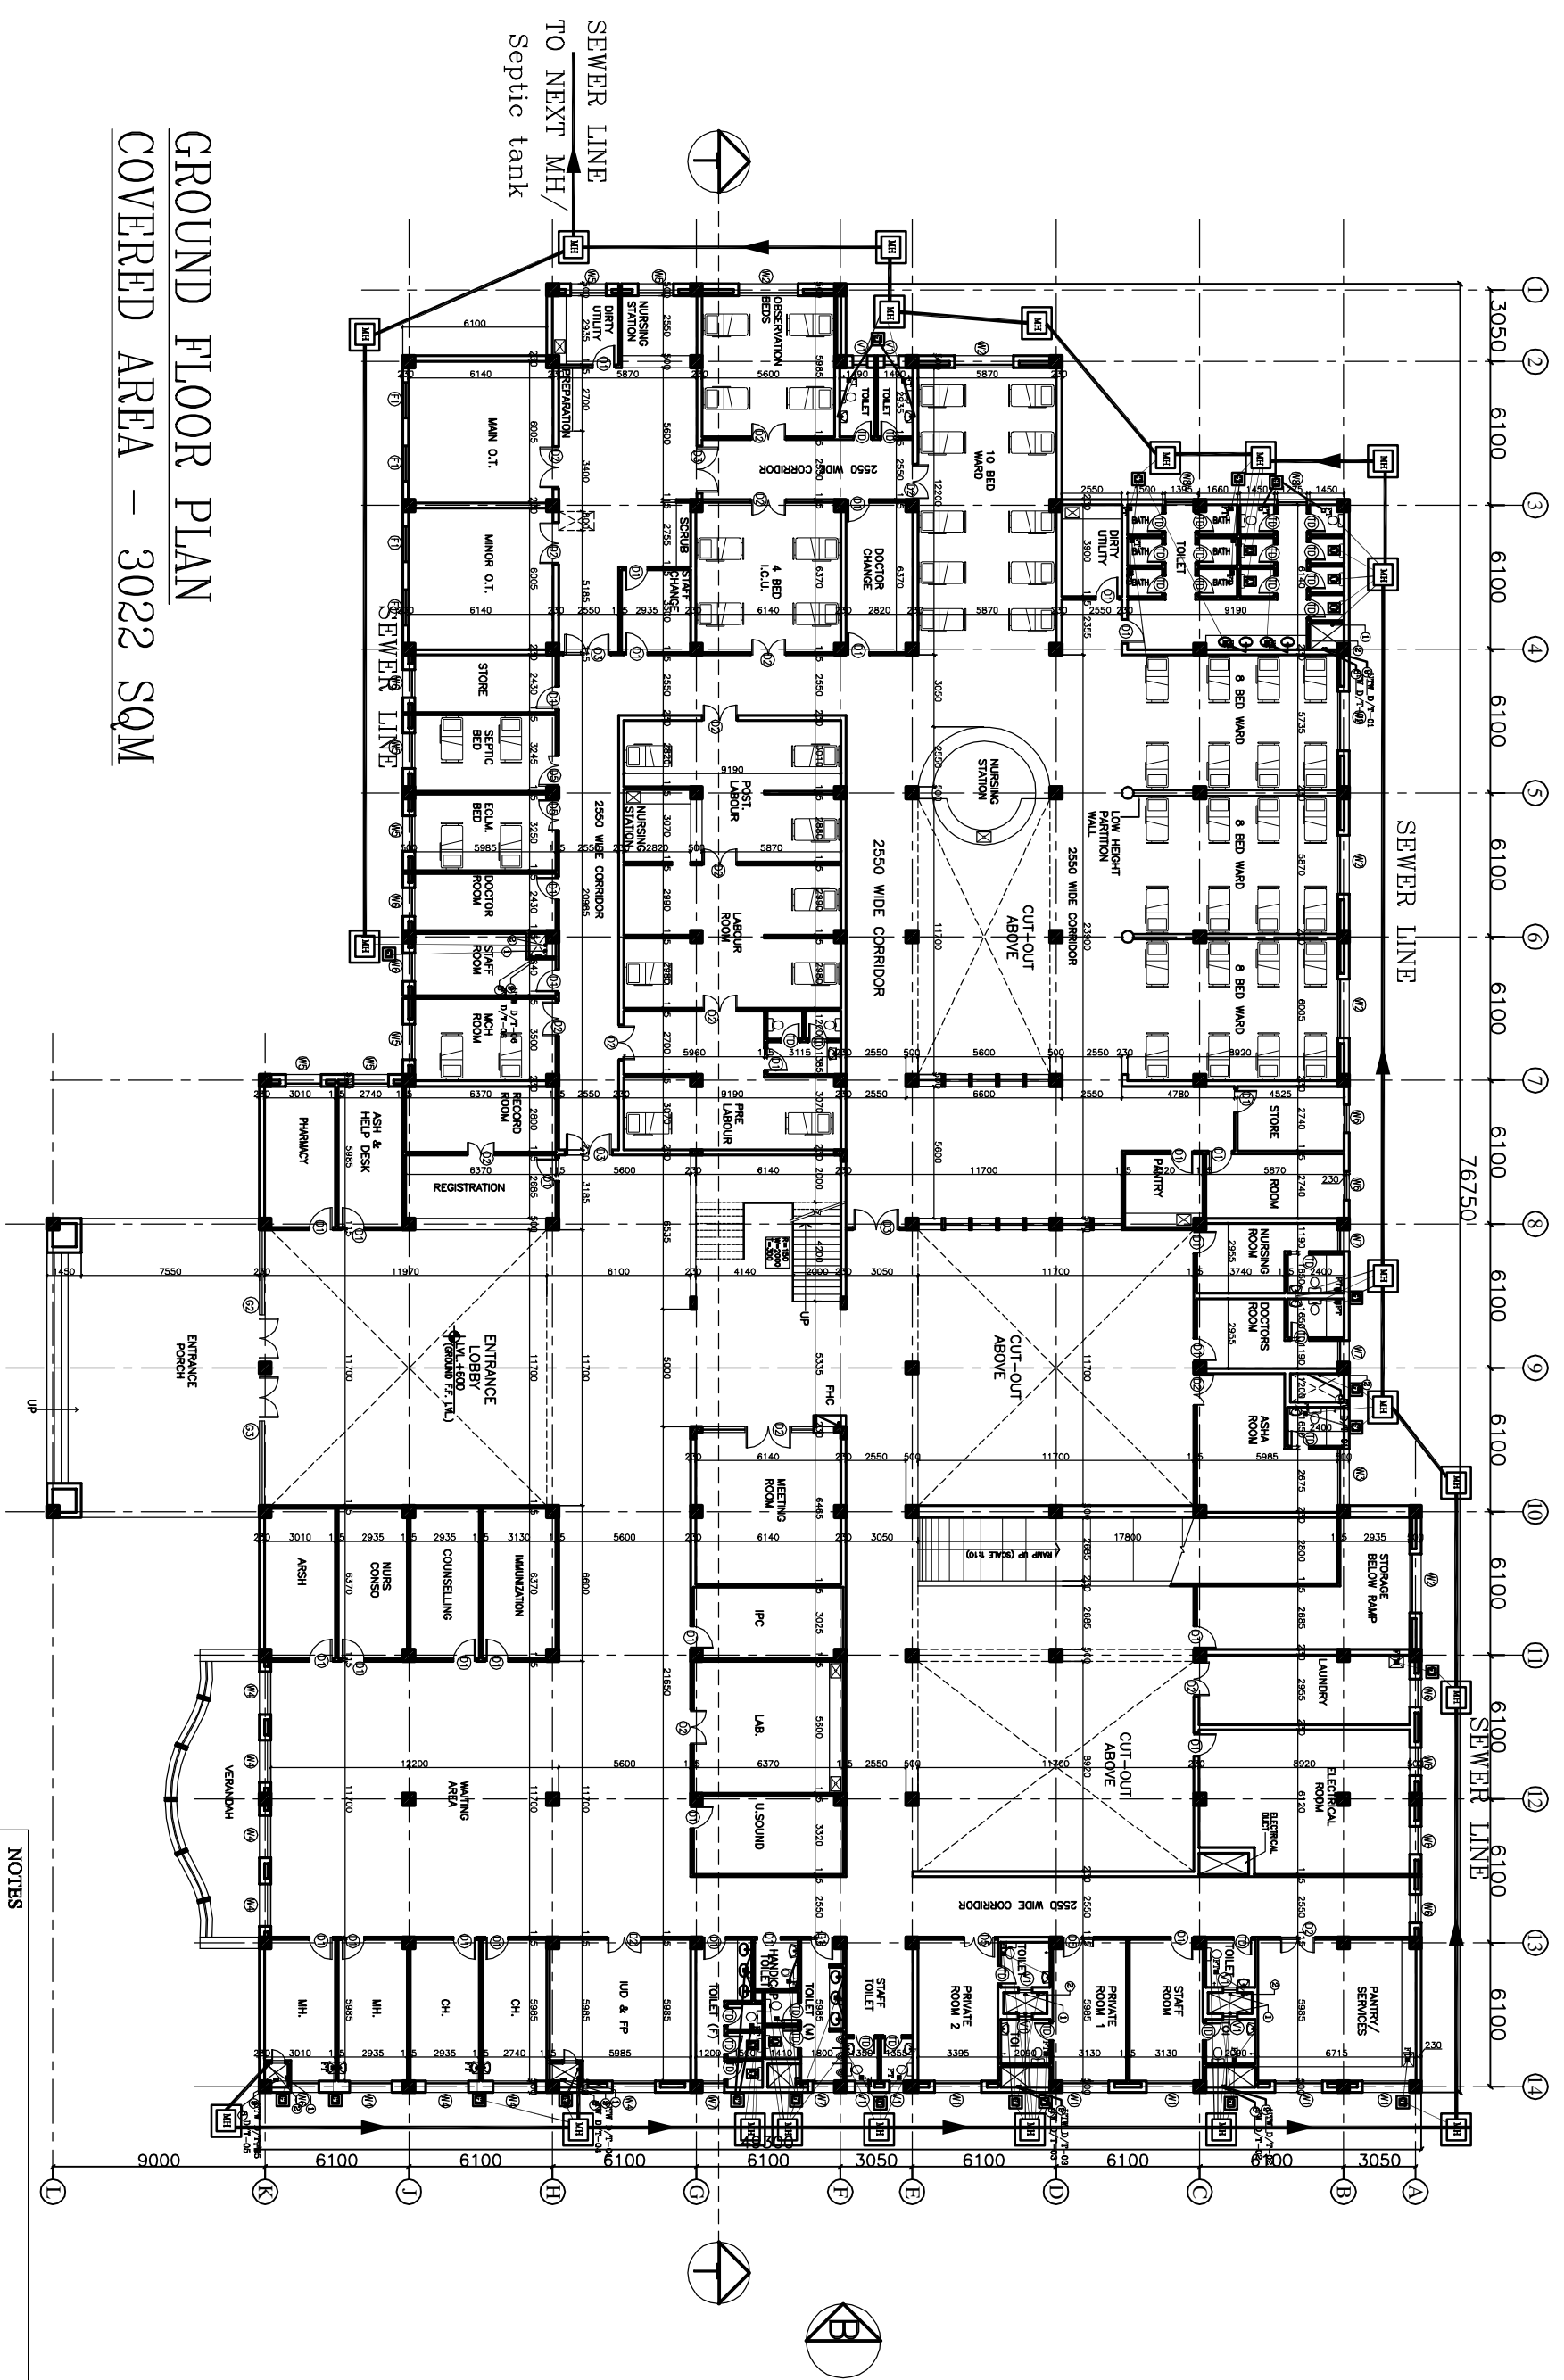

**GROUND FLOOR PLAN
COVERED AREA - 3022 SQM**

SEWER LINE
TO NEXT MH/
Septic tank

- NOTES**
1. BASED ON THIS DRAWING EXECUTING AGENCY WILL PREPARE SHOP DRAWING AFTER INCORPORATING THE CHANGES AS PER SITE CONDITION FOR THE APPROVAL OF HSCC BEFORE START OF WORK.
 2. THE NUMBER & LOCATION OF FIXTURES & WET POINT TO BE FINALIZED BEFORE EXECUTION WITH CLINT OFFICER'S INCHARGE..

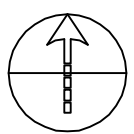

This drawing with all its contents is the sole intellectual property of the Consulting Engineer (India) Ltd. Copying of this drawing or part thereof in any form or by any means without the written permission of HSCC is prohibited.

- NOTES**
1. DRAWINGS TO BE READ NOT MEASURED
 2. PARTITION WALL IN TOILETS UP TO UNTEL HEIGHT

LEGEND:

| | |
|-----|-------------------------------------|
| 1 | 100 Ø CI SOIL & VENT PIPE |
| 2 | 100Ø CI WASTE & VENT PIPE |
| 3 | 100Ø CI SOIL PIPE |
| 4 | 100Ø CI WASTE PIPE |
| 5 | 50Ø GI/CPVC SOIL PIPE |
| 6 | 40Ø GI/CPVC WASTE PIPE for Sk.Utlia |
| 7 | 32Ø GI/CPVC WASTE PIPE FOR W.A. |
| 8 | Ø CPVC UTW/DN.7/4K |
| 9 | Ø CPVC T/W DN.7/4K |
| 10 | 100 Ø S.W. PIPE |
| 11 | 100 Ø R.W. PIPE |
| 12 | 100 Ø HDPE/LAB WASTE PIPE |
| 13 | 50 Ø HDPE/LAB WASTE PIPE |
| FD | FLOOR DRAIN 50Ø |
| FT | FLOOR TRAP 100x100 |
| FOO | FLOOR CLEAN OUT |
| COF | CLEAN OUT PLUG |
| ☒ | VALVE |
| MH | MANHOLE (900x900)mm |
| GT | GULLY TRAP(300x300)mm |


| REVISION | DESCRIPTION |
|----------|-------------|
| | |
| | |

PROJECT
 PROPOSED
 100 BEDDED HOSPITAL
 RMNCH PROJECT,
 CHATTISGARH

TITLE PLUMBING
 TENDER DRAWING
 FIRST
 FLOOR PLAN

| | |
|------------------------|------------|
| HSCC/D&E/TD/RMNC/PL-02 | Rev |
| Drawing No. | |
| Job No. | 1:300 |
| Scale | 05-04-2013 |
| Date | |
| App by | R.TAGI |
| Rev. by | R.SUR |
| Prep. by | S.BHATT |


HSCC (INDIA) LIMITED
 (A GOVERNMENT OF INDIA ENTERPRISE)
HSCC
 NEW DELHI INDIA

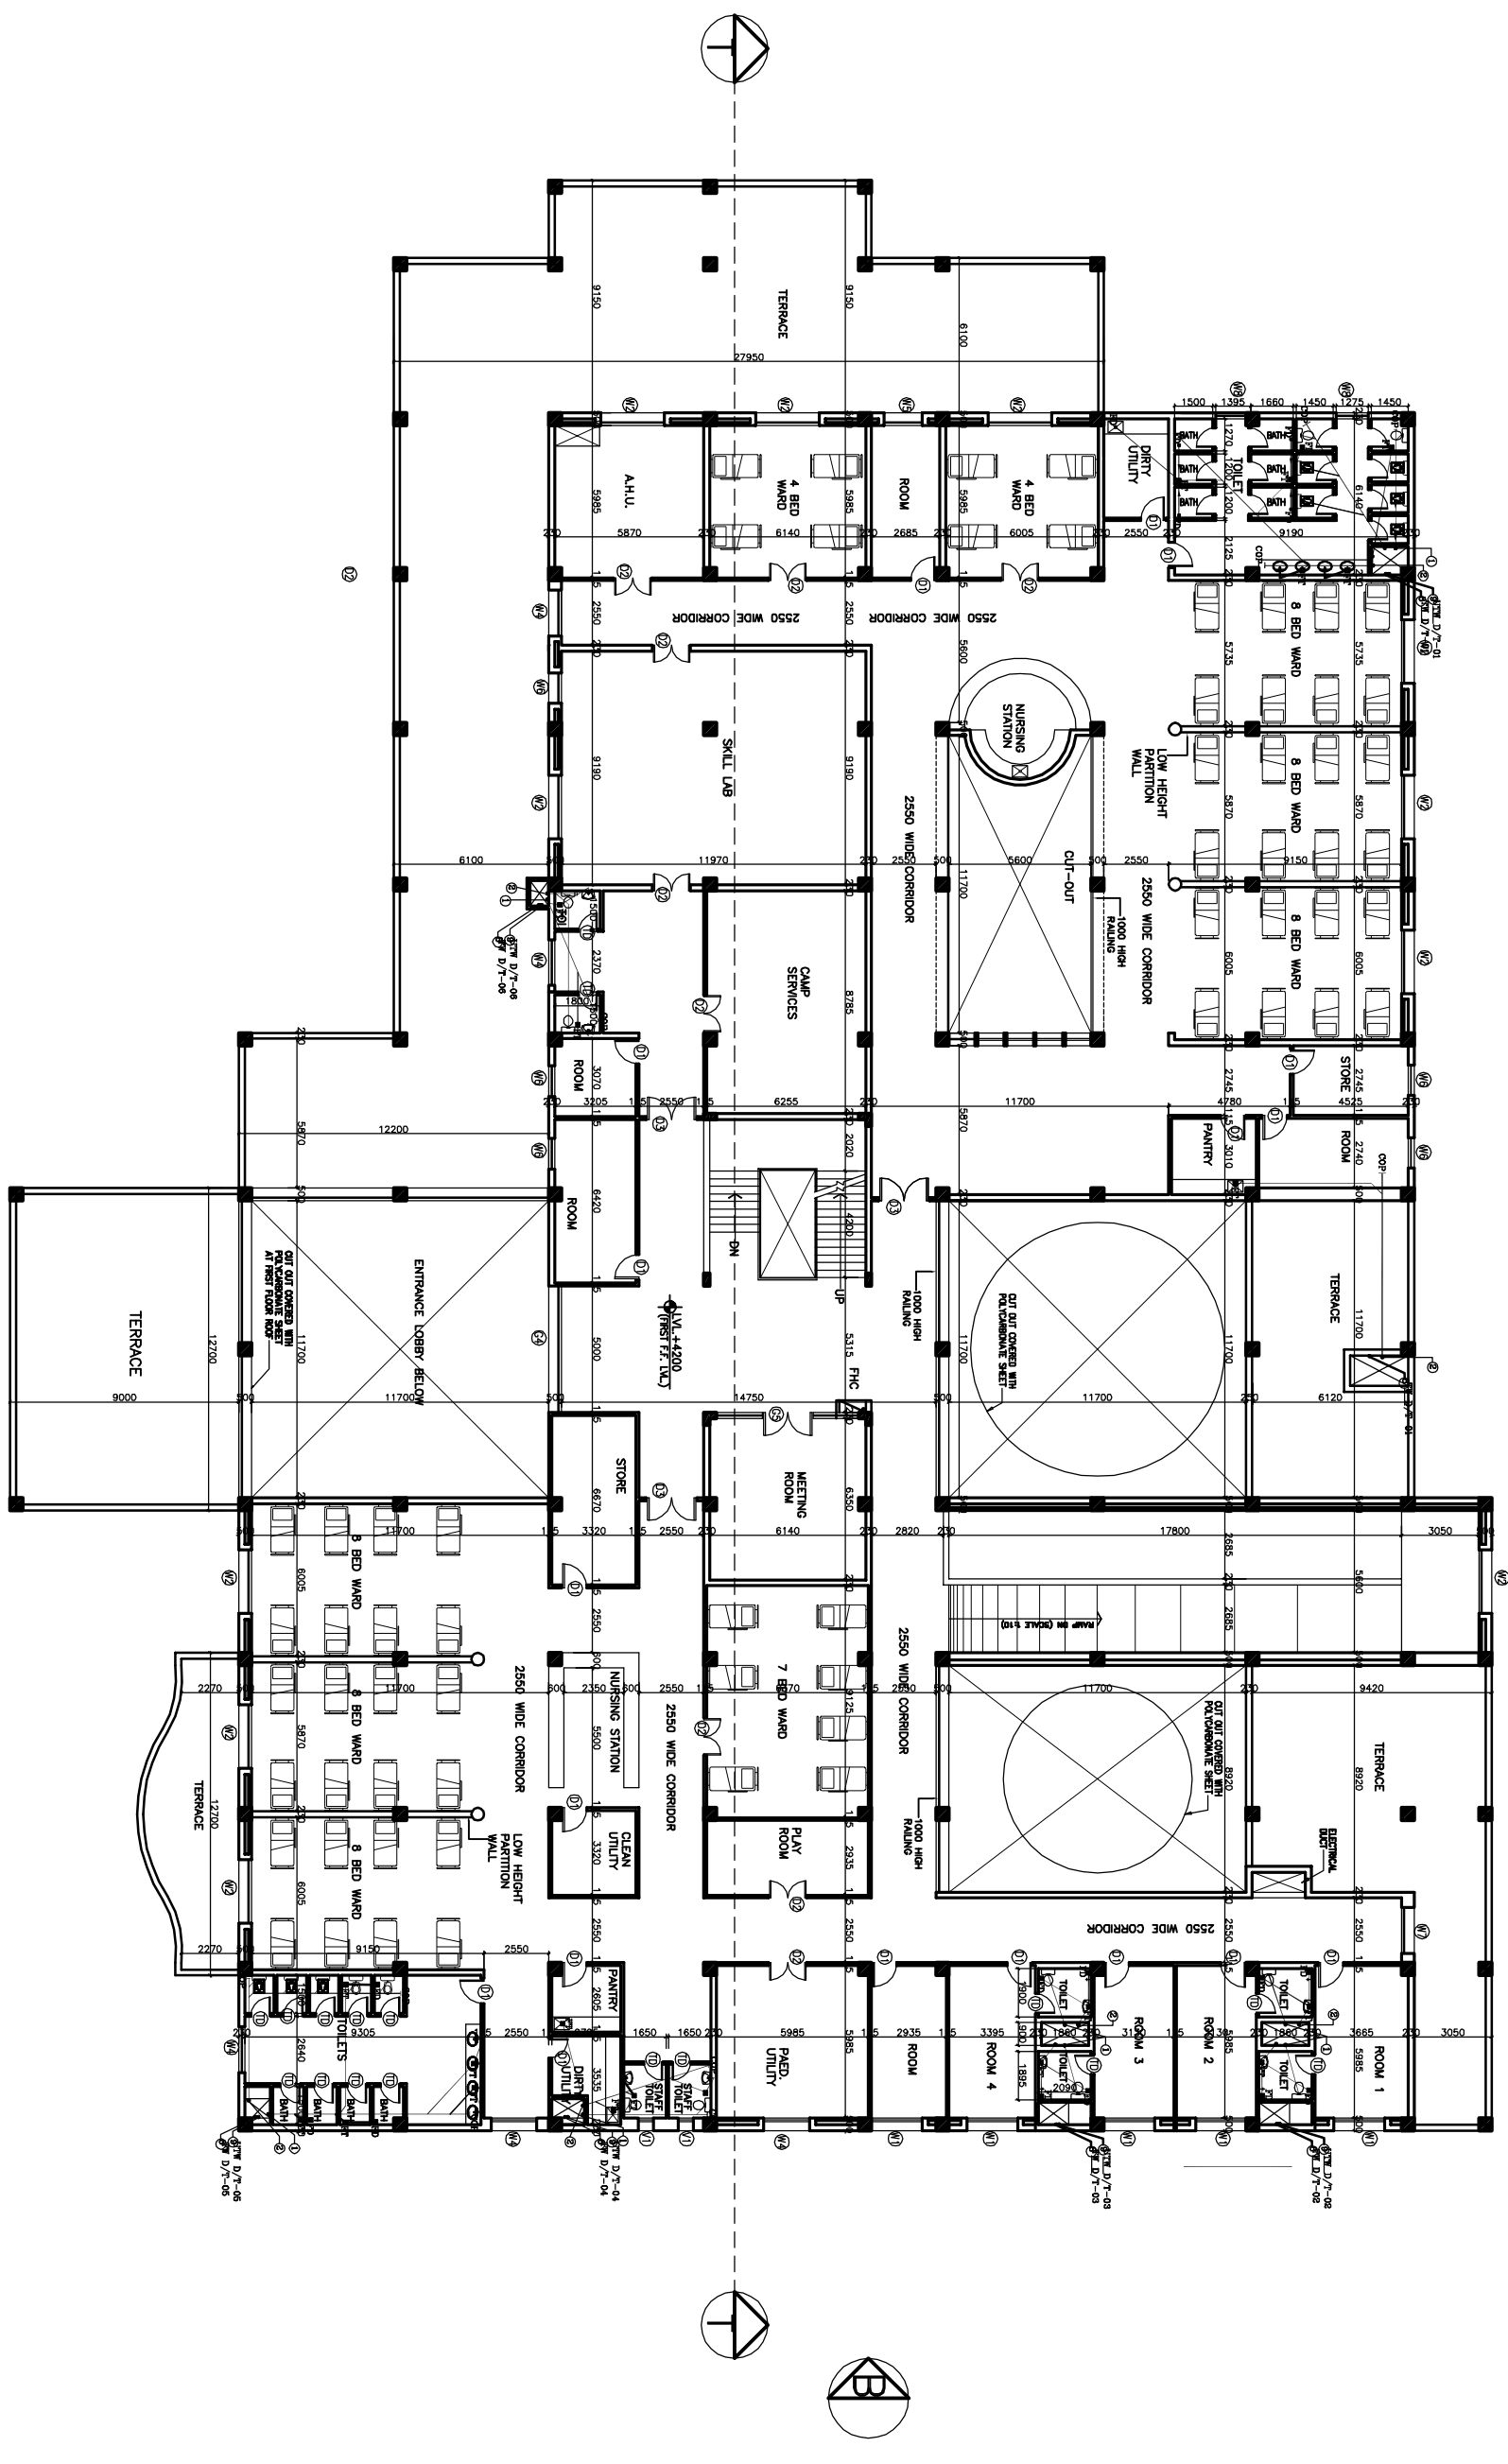

FIRST FLOOR PLAN
COVERED AREA – 2050 SQM



- NOTES**
1. BASED ON THIS DRAWING EXECUTING AGENCY WILL PREPARE SHOP DRAWING AFTER INCORPORATING THE CHANGES AS PER SITE CONDITION FOR THE APPROVAL OF HSCC BEFORE START OF WORK.
 2. THE NUMBER & LOCATION OF FIXTURES & WET POINT TO BE FINALIZED BEFORE EXECUTION WITH CLINT OFFICER'S INCHARGE..

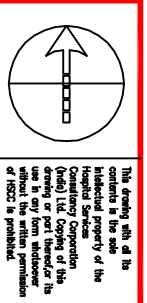

This drawing, with all the contents in the same, is the Intellectual Property of the Consulting Corporation (India) Ltd. Copying of this drawing or part thereof for any purpose without the written permission of HSCC is prohibited.

- NOTES**
1. DRAWINGS TO BE READ NOT MEASURED
 2. PARTITION WALL IN TOILETS UP TO LINTEL HEIGHT

LEGEND:

| | |
|---------|--|
| 1 | 100 Ø CI SOIL & VENT PIPE |
| 2 | 100Ø CI WASTE & VENT PIPE |
| 3 | 100Ø CI SOIL PIPE |
| 4 | 100Ø CI WASTE PIPE |
| 5 | 50Ø ØI CPVC SOIL PIPE |
| 6 | 40Ø ØI CPVC WASTE PIPE FOR URINAL LAB/SINK |
| 7 | 32Ø ØI CPVC WASTE PIPE FOR W.B. |
| 8 | Ø CPVC UTW/DN TAKE |
| 9 | Ø CPVC TW/DN TAKE |
| 10 | 100 Ø S.W. PIPE |
| 11 | 100 Ø R.W. PIPE |
| 12 | 100 Ø HDPE LAB WASTE PIPE |
| 13 | 50 Ø HDPE LAB WASTE PIPE |
| FT | FLOOR TRAP-100x100 |
| FD | FLOOR DRAIN 50Ø |
| FO | FLOOR CLEAN OUT |
| COF | CLEAN OUT FLUG |
| ✗ VALVE | VALVE |
| MH | MANHOLE (900x900)mm |
| GT | GULLY TRAP(300x300)mm |

| REVISION | DESCRIPTION |
|----------|-------------|
| | |
| | |
| | |

PROJECT
PROPOSED
100 BEDDED HOSPITAL


**RMNCH PROJECT,
CHATTISGARH**

**TITLE PLUMBING
TENDER DRAWING**

**TERRACE
FLOOR PLAN**

HSCC/D&E/TD/RMNCH/PL-03 Rev.

| | | | |
|-------------|---------|----------|------------|
| Drawing No. | 1:300 | Date | 06-04-2013 |
| Job No. | Scale | | |
| App. by | Rev. by | Prep. by | |
| R.TYAGI | R.SUR | S.BHAI | |

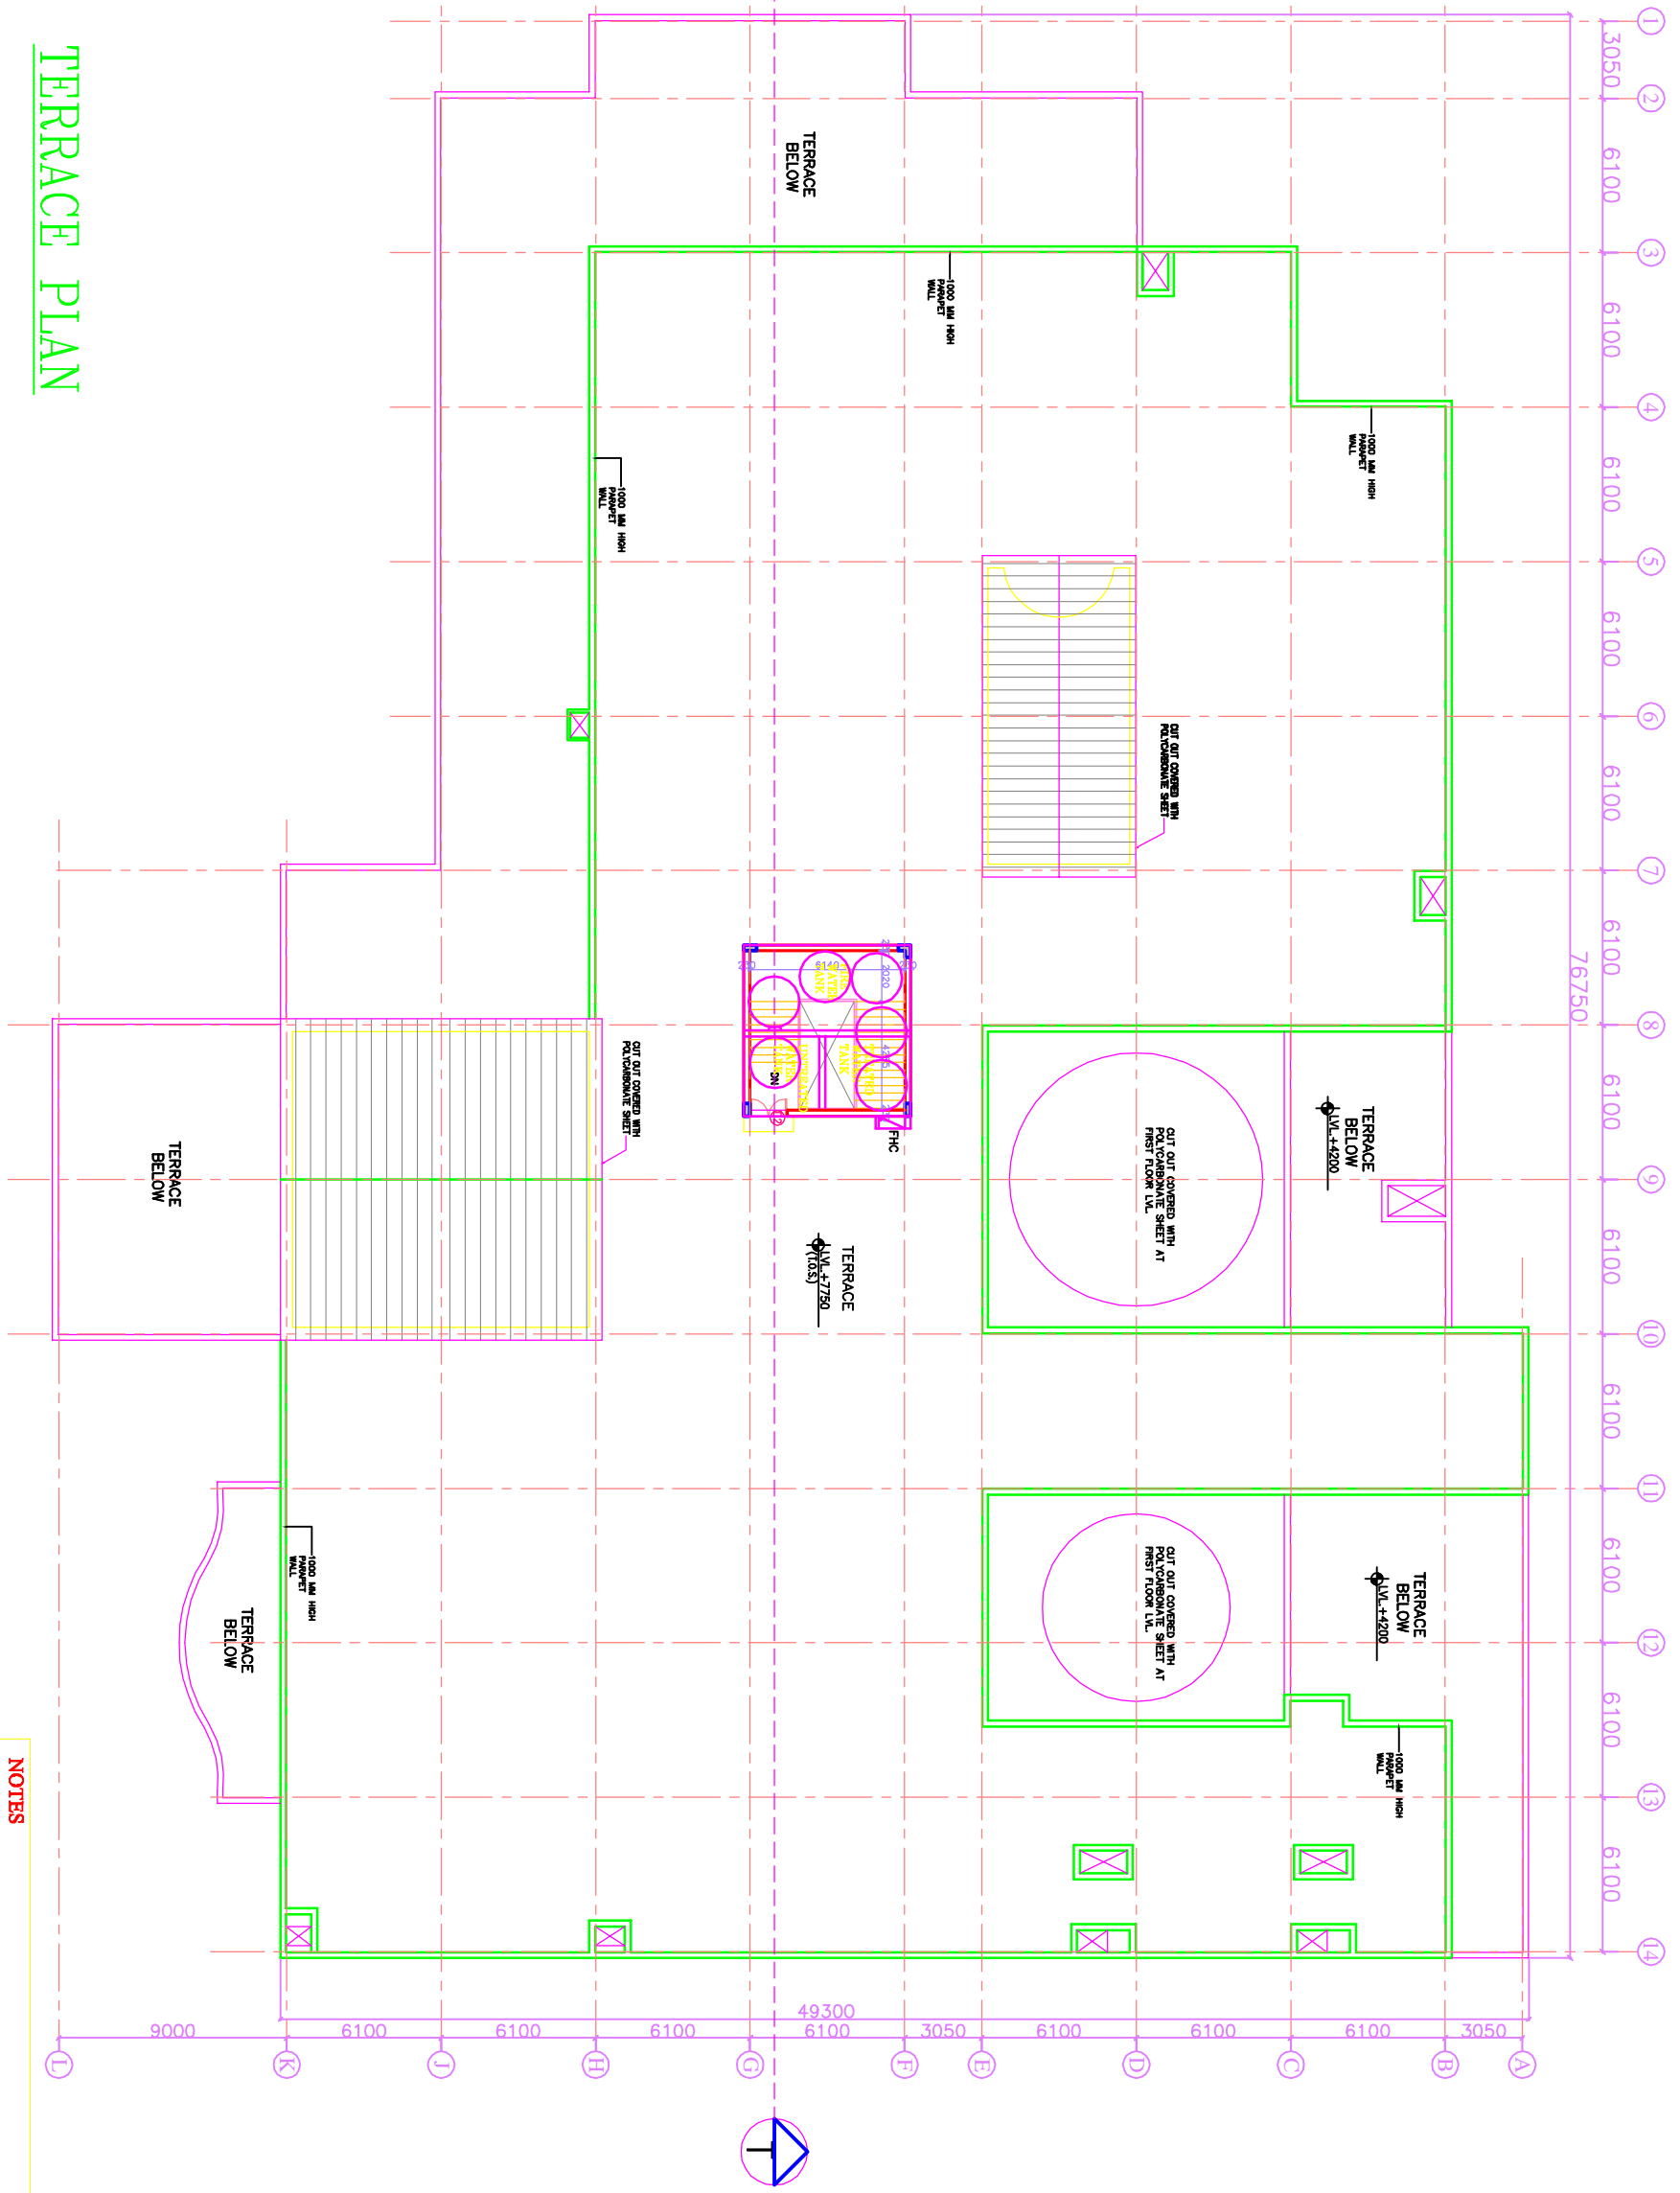

TERRACE PLAN


- NOTES**
1. BASED ON THIS DRAWING EXECUTING AGENCY WILL PREPARE SHOP DRAWING AFTER INCORPORATING THE CHANGES AS PER SITE CONDITION FOR THE APPROVAL OF HSCC BEFORE START OF WORK.
 2. THE NUMBER & LOCATION OF FIXTURES & WET POINT TO BE FINALIZED BEFORE EXECUTION WITH CLINT OFFICER'S INCHARGE..

ELECTRICAL

DRAWINGS

This drawing with all its contents is the sole intellectual property of the HSCC (INDIA) LIMITED (A GOVERNMENT OF INDIA ENTERPRISE) (INCORPORATED IN INDIA) and shall remain the property of HSCC (INDIA) LIMITED. No part of this drawing may be reproduced, stored in a retrieval system, or transmitted in any form or by any means, electronic, mechanical, photocopying, recording, or by any information storage and retrieval system, without the written permission of HSCC (INDIA) LIMITED. Any unauthorized use or reproduction of this drawing is strictly prohibited.

NOTES

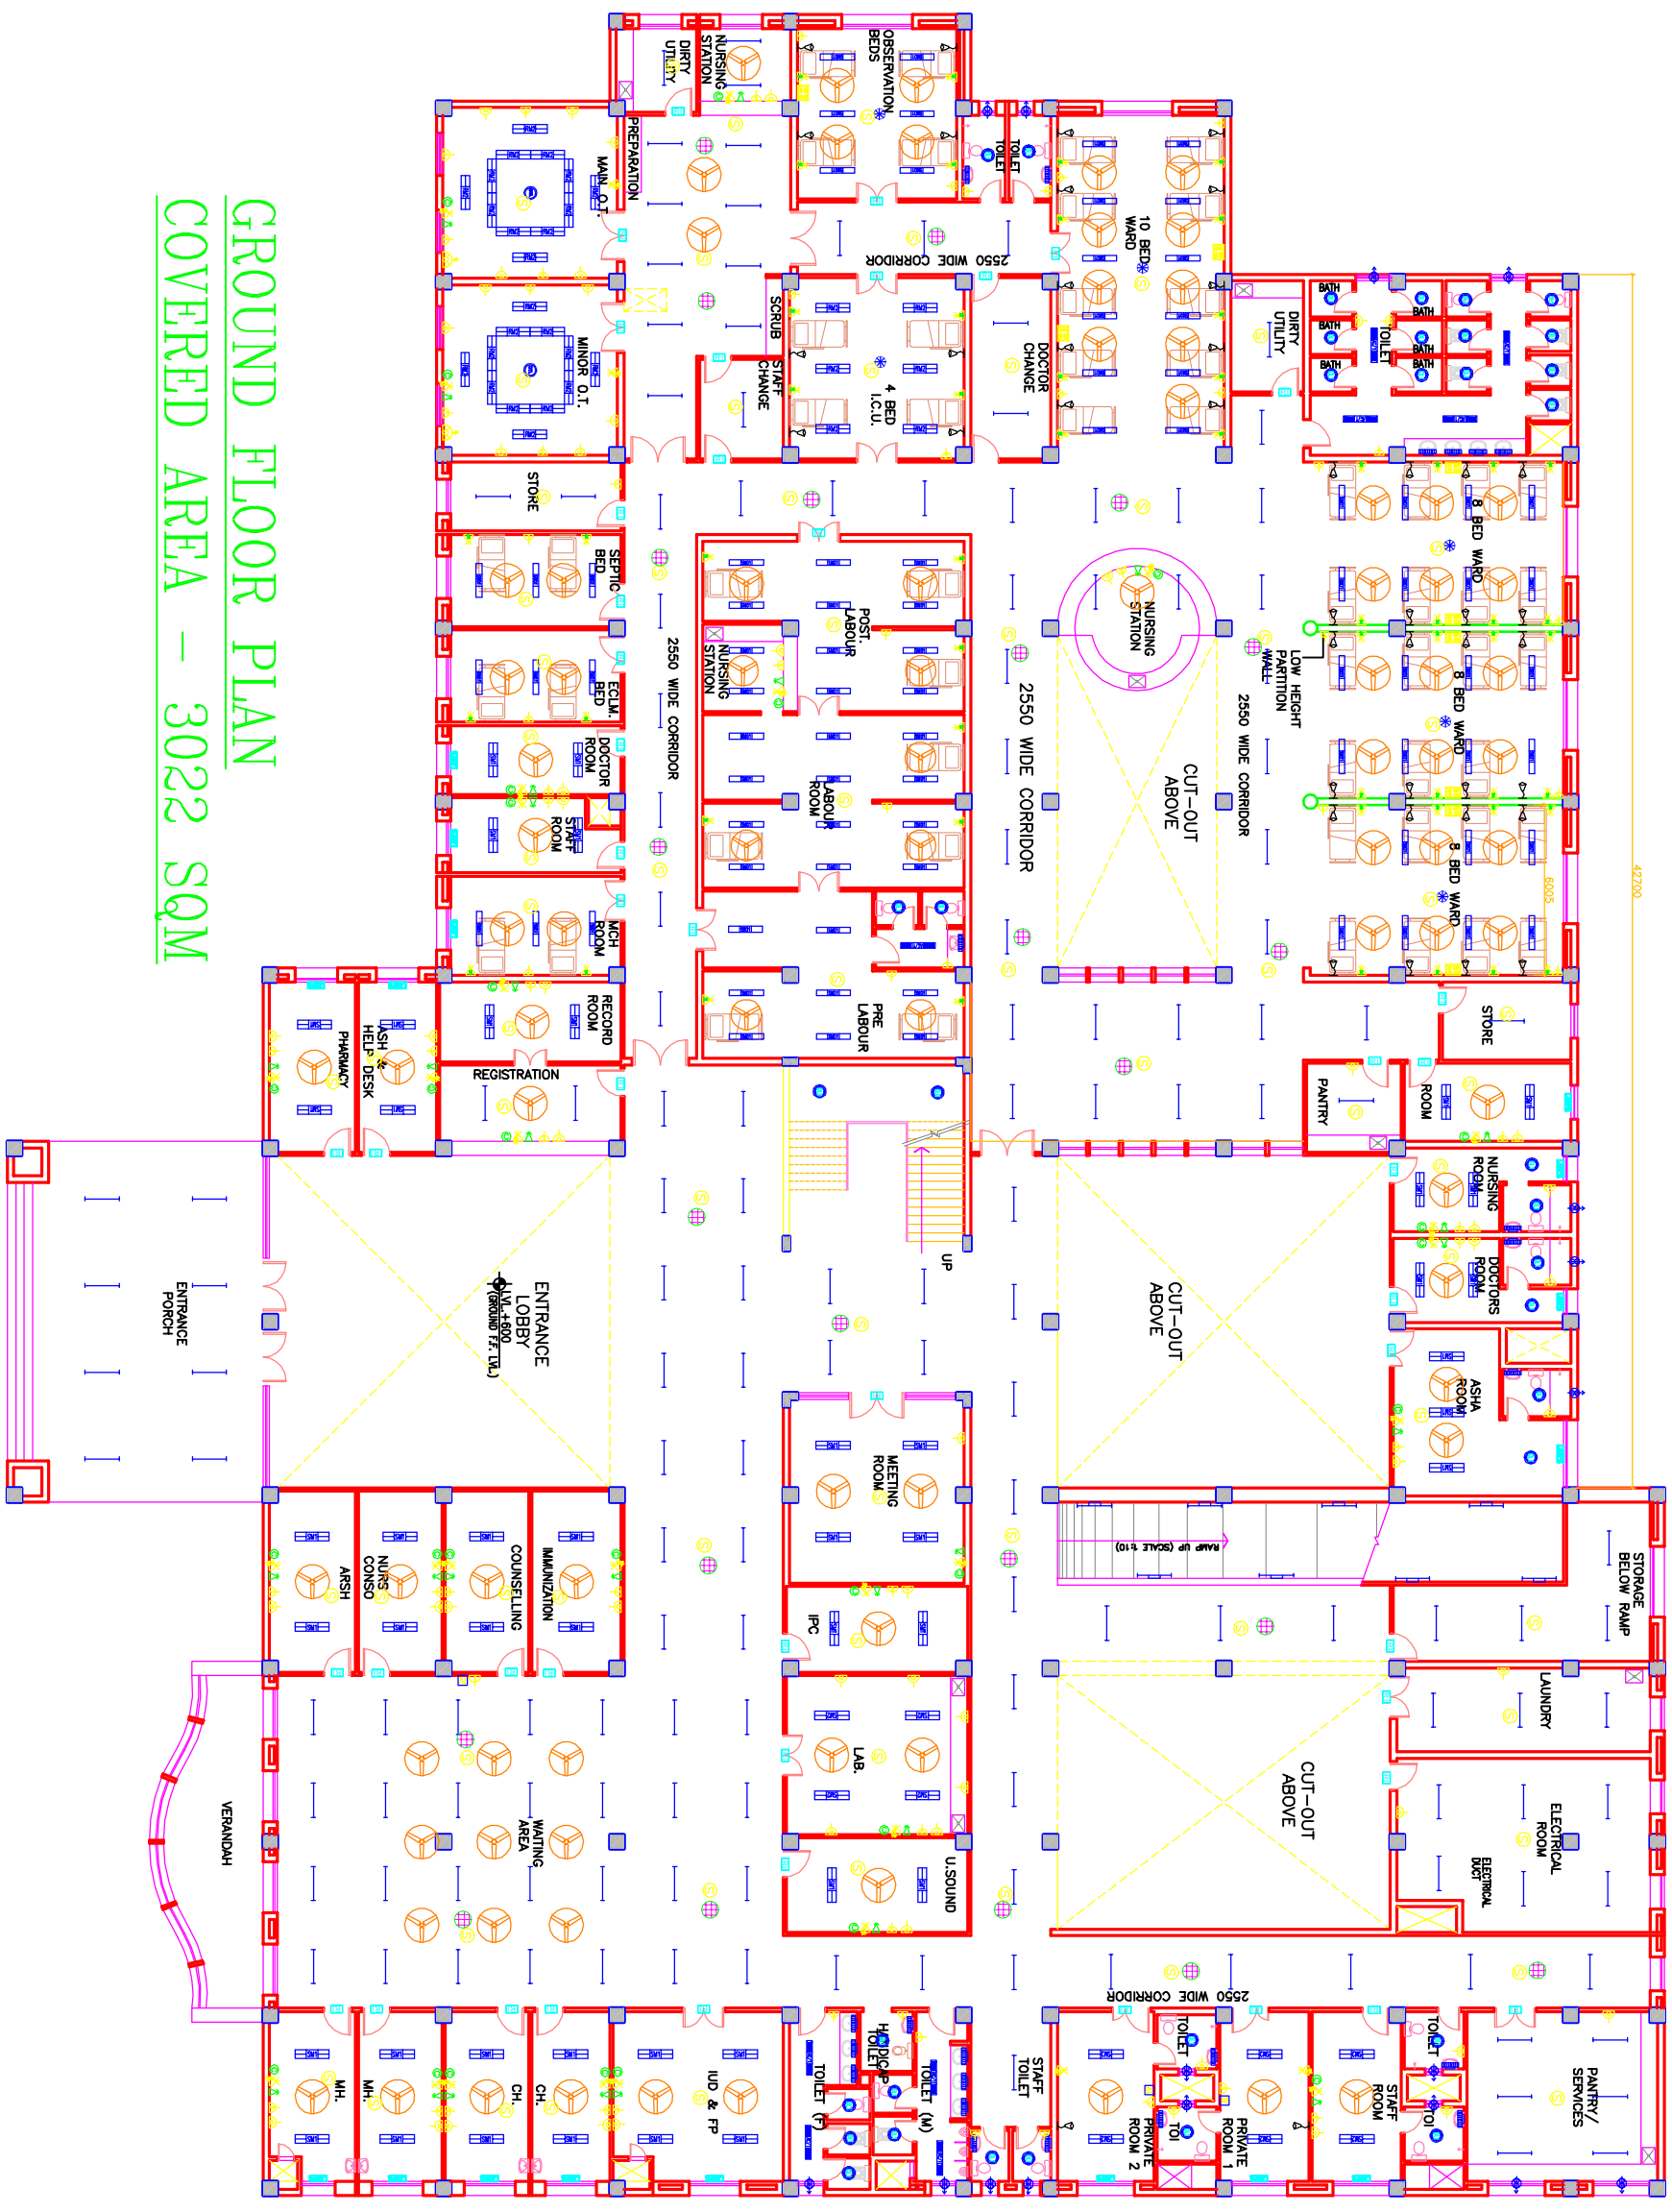


GROUND FLOOR PLAN
COVERED AREA - 3022 SQM

| | | | |
|-----------------------------|--|--------------------|--|
| REV. DATE | | DESCRIPTION | |
| | | | |
| PROJECT | | | |
| RMNCH PROJECT | | | |
| Proposed | | | |
| 100 Bedded Hospital | | | |
| AT | | | |
| CHATTISGARH | | | |
| TITLE | | | |
| MODEL PLANS | | | |
| GROUND | | | |
| FLOOR PLAN | | | |
| ELECTRICAL LAYOUT | | | |
| (COVERED AREA=3022 SQ. MT.) | | | |
| HSCC/INDIA/DEL-101 | | R-0 | |
| Drawing No. | | Rev. | |
| HSCC/- | | NTS | |
| Job No. | | Scale | |
| | | Date | |
| App by | | Rev. by | |
| | | Prep. by | |

This drawing with all its contents is the sole intellectual property of the HSCC (INDIA) LIMITED (a Government of India Enterprise). Any use or part thereof for any purpose without the written permission of HSCC is prohibited.

NOTES

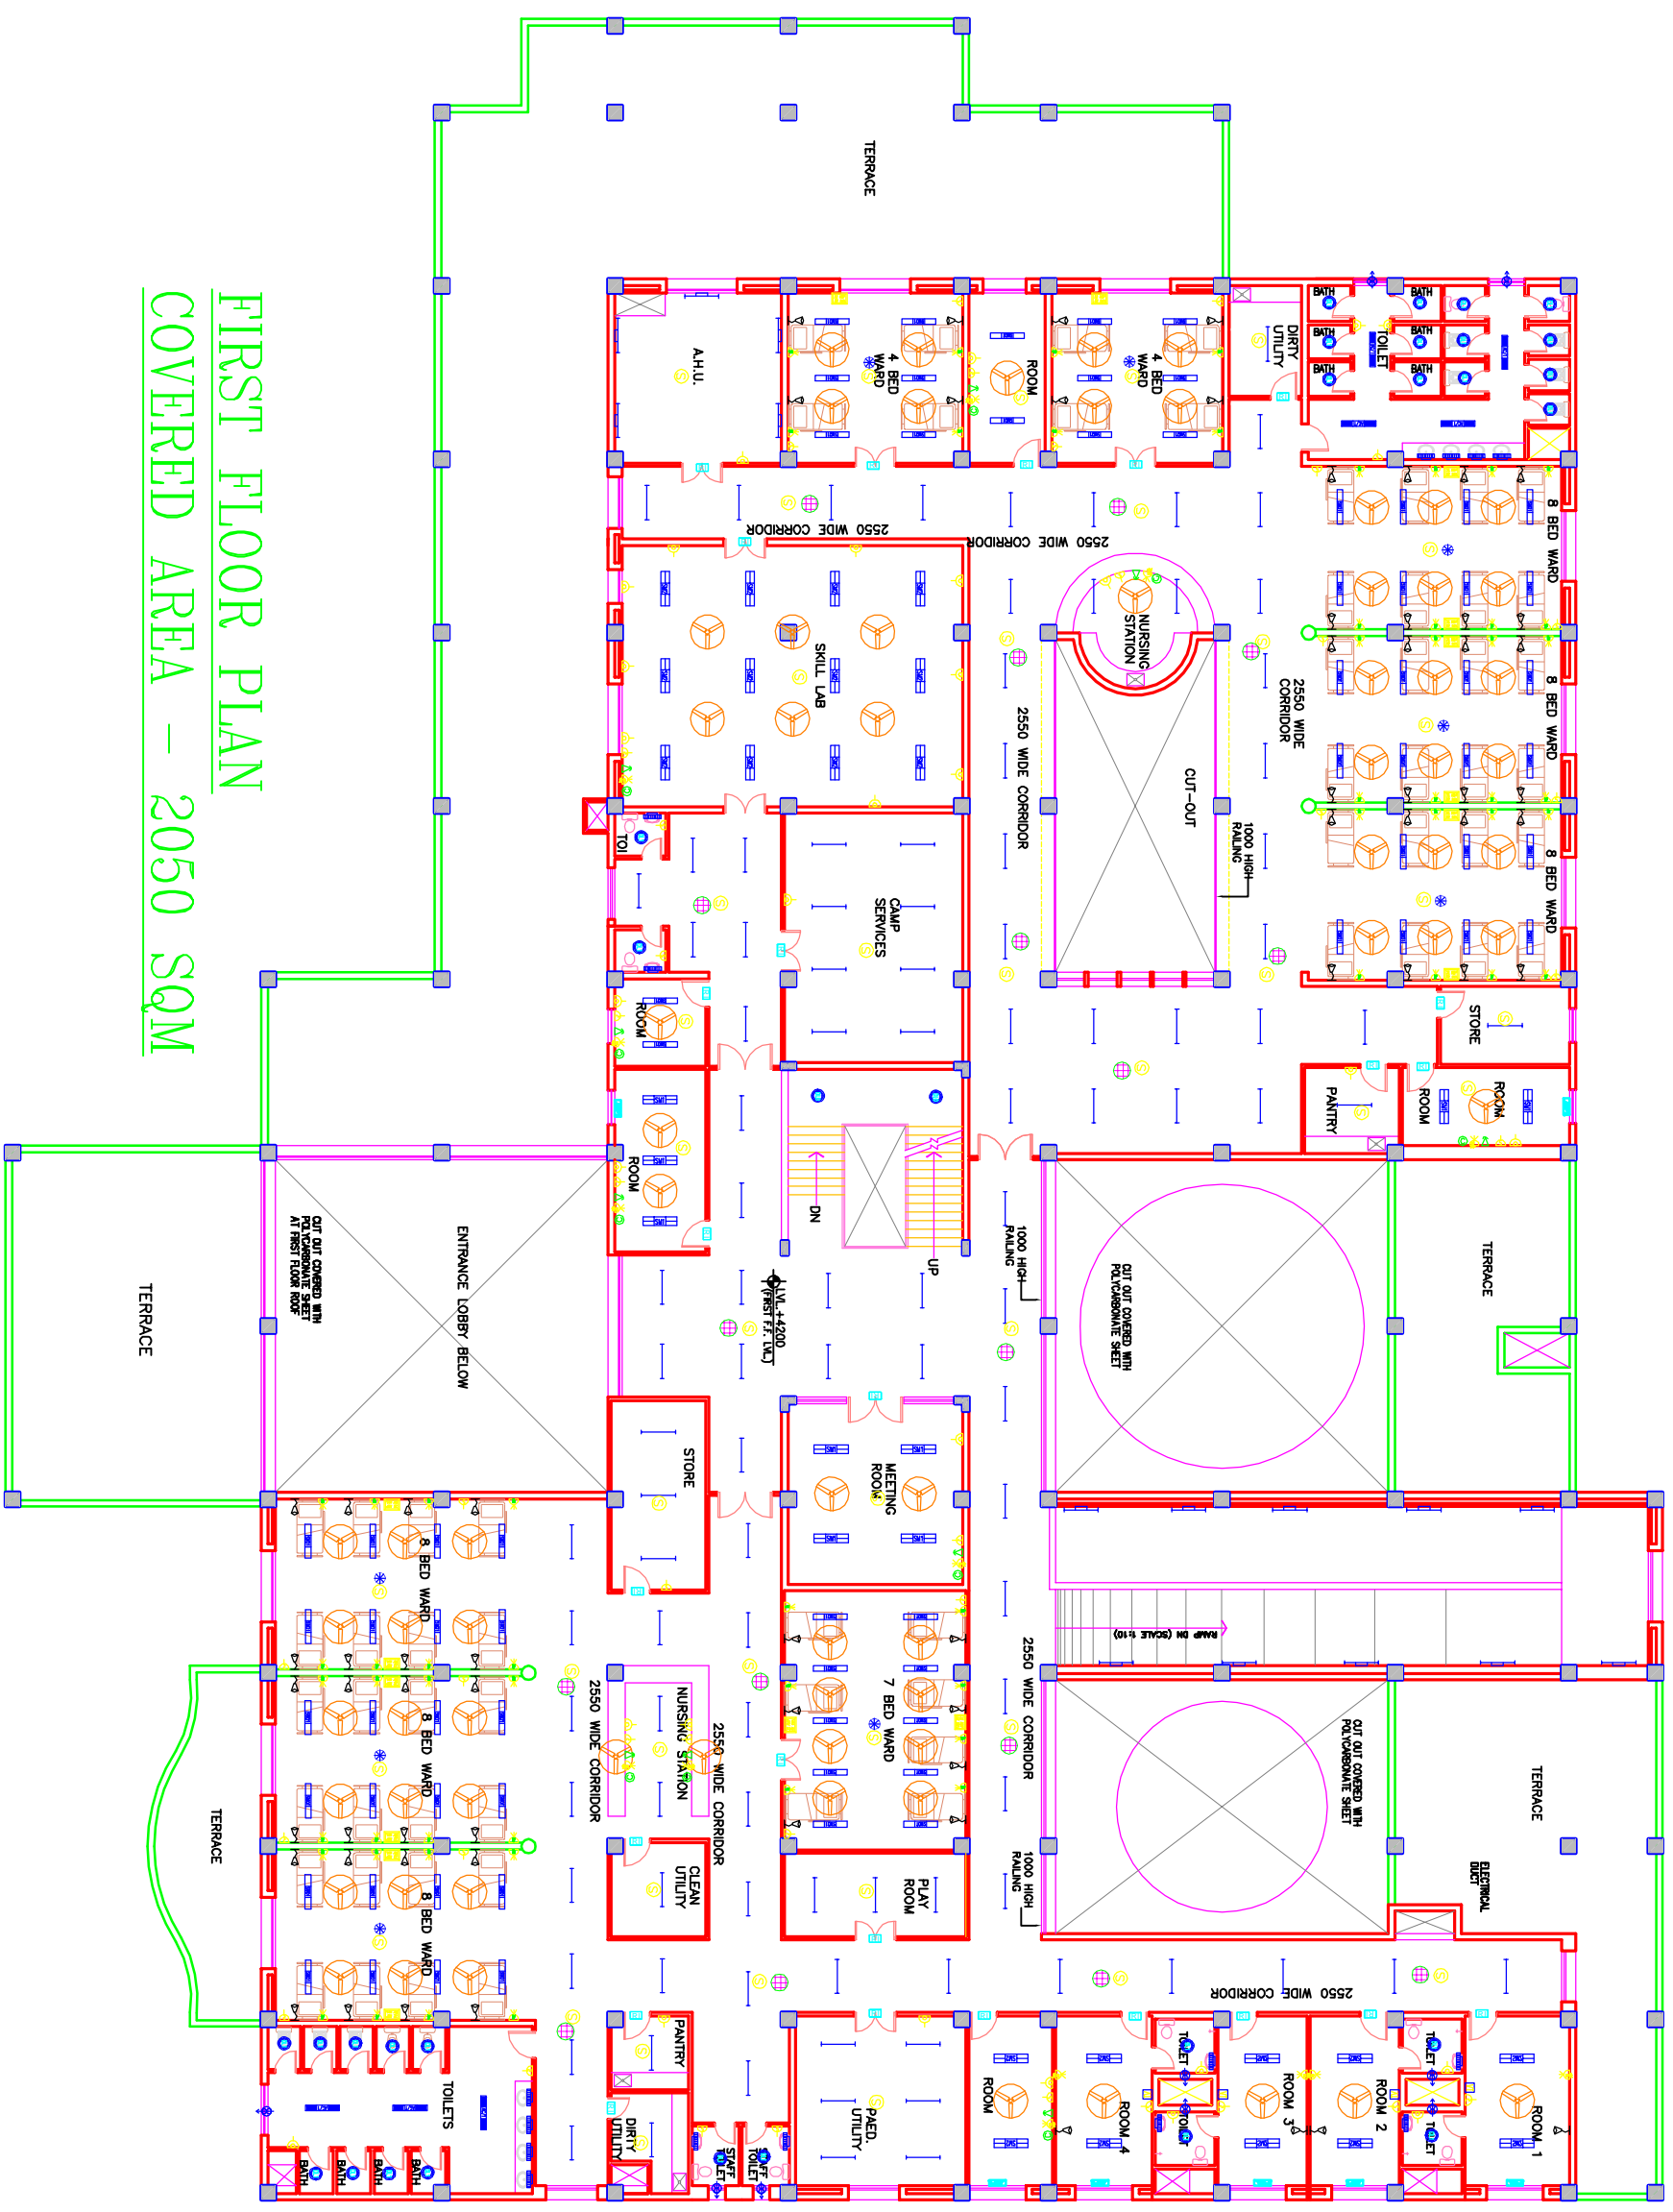


FIRST FLOOR PLAN
COVERED AREA – 2050 SQM

| | | | |
|--|-------------|----------|--|
| <p>PROJECT RMNCH PROJECT Proposed 100 Bedded Hospital AT CHATTISGARH</p> | | | |
| REV. DATE | DESCRIPTION | | |
| | | | |
| <p>TITLE MODEL PLANS FIRST FLOOR PLAN ELECTRICAL LAYOUT (COVERED AREA=2050 SQ. MT.)</p> | | | |
| HSCC/08&E/IDEL-102 | R-0 | | |
| Drawing No. | Rev. | | |
| HSCC/- | NTS | Date | |
| Job No. | Scale | | |
| App by | Rev. by | Prep. by | |

This drawing with all its contents is the sole intellectual property of the HSCC (INDIA) LIMITED (a Government of India Enterprise) and no part hereof shall be reproduced, stored in a retrieval system or transmitted in any form or by any means, electronic, mechanical, photocopying, recording, or otherwise, without the written permission of HSCC is prohibited.

NOTES

| | | | |
|---|-----------------|--|----------------|
| <p>PROJECT RMNCH PROJECT Proposed 100 Bedded Hospital AT CHATTISGARH</p> | | <p>TITLE MODEL PLANS TERRACE PLAN ELECTRICAL LAYOUT</p> | |
| <p>REV. DATE DESCRIPTION</p> | <p>REVISION</p> | <p>HSCC/D&E/ID/DEL-103</p> | <p>R-0</p> |
| <p>App by</p> | <p>Rev. by</p> | <p>Prep. by</p> | <p>Job No.</p> |
| <p>Scale</p> | <p>Date</p> | <p>NTS</p> | <p>Job No.</p> |

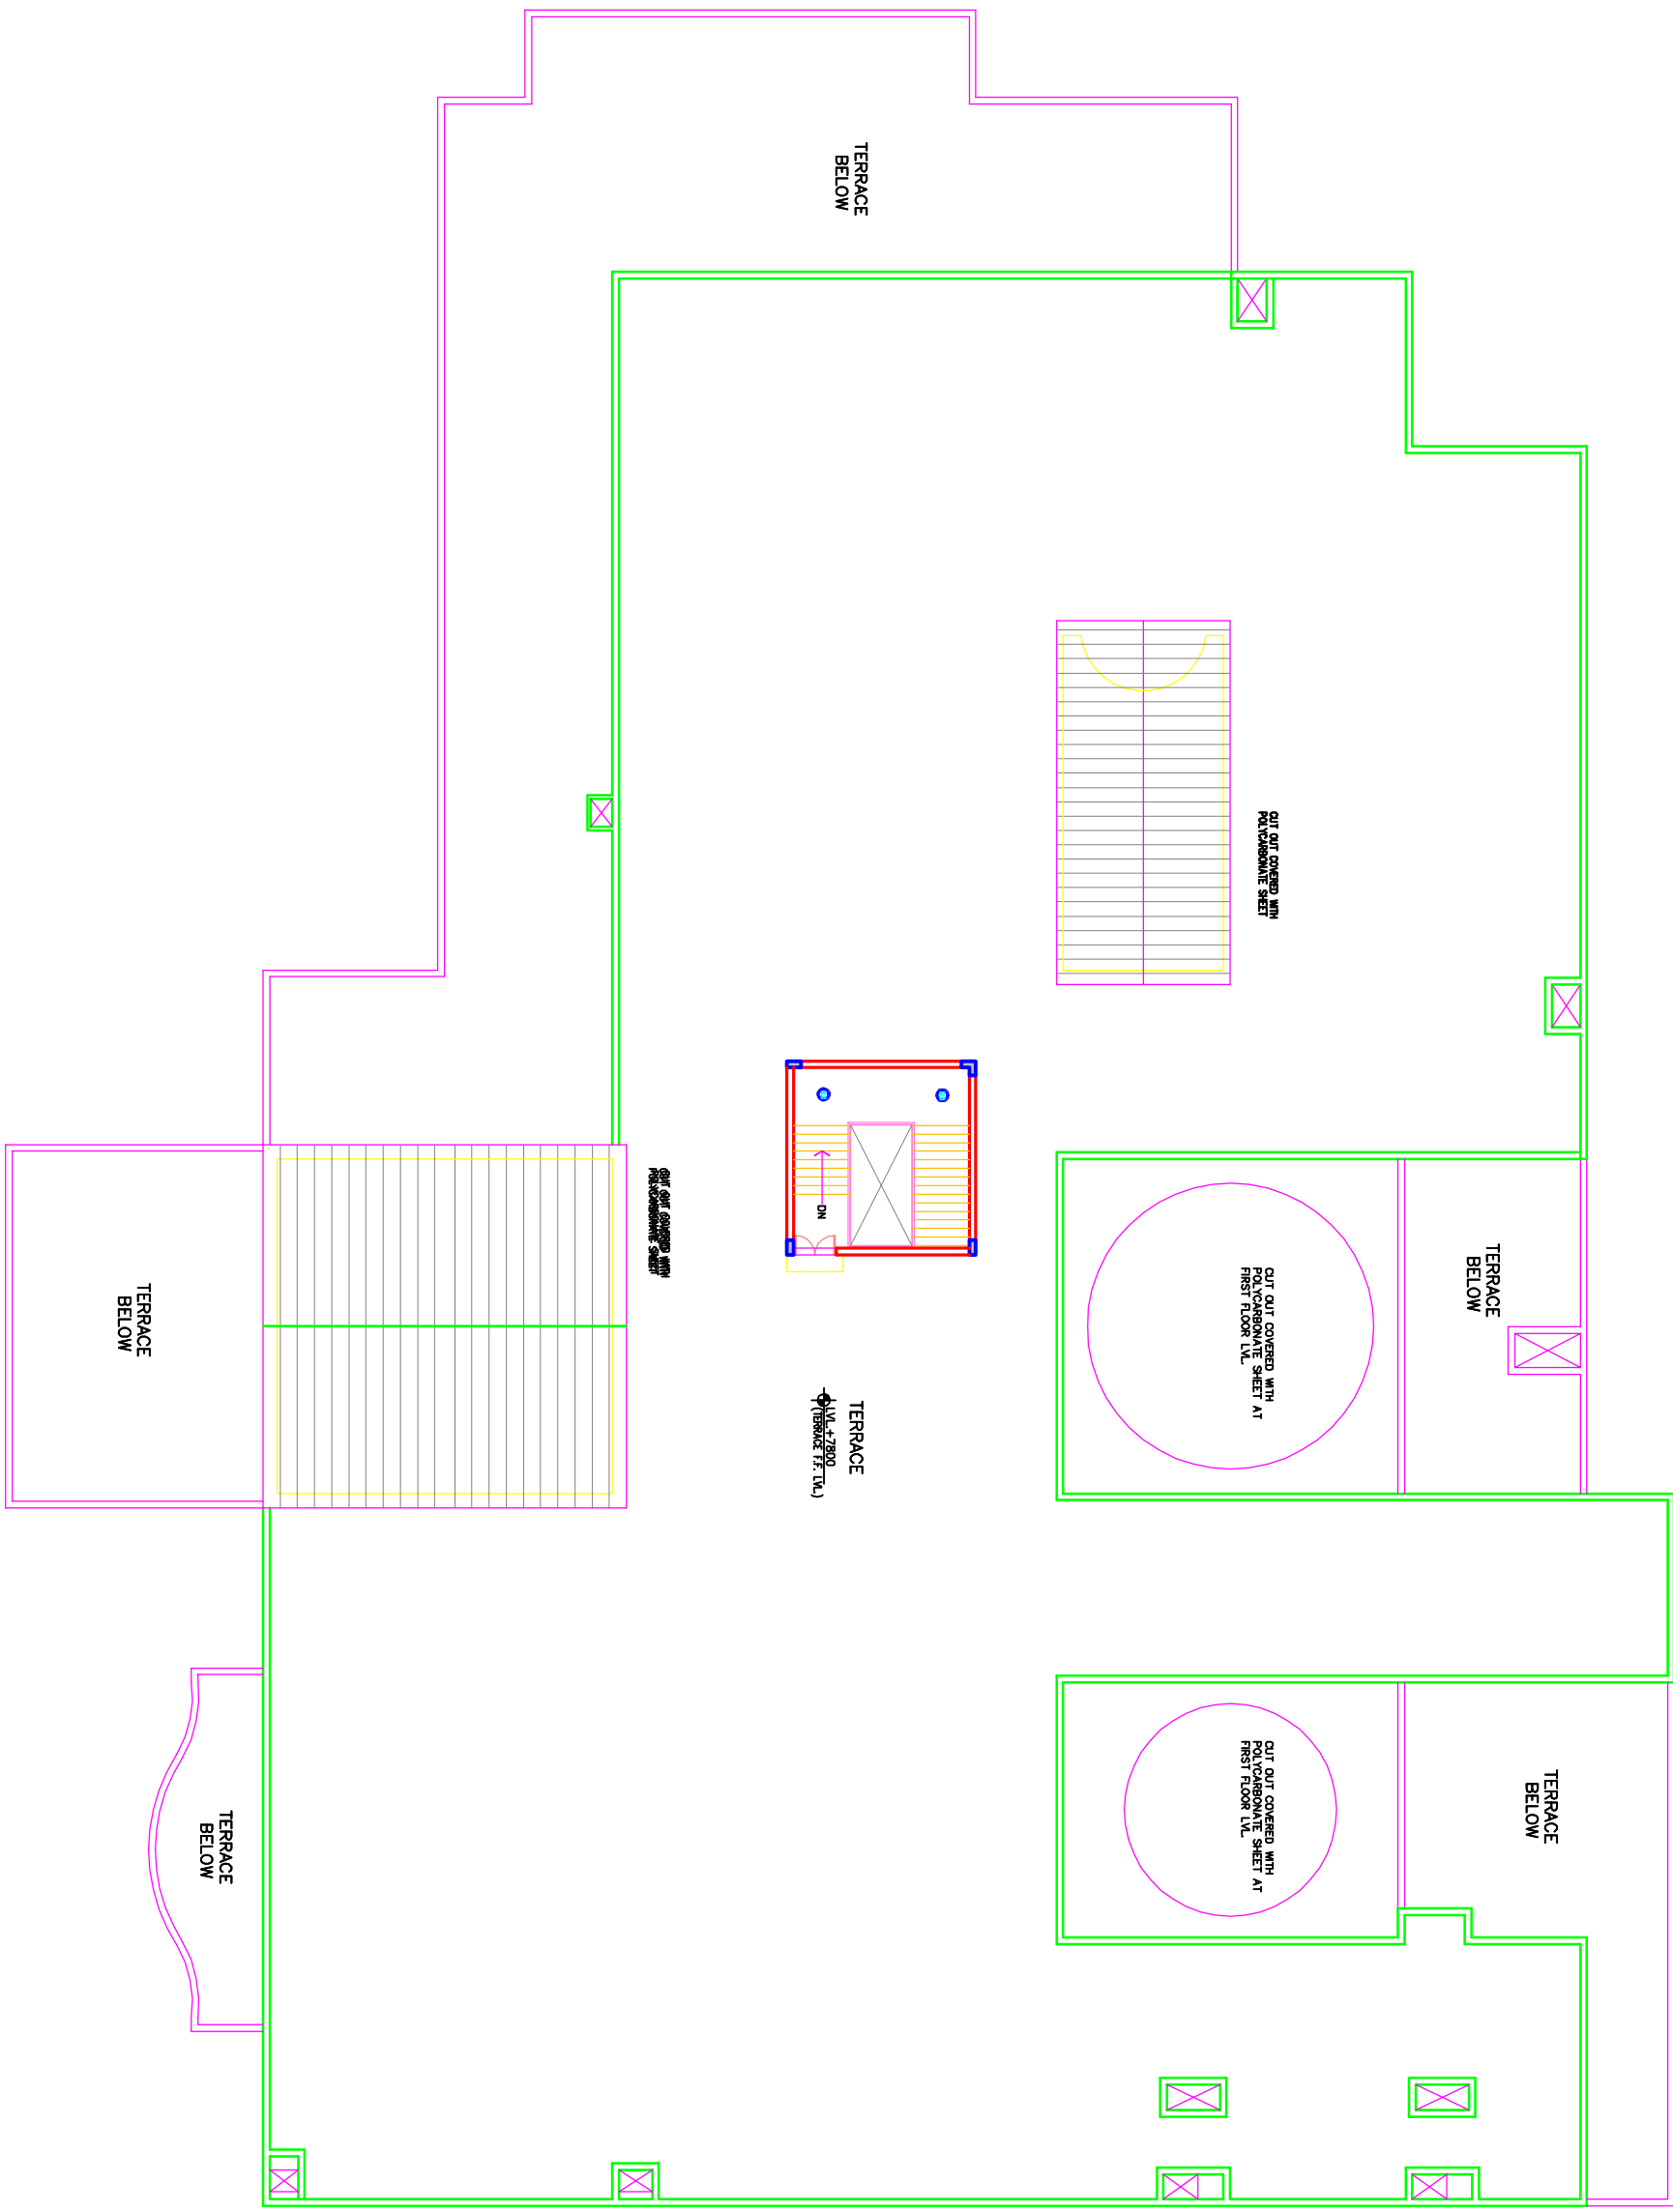

HVAC
DRAWINGS



NOTES

The drawing with all its contents is the sole intellectual property of the Institute of Health Care Consultants (India) Ltd. Copying of this drawing or part thereof in any form or by any means without the written permission of IHC is prohibited.

| REV | DATE | DESCRIPTION |
|-----|------|-------------|
| | | |
| | | |


PROJECT

Proposed
100 Bedded Hospital
At CHHATTISGARH

TITLE

TENDER DRAWING
GROUND FLOOR PLAN
HVAC LAYOUT
(COVERED AREA=3022 SQ. MT.)

| | |
|--------------------------|------------|
| ESCCD&EHTYAONRBNMCGAC-01 | R-0 |
| Drawing No. | |
| BSQC/- | 1:125 |
| Job No. | Scale |
| | 25-03-2013 |
| Date | |
| App by | Rev. by |
| | Prep. by |

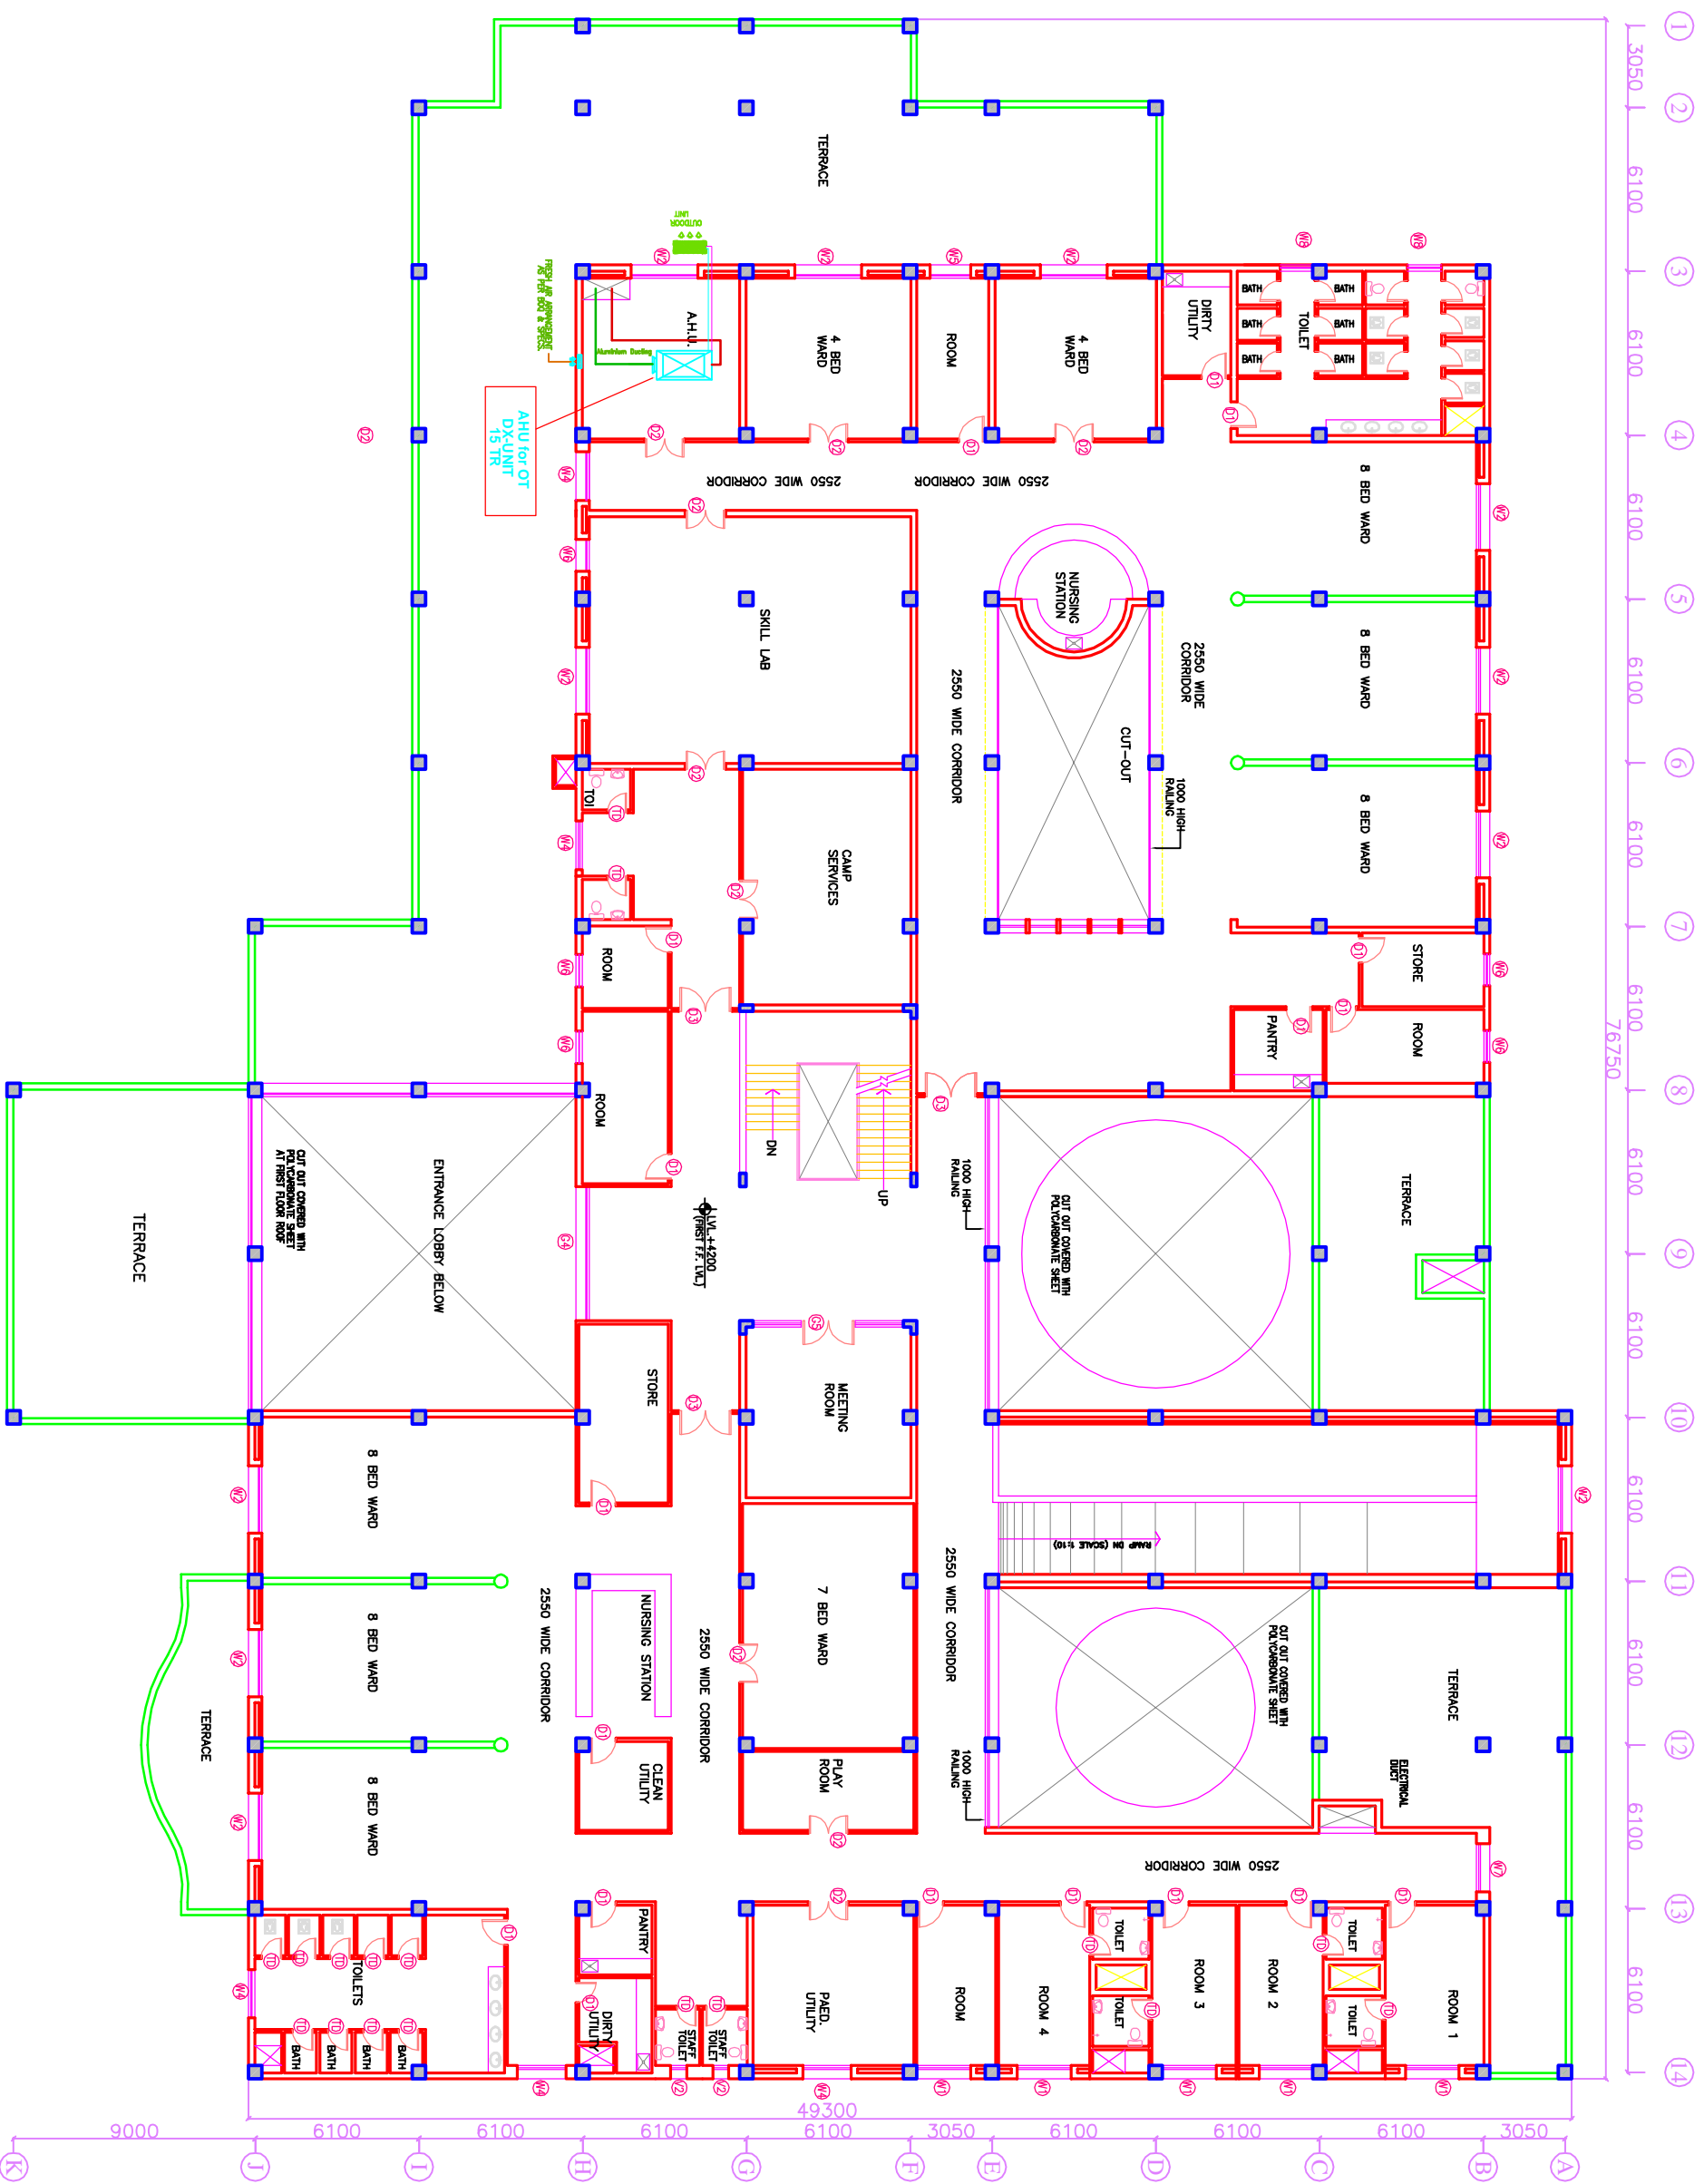

NOTES

The drawing with all its contents is the sole intellectual property of the Institute of Engineers (India) Ltd. Copying of this drawing or part thereof in whole or in part without the written permission of IESCI is prohibited.

| REV | DATE | DESCRIPTION |
|-----|------|-------------|
| | | |
| | | |

PROJECT

Proposed
100 Bedded Hospital
At CHHATISGARH

TITLE

TENDER DRAWING
FIRST FLOOR PLAN
HVAC LAYOUT
(COVERED AREA=2050 SQ. MT.)

| | |
|-------------------------------|------------|
| ESCCD&E/HT/AC/ENR/HA/CG/AC-02 | R-0 |
| Drawing No. | Rev. |
| BS/CC/- | 1:125 |
| Job No. | Scale |
| | 19-03-2013 |
| | Date |
| App by | Rev. by |
| | Prep. by |