

**Dr. Rajendra Prasad Government Medical College
Kangra at Tanda(HP)-176 001**

**Horticulture and Landscaping Works in front of
existing OPD Block at Dr.RPGMC, Kangra at
Tanda (H.P)**

• TENDER DRAWING

VOLUME - III

January' 2015



**HSCC (INDIA) LTD.
(CONSULTANTS & ENGINEERS FOR MEGA HOSPITALS & LABORATORIES)
E-6(A), Sector-1, NOIDA(U.P) 201301 (India)**

Phone : 0120-2542436-40

Fax : 0120-2542447

Tender No. HSCC/Horticulture/Tanda/2015

This drawing with all its contents is the sole intellectual property of the Hospital Services Consultancy Corporation (India) Ltd. Copying of this drawing or part thereof for its use in any form whatsoever without the written permission of HSCC is prohibited.

- NOTES:-**
1. ALL DIMENSIONS ARE IN MM.
 2. ONLY WRITTEN DIMENSIONS ARE TO BE FOLLOWED. DRAWINGS SHOULD NOT BE SCALED UNDER ANY CIRCUMSTANCES. ALL MEASUREMENTS MUST BE CHECKED AND VERIFIED BY THE CONTRACTORS PRIOR TO EXECUTION OF WORK AT THE SITE.
 3. THIS DRAWING IS TO BE READ IN CONJUNCTION WITH ALL RELEVANT STRUCTURAL, SERVICES & FACILITY PLANNING DRAWINGS.
 4. ARCHITECTURAL DRAWINGS ARE TO BE FOLLOWED FOR THE LOCATION OF ALL STRUCTURAL MEMBERS & MASONRY WALLS.
 5. FOR SIZES & REINFORCEMENT DETAILS OF STRUCTURAL MEMBERS RELEVANT STRUCTURAL DRAWINGS ARE TO BE REFERRED.
 6. ANY DISCREPANCIES BETWEEN ARCHITECTURAL, STRUCTURAL AND SERVICES DRAWINGS MUST BE BROUGHT TO THE NOTICE OF THE ARCHITECTS IMMEDIATELY & PRIOR TO EXECUTION AT SITE.
 7. CO-ORDINATION WITH THE SERVICES SUCH AS HVAC, PLUMBING & ELECTRICAL, ETC. IS THE RESPONSIBILITY OF THE CONTRACTORS.
 8. ALL MASONRY WALLS SHOULD BE ALIGNED WITH THE COLUMNS AS INDICATED ON THE PLAN IRRESPECTIVE OF THE POSITION AS CALCULATED WITH THE DIMENSIONING.
 9. FOR ELECTRICAL & LV SHAFT SIZE & LOCATION REFER ELECTRICAL DRAWINGS.
 10. FOR R.W.P., S.P., W.P. & M.W.S.P. SIZE & LOCATION REFER PLUMBING DRAWINGS.
 11. LIFT OPENINGS AS/LIFT APPROVED LIFT PROVIDER.
 12. BUILDING LAYOUT TO BE DONE AS/SITE CONDITIONS, LEAVING A CLEAR DISTANCE OF MIN.6000 MM AROUND THE BUILDING.

NO.	DATE	ISSUED
PRINTS ISSUED		
REV	DATE	DESCRIPTION
REVISION		


PROJECT
PROPOSED LANDSCAPE AT DR. RAJENDRA MEDICAL COLLEGE KANGRA, TANDA (H.P.)

TITLE
LANDSCAPE DETAILS AT 'A'

DRAWING No.

job no.	N.T.S scale	NOV/2014 date
App. By	AA Chkd. By	AA Pre. By.

HOSPITAL SERVICES CONSULTANCY CORPORATION (INDIA) LIMITED
 (A GOVERNMENT OF INDIA ENTERPRISES)
HSCC
 NEW DELHI INDIA

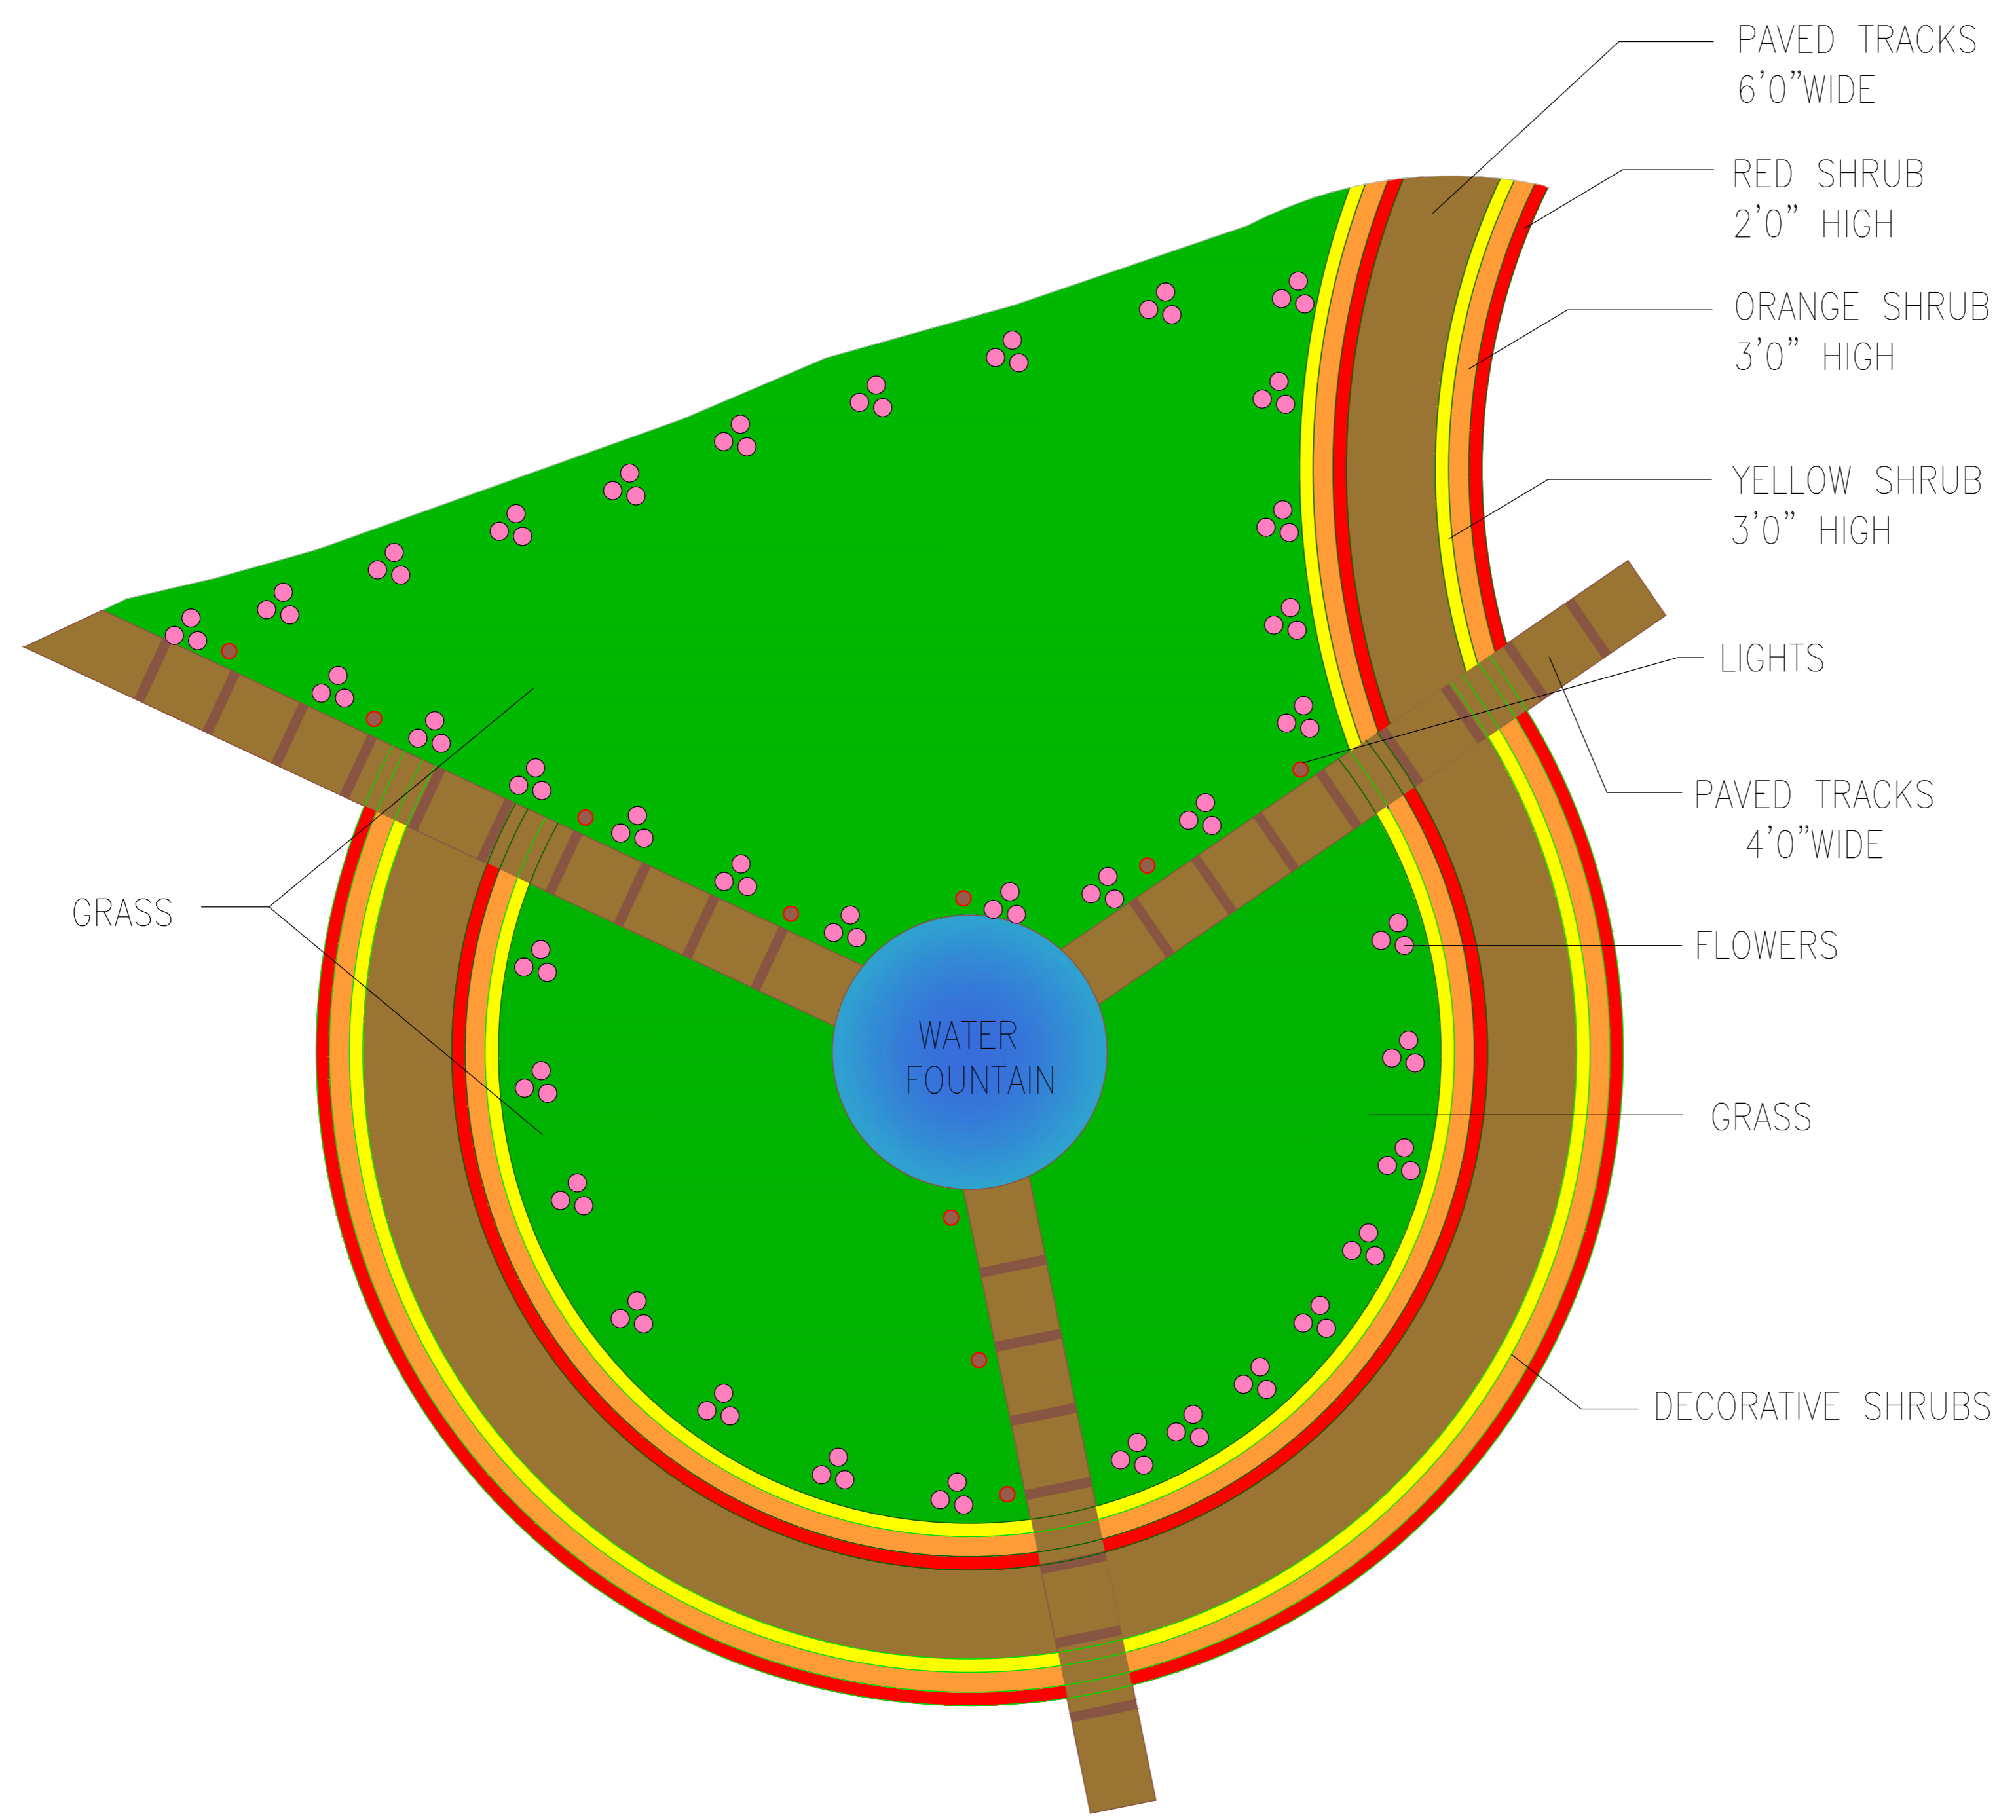

GRASS

WATER FOUNTAIN

PAVED TRACKS
6'0" WIDE

RED SHRUB
2'0" HIGH

ORANGE SHRUB
3'0" HIGH

YELLOW SHRUB
3'0" HIGH

LIGHTS

PAVED TRACKS
4'0" WIDE

FLOWERS

GRASS

DECORATIVE SHRUBS